


1 MAIN FLOOR LIGHTING PLAN  
SCALE: 1/4" = 1'-0"

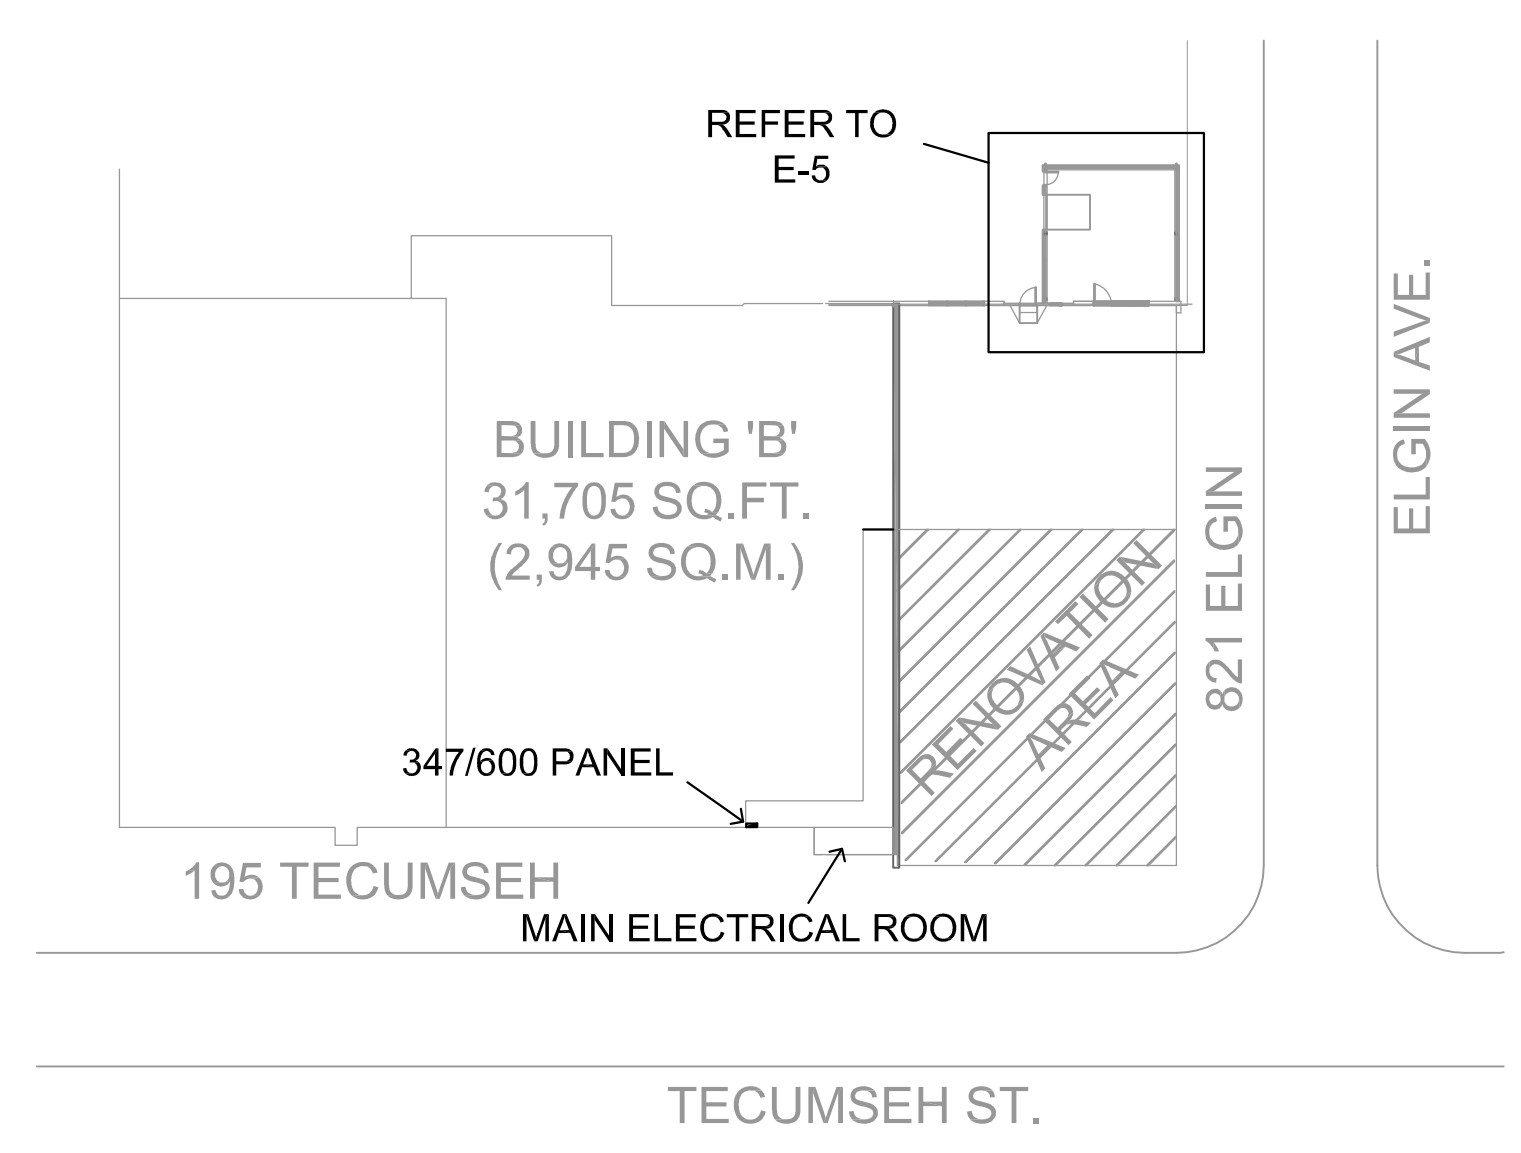

3 SITE PLAN  
E-1 NOT TO SCALE

**DRAWING NOTES:**

- ALL BOARD ROOM LIGHTS TO BE CONNECTED TO DIMMERS. ENSURE DIMMERS ARE RATED FOR THEIR INTENDED LOAD.
- ENSURE BATTERY UNIT IS ON STAIRWAY AND VESTIBULE LIGHTING CIRCUIT.
- ENSURE THAT HALLWAY LEADING TO EXIT HAS ADEQUATE EXIT SIGNAGE.
- RELOCATE SWITCH TO BESIDE NEW DOOR.

**GENERAL NOTES:**

- ENSURE THAT EXISTING WIRING EXPOSED OR AFFECTED DURING CONSTRUCTION IS REDONE OR REROUTED IN A PROPER MANNER. RE-USE CIRCUITS AND WIRING WHERE POSSIBLE. WHERE WIRING IS NOT RE-USED, STRIP BACK TO CLOSEST DISCONNECT OR PANEL.
- UNLESS SHOWN ON DRAWINGS, EXISTING LIGHTING AND SWITCHING TO REMAIN.
- ENSURE THAT ALL REMAINING FLUORESCENT LIGHTS ARE UPGRADED TO T-8'S. PROVIDE NECESSARY STICKERS SHOWING REQUIRED INFORMATION. REPAIR ANY DAMAGED SOCKETS AND LENSES.
- REMOVE AND PROPERLY DISPOSE OF ALL LIGHTS WHICH WILL NO LONGER BE USED.
- EXIT SIGNS THROUGHOUT BUILDING MUST BE CONSISTENT. CHANGE EXISTING SIGNS TO GREEN PICTOGRAM TO MATCH NEW SIGNS IN OFFICE AREA. ALTERNATIVELY, IN CONSULTATION WITH CITY OF WINNIPEG, NEW SIGNS IN OFFICE AREA MAY BE RED LETTER TO MATCH EXISTING SIGNS.
- ENSURE THAT EMERGENCY AND EXIT LIGHTS ARE ON LOCAL NIGHT LIGHT CCT.

**LIGHTING SCHEDULE**

TYPE	DESCRIPTION	LAMPS	NOTES
A	CREE AR24-40L-40K-S	40W LED	DIMMABLE
B	LITHONIA 2GT8-2-32-120-GE10IS-CSA	2 32W T8	
C	LITHONIA WRT-G-2-32-MVOLT-GE10IS-CSA	2 32W T8	
D	LITHONIA 2-2-32-MVOLT-GE10IS-CSA-ZBASR	2 32W T8	
E	LITHONIA SB-2-32-MVOLT-GE10IS-CSA	2 32W T8	
F	JUNO TC-1	8W LED	A - BASE LAMP
G	PHILIPS LIGHTOLIER S7R830K10	14.2W LED	ROUGH IN WITH 2-1/8" DEEP OCTAGON BOX
H	LEVITON 001-9863-OCC	13W CFL	
J	LITHONIA 2GT8-2-13-16-MVOLT-GE10IS-CSA	2 32W T8U	
K	LITHONIA SB-2-32-MVOLT-GE10IS-CSA	2 32W T8	
L	RC LIGHTING WPLED26RCL	26W LED	MOUNT ABOVE DOOR. CONTROL WITH PHOTOCELL ON LIGHT.
M	LITHONIA AV-L4-18L-MDR-EZ1 LP835	21W LED	

**EMERGENCY LIGHTING SCHEDULE**

EBU #1.2	EMERGENCY BATTERY UNIT LUMACELL RG125-100-2-LD9
EBU #3.4	EMERGENCY BATTERY UNIT LUMACELL RG125-36-2-LD9
EMH	EMERGENCY REMOTE HEADS LUMACELL MDM-2-LD9
ES	EMERGENCY EXIT SIGN (SINGLE FACE) LUMACELL LS-1-W-U
EDS	EMERGENCY EXIT SIGN (DOUBLE FACE) LUMACELL LS-2-W-U



**APEGM**  
Certificate of Authorization  
Jorey Electric Ltd.  
No. 4600 Date: 22 Jun 2015

**JOREY ELECTRIC**  
Engineering Consultants

6-1375 Nisakwa Road E  
Winnipeg MB R2J 3T3  
p. 204-255-4842  
e. info@joreyelectric.com

NO	REVISION	DATE	BY
2	RE-ISSUED FOR TENDER	22 JUN 2015	JJD
1	ISSUED FOR TENDER	12 JUN 2015	JJD
D	ISSUED FOR CONSTRUCTION	1 JUN 2015	JJD
NO	REVISION	DATE	BY

Project: TRANSPORTATION MANAGEMENT CENTRE RENOVATIONS  
821 ELGIN AVE., WINNIPEG, MANITOBA

Sheet Title: MAIN FLOOR LIGHTING PLAN  
SITE PLAN  
LIGHTING & EMERGENCY LIGHTING SCHEDULES

Date: 1 JUN 2015  
By: TD  
Project No: 14-131  
Sheet No: E-1/R-2