


1 STORAGE ADDITION LIGHTING PLAN
 E-5 SCALE: 1/4" = 1' - 0"

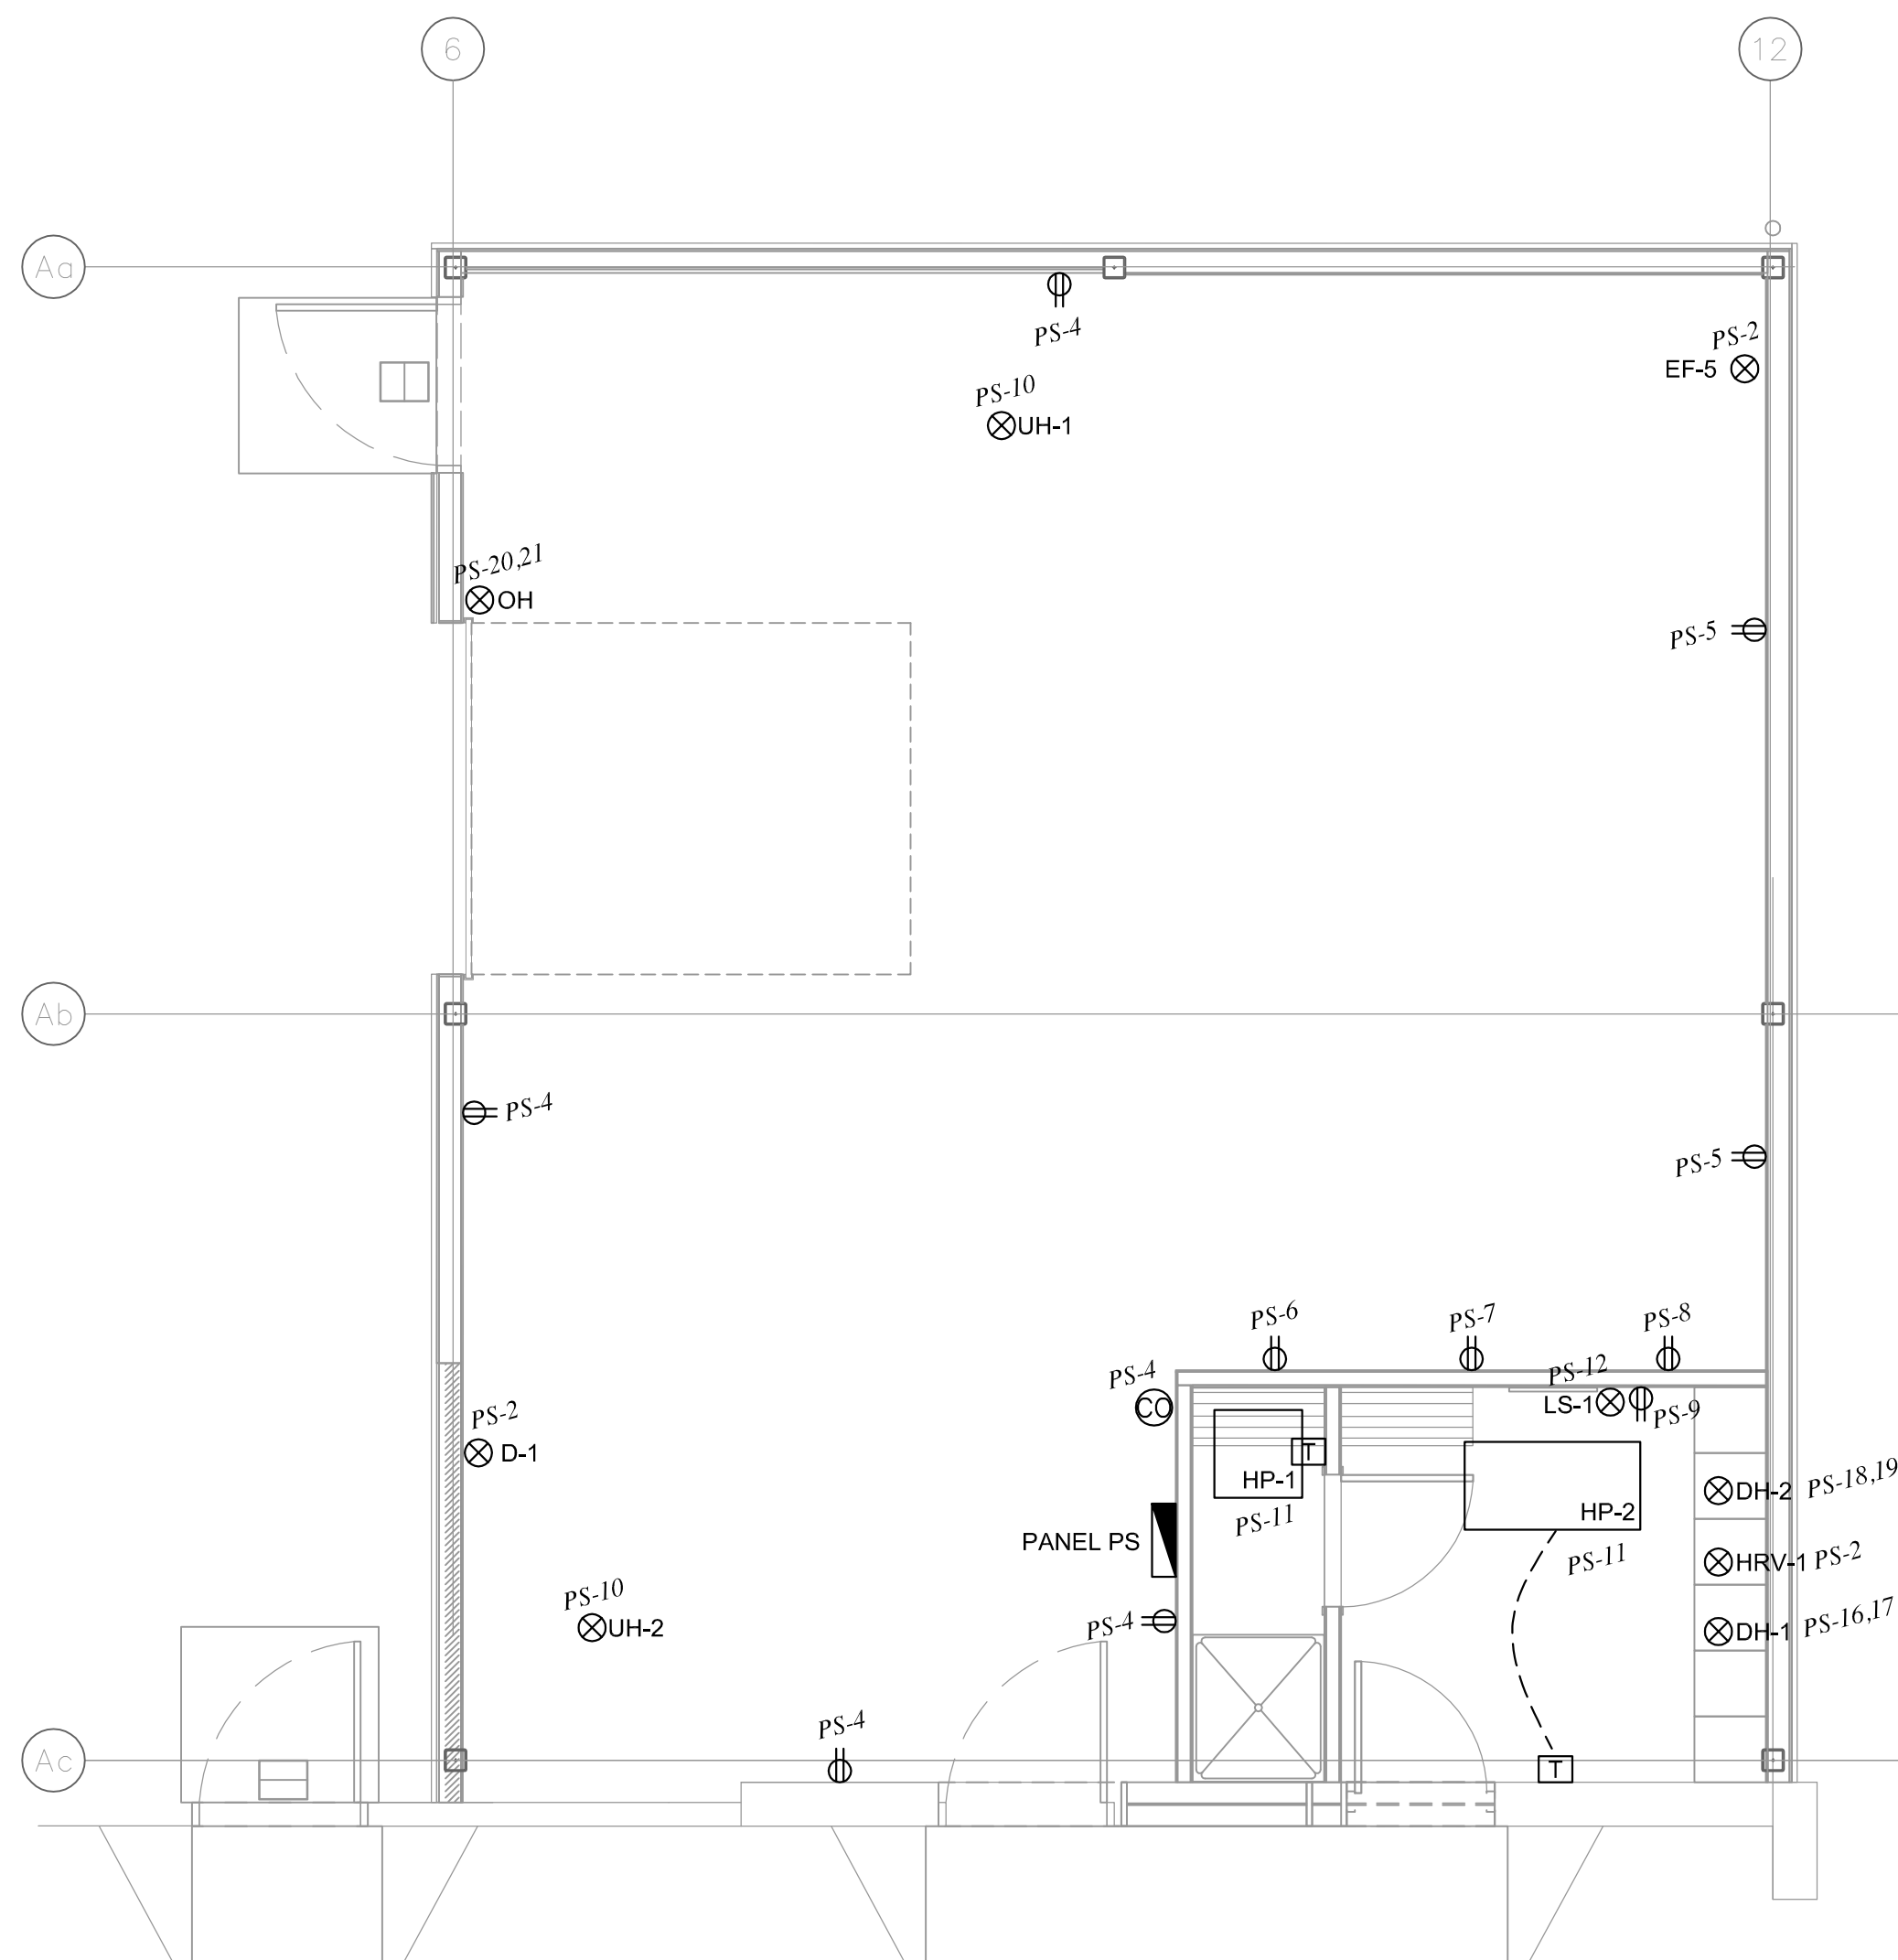


2 STORAGE ADDITION POWER PLAN
 E-5 SCALE: 1/4" = 1' - 0"

GENERAL NOTES:
 A. CONFIRM LOCATION OF ALL MECHANICAL EQUIPMENT.



APECM
 Certificate of Authorization
 Jorey Electric Ltd.
 No. 4600 Date: 12 Jun 2015

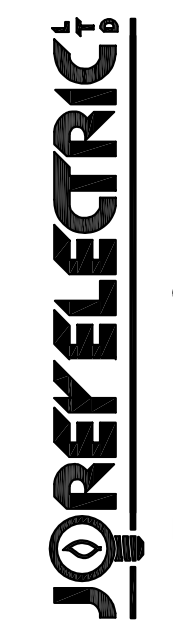

Jorey Electric Consultants
 p. 204-255-4842
 e. info@joreyelectric.com
 6-1375 Nisakwa Road E
 Winnipeg MB R2J 3T3

NO	REVISION	DATE	BY
1	ISSUED FOR TENDER	12 JUN 2015	JJD
2	ISSUED FOR CONSTRUCTION	1 JUN 2015	JJD

Project: TRANSPORTATION MANAGEMENT CENTRE RENOVATIONS
 821 ELGIN AVE., WINNIPEG, MANITOBA

Sheet Title: STORAGE ADDITION LIGHTING & POWER

Date: 1 JUN 2015 Sheet No.: E-5/R-1
 By: TD
 Project No.: 14-131