

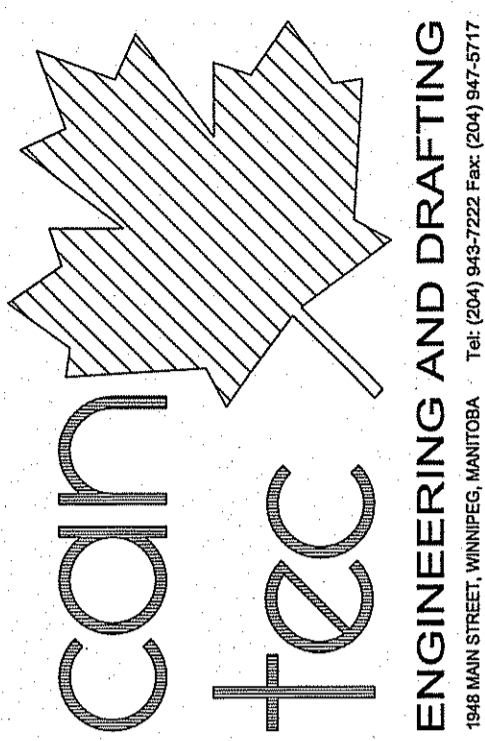


THIS DRAWING MUST NOT BE SCALED.
 THE GENERAL CONTRACTOR SHALL VERIFY ALL DIMENSIONS, DATUMS AND LEVELS PRIOR TO COMMENCEMENT OF WORK AND IS HELD RESPONSIBLE FOR REPORTING ANY DISCREPANCY OR OMISSION TO CAN-TEC SERVICES LTD IMMEDIATELY.
 THIS DRAWING IS THE EXCLUSIVE PROPERTY OF CAN-TEC SERVICES LTD. AND CAN BE REPRODUCED ONLY WITH THE PERMISSION OF CAN-TEC SERVICES LTD. IN WHICH CASE THE REPRODUCTION MUST BEAR THEIR NAME AS THE ENGINEERING/DRAFTING FIRM.
<http://www.cantecservices.com>

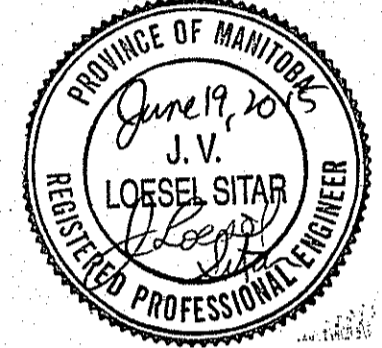

ENGINEERING AND DRAFTING
 194 MAIN STREET, WINNIPEG, MANITOBA
 TEL: (204) 943-1222 FAX: (204) 943-5771
<http://www.cantecservices.com>


| LEGEND | |
|--------|---------------|
| | SANITARY PIPE |
| | COLD WATER |
| | HOT WATER |
| | RECIRC LINE |
| | VENT PIPE |

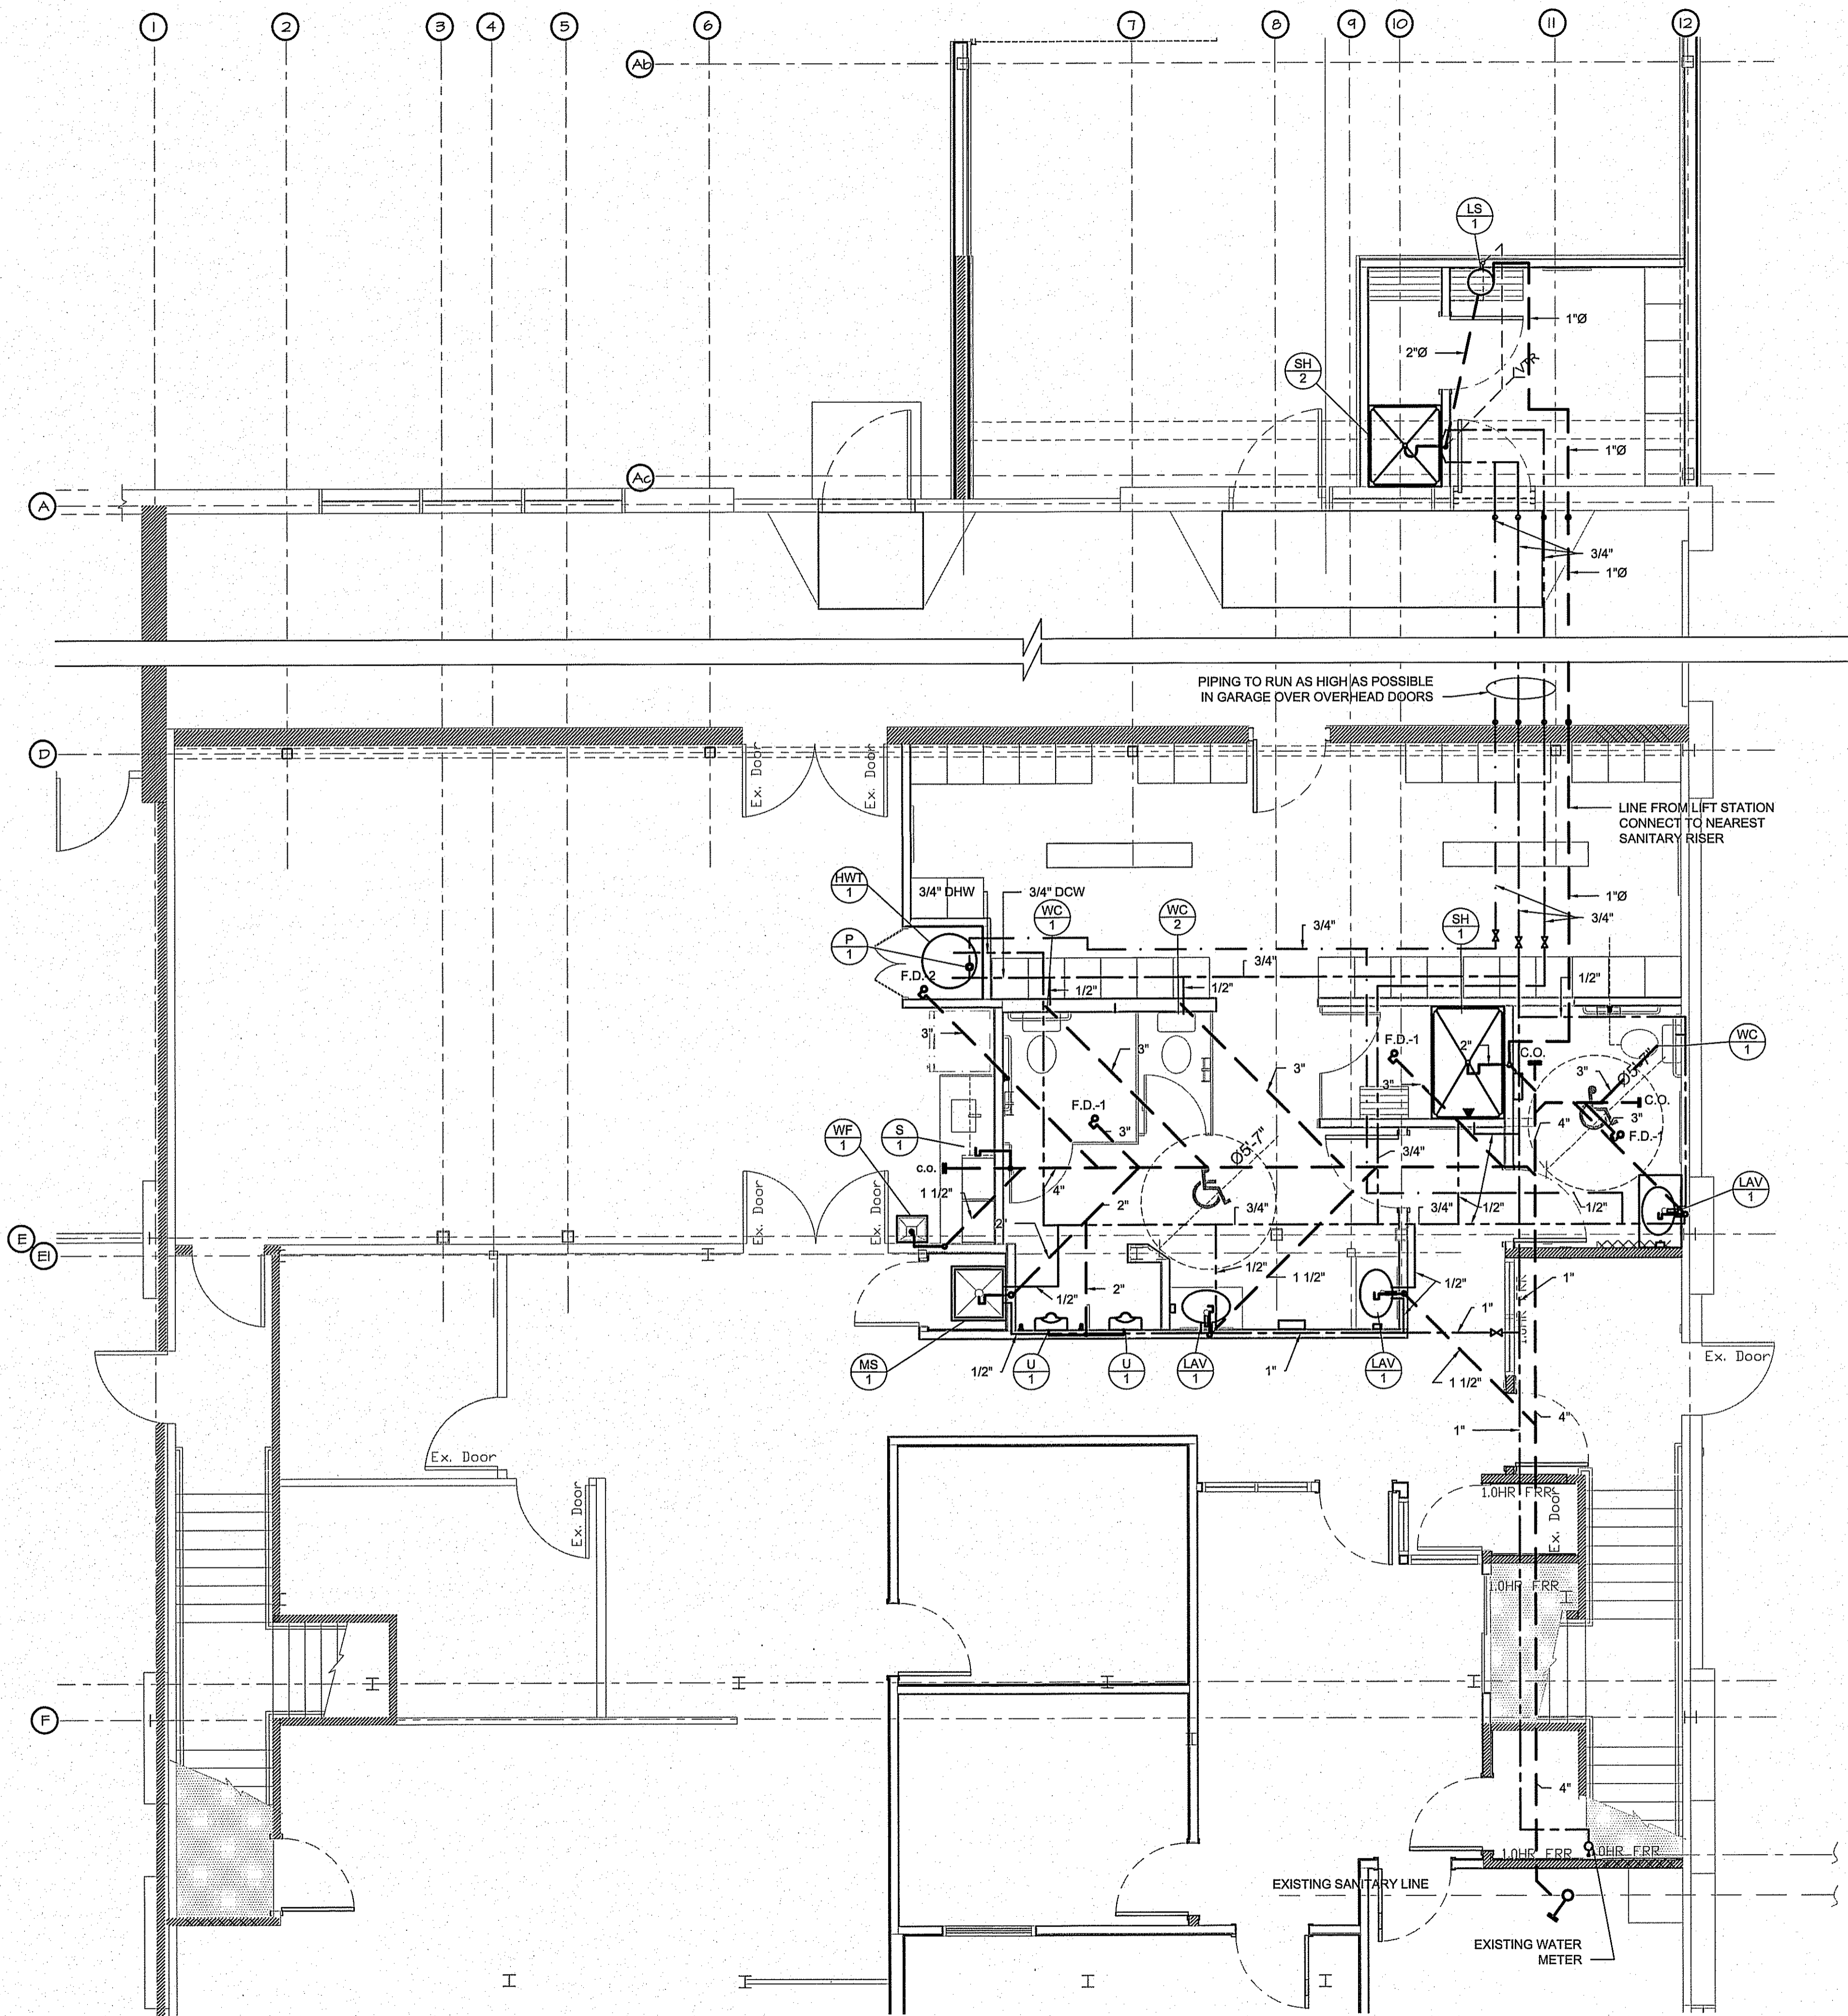

| REV. # | REVISION | DATE | REV. BY |
|--------|--------------------------------|----------|---------|
| 02 | ISSUED FOR CONSTRUCTION | 15 05 15 | JLS |
| 01 | ISSUED FOR TENDER | 15 05 12 | JLS |
| 0 | ISSUED FOR CONSTRUCTION PERMIT | 15 05 01 | JLS |
| C | ISSUED FOR REVIEW | 15 05 21 | JLS |
| B | ISSUED FOR REVIEW | 15 05 21 | JLS |
| 00 | ISSUED FOR REVIEW | 15 04 14 | JLS |

SEALED BY:

PROJECT TITLE
TRAFFIC MANAGEMENT CENTER - RENOVATIONS
 SHEET TITLE
MAIN FLOOR PLAN - PLUMBING
 DATE
 15 03 19
 SCALE
 AS NOTED
 CHECKED BY
 JLS
 DRAWN BY
 RS
 LOCATION
 821 ELGIN AVENUE, WINNIPEG, MANITOBA

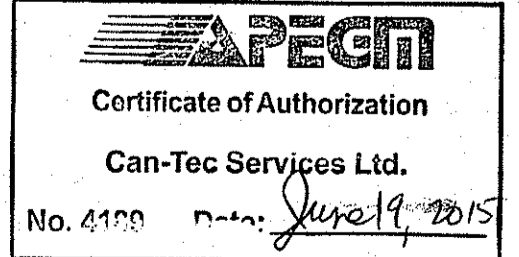

CONSTRUCTION
M1.0
 REVISION #: 02
 JOB NO.
14-112-14-30

1 PARTIAL MAIN FLOOR PLAN- PLUMBING
 METRIC SCALE: 1/4"=1'-0"