


REFER TO DRAWING C01 FOR GENERAL CONSTRUCTION NOTES

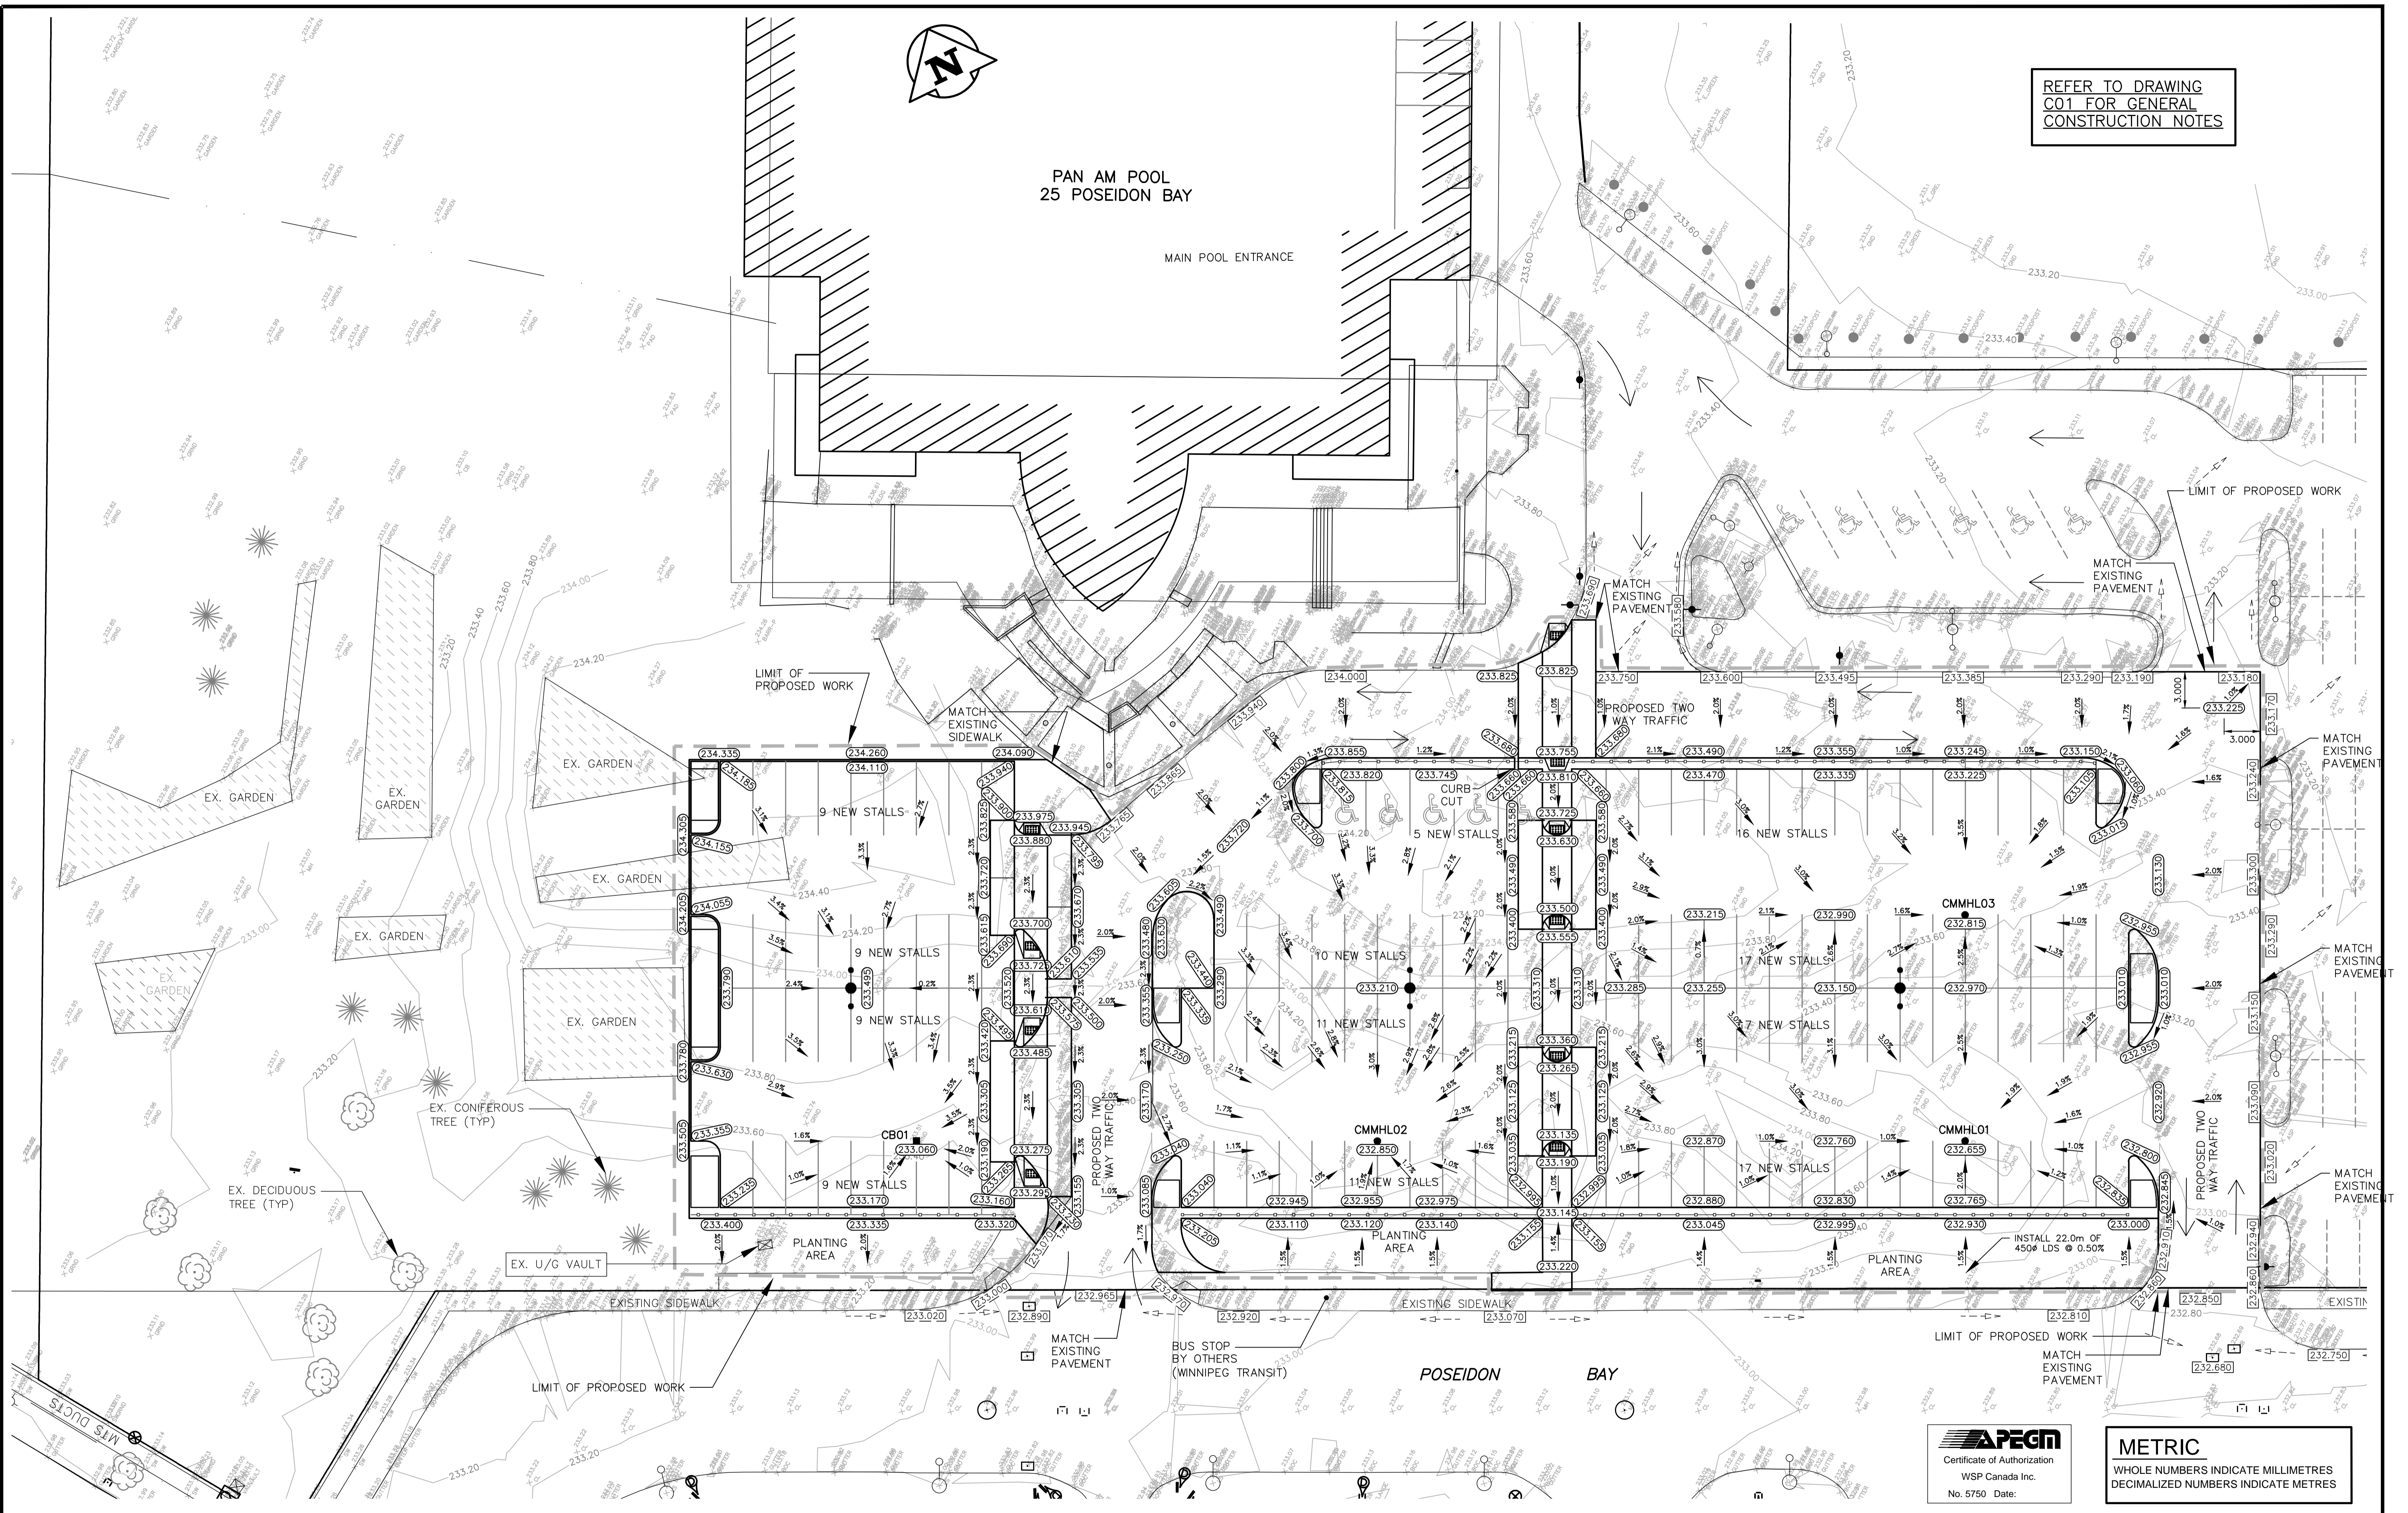

150 mm WM	WATERMAIN	150 mm WM	---	GAS	---
Hydrant	HYDRANT	Hydrant	---	HYDRO	---
Valve	VALVE	Valve	---	M.T.S.	---
300 mm LDS	LAND DRAINAGE SEWER	300 mm LDS	---	PEDESTAL	---
250 mm CS	WASTE WATER SEWER	250 mm CS	---	PROPERTY LINE	---
Manhole	MANHOLE	Manhole	---	SURVEY BAR	---
Catch Basin	CATCH BASIN	Catch Basin	---	CURB STOP	---
Curb Inlet	CURB INLET	Curb Inlet	---	GROUND ELEVATION	(230.000)
Sign	SIGN	Sign	---	PAVEMENT ELEVATION	(230.000)
Lamp Standard	LAMP STANDARD	Lamp Standard	---		
Utility Pole	UTILITY POLE	Utility Pole	---		
EXISTING	LEGEND - PLAN	NEW	EXISTING	LEGEND - PLAN	NEW

CENTRELINE OF SWALE	ELEVATION	(230.000)COS
CATCH BASIN ELEVATION		(230.000)CB
TESTHOLE		
TOPSOIL & SOD		
ASPHALT		
CURBING		
TREE		
CONCRETE		
PAVERS		
TACTILE WARNING STRIP		
LEGEND - PROFILE		NEW

LOCATION APPROVED UNDERGROUND STRUCTURES

W.B.M. 52-012 233.701m
N.E. CORNER OF TAYLOR AVE. AND CAMBRIDGE ST.
AT REAR OF NO. 880 CAMBRIDGE ST. FACING TAYLOR AVE.
A TABLET IN S. SIDE OF SQUARE CONCRETE VENTILATOR FOR UNDERGROUND GARAGE.

NO. REVISIONS

DATE

BY

WSP

1600 BUFFALO PLACE
WINNIPEG, MB, R3T 6B8
PHONE: 204-477-6650
FAX: 204-474-2864
WWW.WSPGROUP.COM

DESIGNED BY: B.J.

CHECKED BY: B.J.

DRAWN BY: G.P.

APPROVED BY: B.J.

HOR. SCALE: 1:250 (A1)

RELEASED FOR CONSTRUCTION

VERT. SCALE:

DATE: APRIL 2015

DATE:

ENGINEER'S SEAL

ORIGINAL DRAWING SEALED

by G.B. JONSON and DATED May 27, 2015

CONSULTANT DRAWING NO. 121-24877-C03

THE CITY OF WINNIPEG
PLANNING, PROPERTY & DEVELOPMENT

PAN AM INDOOR POOL
PARKING LOT REDEVELOPMENT-PHASE 1
SITE GRADING PLAN

CITY DRAWING NO. 432-2015-C03

SHEET 3 OF 9

REV. C03