


LEGEND	
	EXISTING FACILITY
	NEW FACILITY/EXTENSION
	FUTURE FACILITY
	ENTRANCE/FIRE ROUTE
	MAIN ENTRANCE EXST ROAD
	EXST OPEN TO AIR TANK
	FIRE HYDRANT
	IMAGINARY LINE (LIMITING DISTANCE)

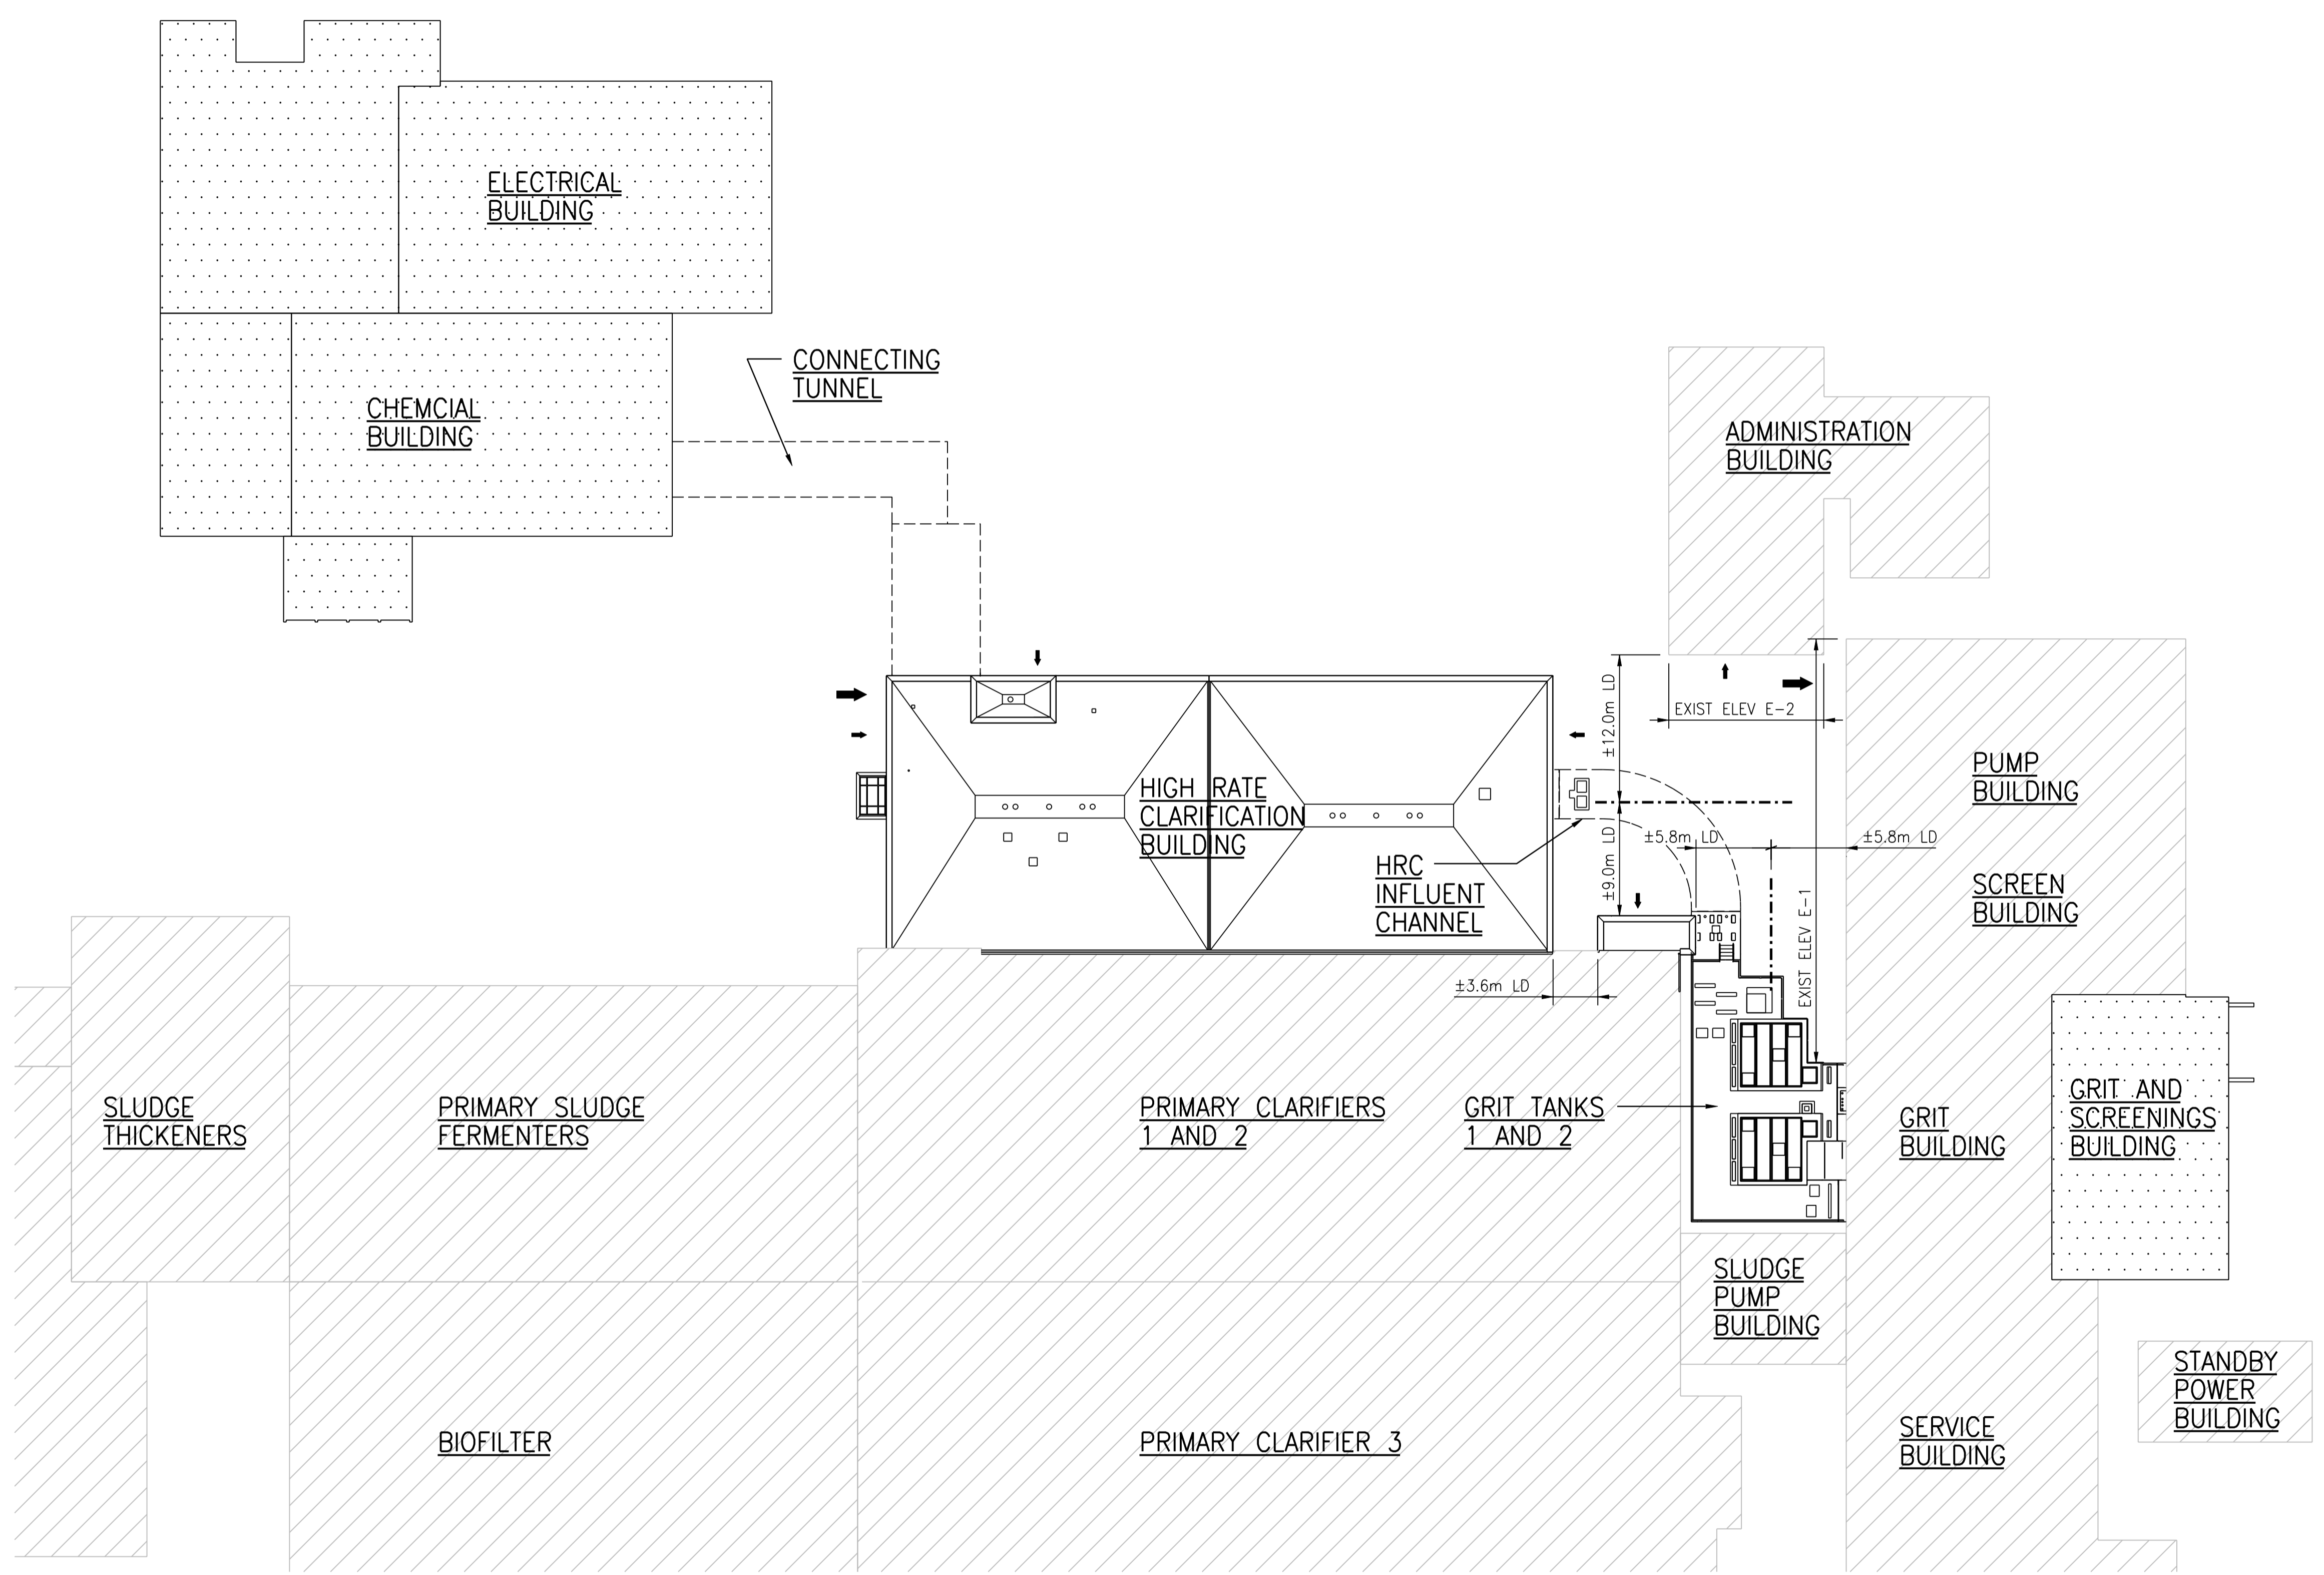


OVERALL SITE PLAN
1:300



NO.	REVISIONS	DATE	DESIGN	CHECK
00	ISSUED FOR TENDER	08/2015	J.L.	J.C.

CH2MHILL CANADA Architects Inc.	
DESIGNED BY: R. ZAKKO	CHECKED BY: B. KOLIS-HUPA
DRAWN BY: J. LIN	APPROVED BY: R. ZAKKO
SCALE: 1:300	ISSUED FOR CONSTRUCTION BY: T. TURZAK
DATE: 2015/08/13	DATE: 2015/08/13
CONSULTANT NO.: 474248	

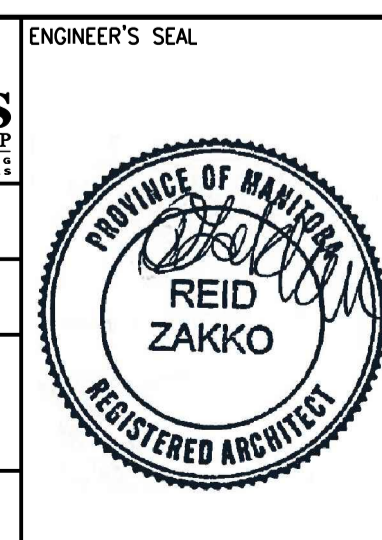

THE CITY OF WINNIPEG
 WATER AND WASTE DEPARTMENT

SOUTH END WATER POLLUTION CONTROL CENTRE
 SEWPCC UPGRADING/EXPANSION PROJECT
 BUILDING
 HRC BUILDING AND GRIT TANKS 1 AND 2
 SITE PLAN

CITY DRAWING NUMBER	SHEET	REV.	SIZE
1-0102-BLYT-A001	00	00	A1