
 


- GENERAL NOTES:**
- REFER TO DWG. 1-0102-ECTR-K002 001 FOR GENERAL NOTES.
- SPECIFIC NOTES:**
- UPPER CABLE TRAY AT EL. 230.406 AND FURTHER ALONG AT EL. 232.885, DEDICATED FOR MAIN POWER FEED TO MCC-K710 AND MCC-K720. DO NOT RUN OTHER SYSTEM CABLING ON THIS TRAY.
  - PROVIDE FIRE RATED ASSEMBLY AND SEAL ALL CABLES PENETRATING THE WALL TO SEPARATE THE AREAS.

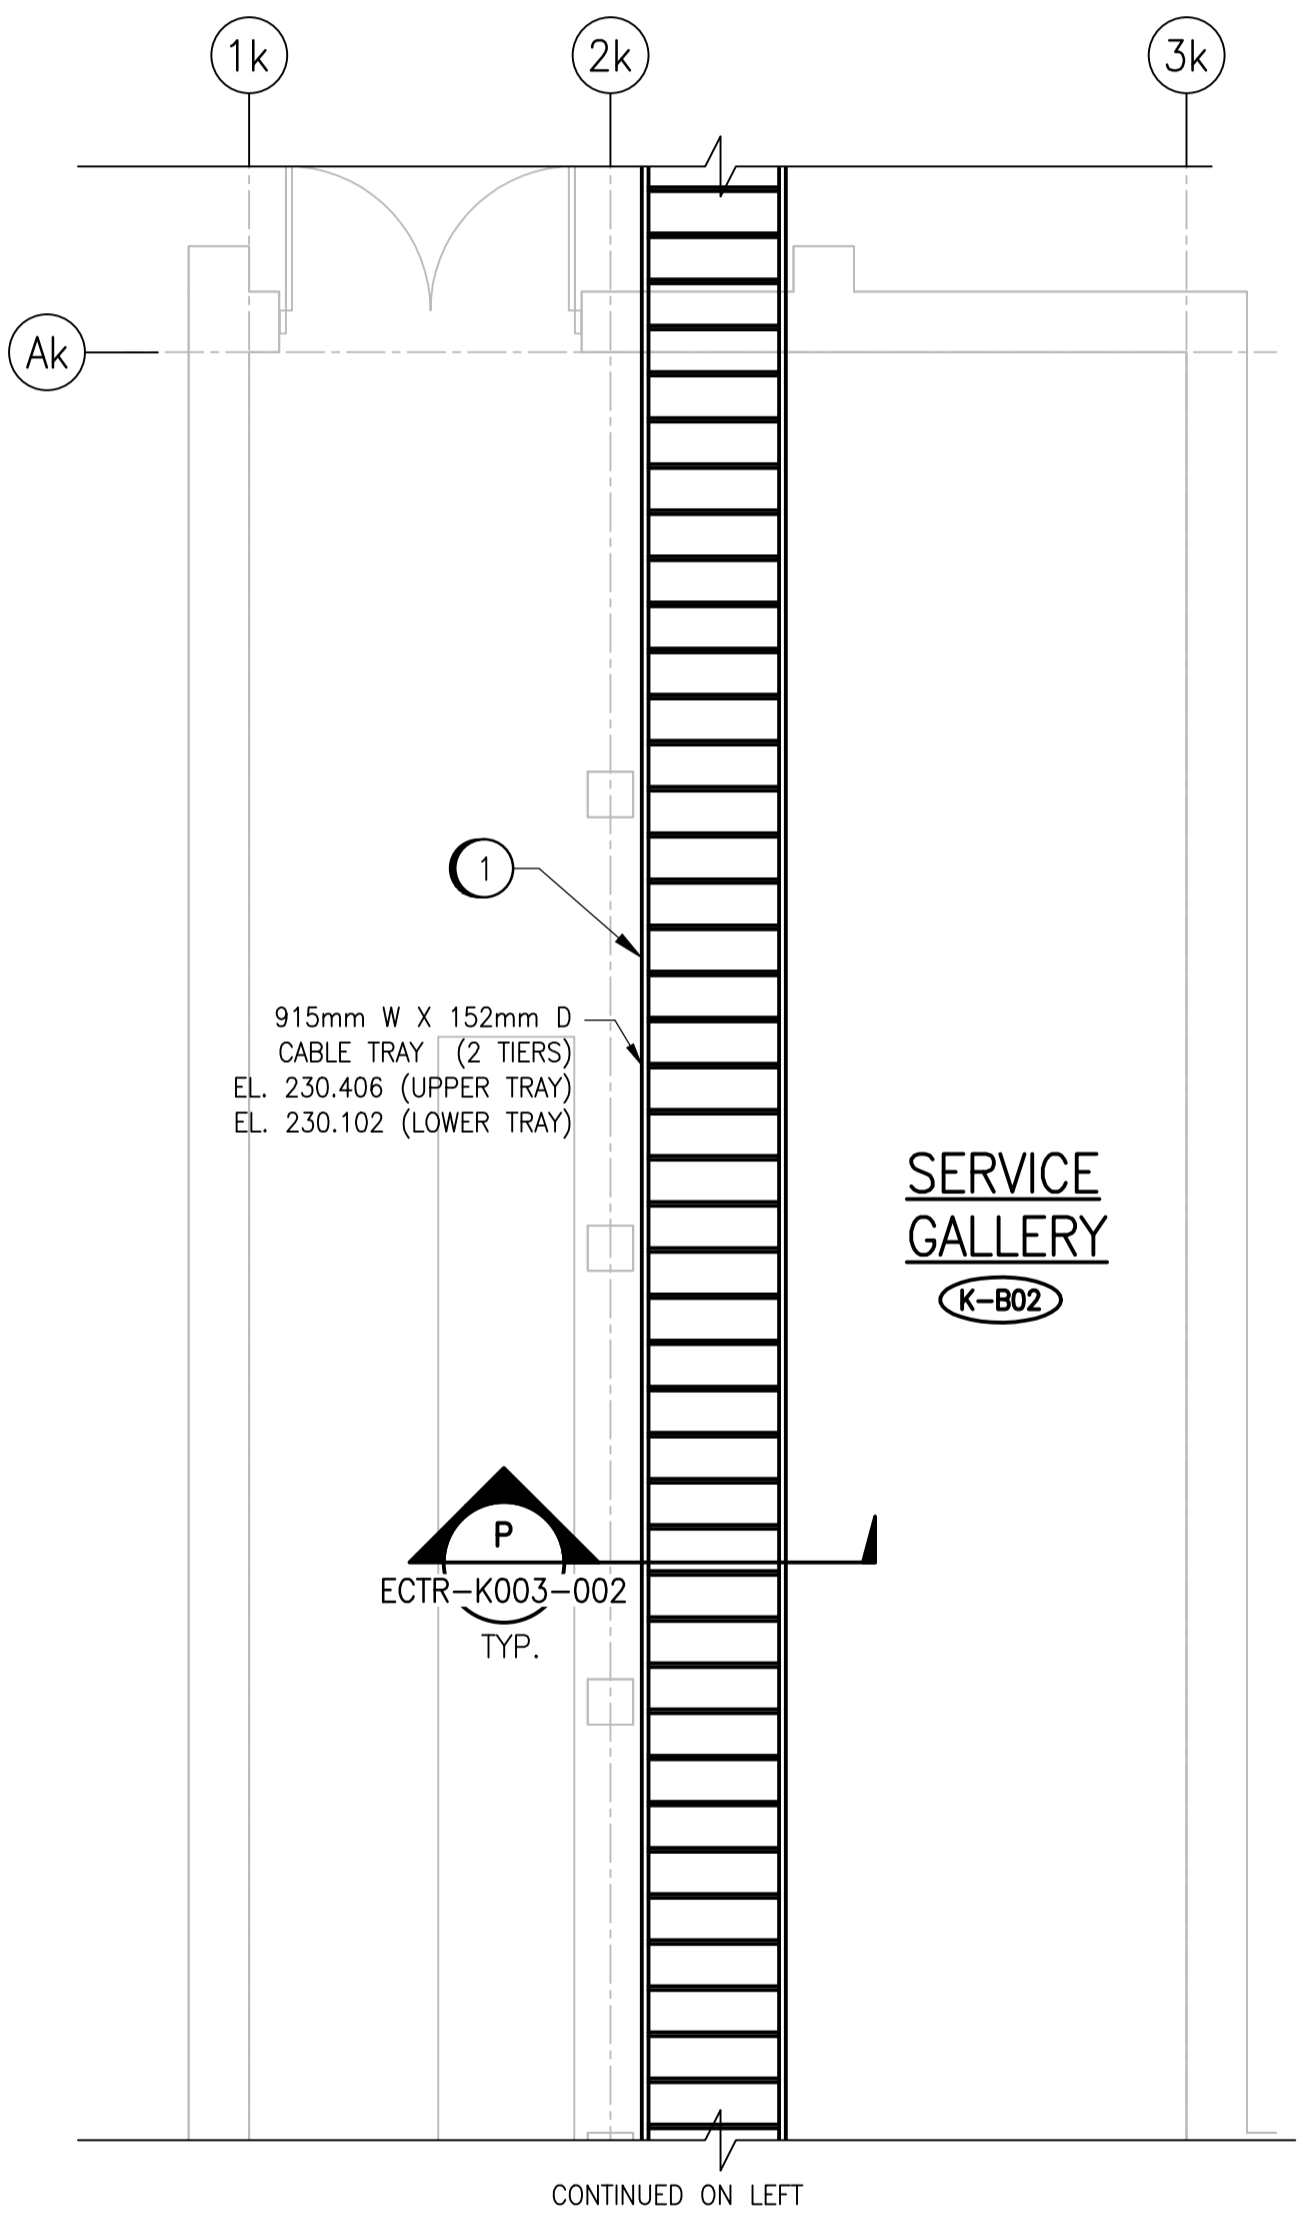

**BASEMENT FLOOR PLAN**  
 1 : 50



NO.	REVISIONS	DATE	DESIGN	CHECK
00	ISSUED FOR TENDER	08/2015	SLJ	DEB

<b>CH2MHILL.</b>	
DESIGNED BY: S. JUGANAS	CHECKED BY: D. BECKER
DRAWN BY: MJ. PERSSON	APPROVED BY: D. BECKER
SCALE: 1:50	ISSUED FOR CONSTRUCTION BY: DATE:
DATE: 2015/02/05	DATE:
CONSULTANT NO.: 474248	

ENGINEER'S SEAL  
 PRELIMINARY  
 NOT FOR CONSTRUCTION

**THE CITY OF WINNIPEG**  
 WATER AND WASTE DEPARTMENT

SOUTH END WATER POLLUTION CONTROL CENTRE  
 SEWPPC UPGRADING/EXPANSION PROJECT  
 ELECTRICAL - CABLE TRAY LAYOUT  
 HIGH RATE CLARIFICATION  
 BASEMENT FLOOR

CITY DRAWING NUMBER: 1-0102-ECTR-K001  
 SHEET: 001  
 REV: 00  
 SIZE: A1

REFERENCE DRAWINGS	DESCRIPTION
1-0102-ECTR-K003	CABLE TRAY DETAILS