


ROOM DETAILS			
ROOM ID	HEIGHT	CEILING TYPE	REF DWG
P121	14.78m	STAIRWELL - CONCRETE	SEP-054

SPECIFIC NOTES

1. PROVIDE NEW SMOKE DETECTOR FAS-P116-001 AT THE TOP OF NEW STAIRWELL. EXTEND/RE-ROUTE EXISTING WIRING AND CONDUIT AS REQUIRED.

GENERAL NOTES

1. ALL WIRING SHALL BE RUN IN RIGID, THREADED ALUMINUM CONDUIT.
2. WIRING IS TO BE EXTENDED THROUGH JUNCTION BOXES, COMPLETE WITH TERMINAL STRIPS. SPLICES OR MARRETTE CONNECTIONS ARE NOT ALLOWED.

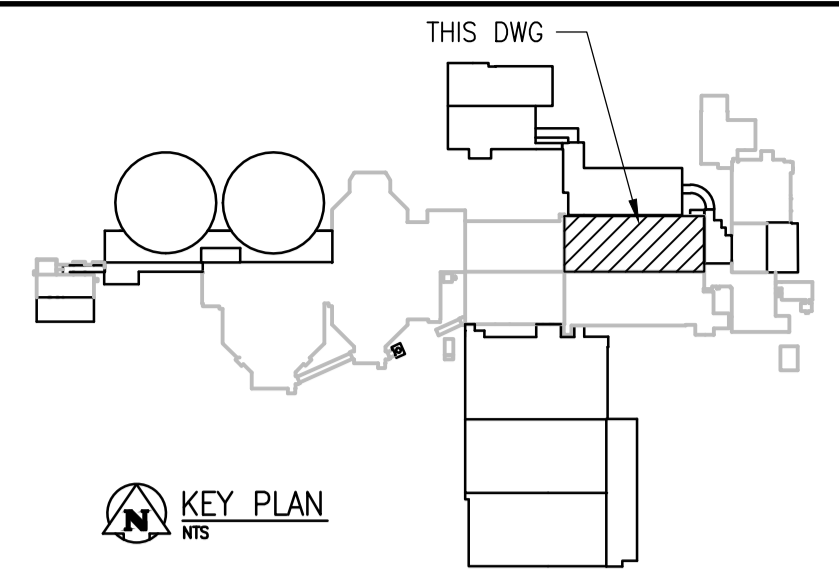

VERIFY
CONTINUED ON 1-0102-XXXX-XXXX

27mm MAIN CONDUIT. CCTS:
IDC-P1-01
IDC-P1-02
IDC-P1-03
NAC-P1-02
NAC-P1-03

21mm MAIN CONDUIT. CCTS:
2xIDC-P1-01

CONTINUED ON 1-0102P-E0003

CONTINUED ON 1-0102P-E0002

PRIMARY CLARIFIER 1 & 2
1 : 100

NOTES:

1. DEVICE TAGS ARE SHOWN IN SHORTHAND NOTATION. FULL DEVICE TAG FORMAT IS FAS-Pxxx-yyy, WHERE xxx IS THE ROOM NUMBER, AND yyy IS THE DEVICE IDENTIFIER.
2. THIS DRAWING SUPERSEDES DRAWING 1-0102P-E0001.



NO.	REVISIONS	DATE	DESIGN	CHECK
00	ISSUED FOR TENDER	08/2015	WE	DEB

CH2MHILL.
SNC-Lavalin

DESIGNED BY: V. ELIMBAN
DRAWN BY: MJ. PERSSON
SCALE: 1:100
DATE: 2015/04/14
CONSULTANT NO.: 474248

CHECKED BY: D. BECKER
APPROVED BY: D. BECKER
ISSUED FOR CONSTRUCTION BY:
DATE:

ENGINEER'S SEAL

PRELIMINARY
NOT FOR CONSTRUCTION

THE CITY OF WINNIPEG
Winnipeg WATER AND WASTE DEPARTMENT

SOUTH END WATER POLLUTION CONTROL CENTRE
SEWPCU UPGRADING/EXPANSION PROJECT
ELECTRICAL - FIRE ALARM
PRIMARY CLARIFIER
CLARIFIERS 1 & 2

CITY DRAWING NUMBER: 1-0102-EFAS-P002
SHEET: 001
REV: 00
SIZE: A1

1-0102P-E0014	ELECTRICAL CLASSIFICATION PLAN
1-0102-EFAS-A001	FIRE ALARM LEGEND AND DETAILS
DRAWING NUMBER	REFERENCE DRAWINGS