



**ROOF PLAN**  
1:50

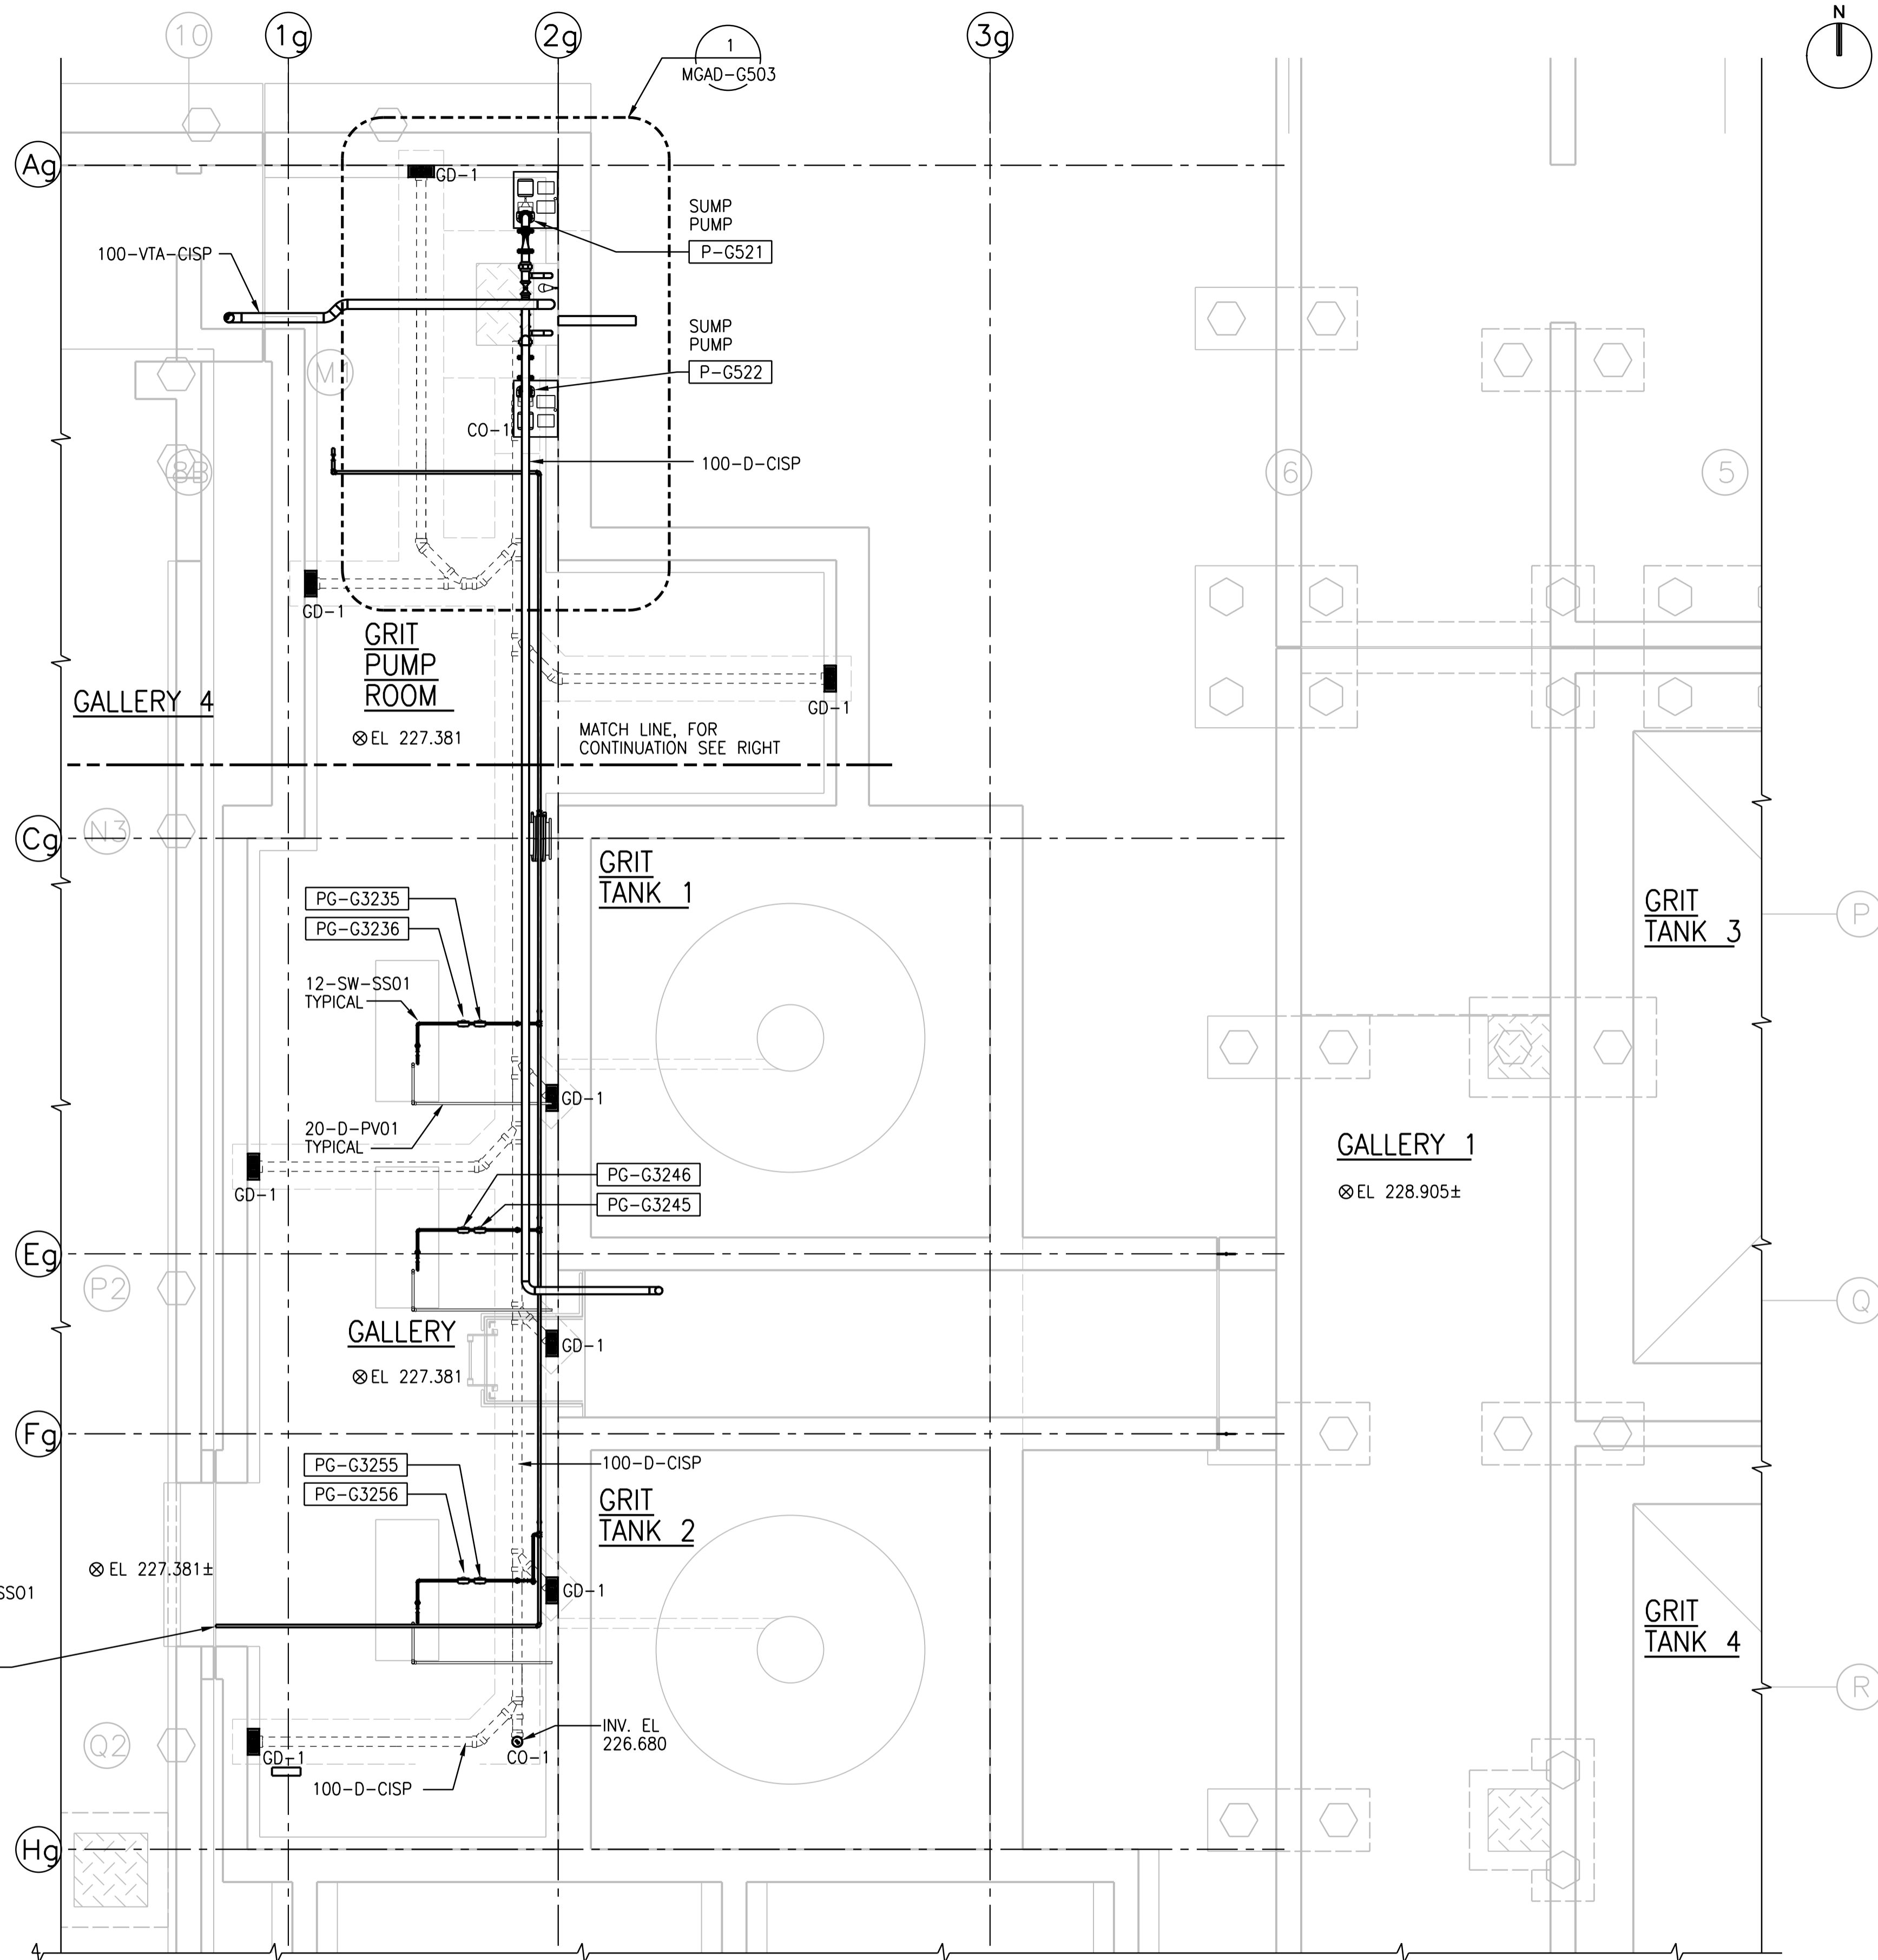

**BASEMENT PLAN**  
1:50

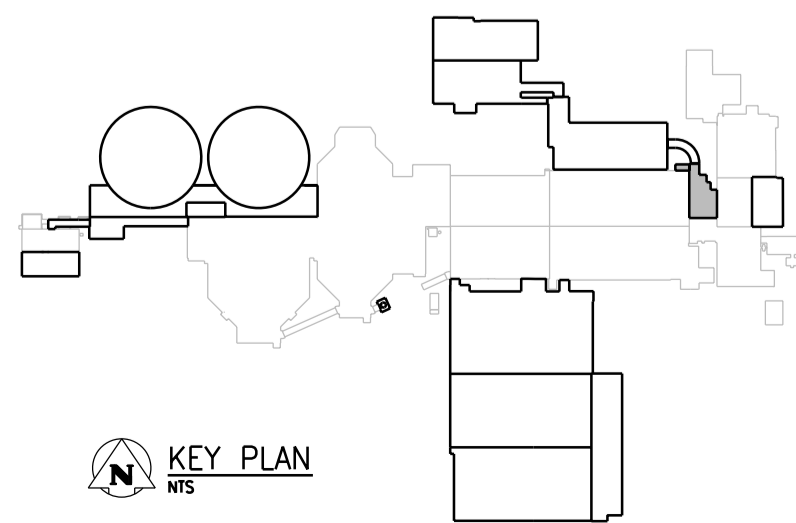

**APEGM**  
Certificate of Authorization  
CH2M HILL Canada Ltd.  
No. 1441

NO.	REVISIONS	DATE	DESIGN	CHECK
00	ISSUED FOR TENDER	08/2015	K.F.	J.C.

**CH2MHILL.**

SNC-LAVALIN

DESIGNED BY: D. LE  
DRAWN BY: S. SUN  
SCALE: 1:50  
DATE: 2015/08/13

CHECKED BY: T. TRAN  
APPROVED BY: D. LE  
ISSUED FOR CONSTRUCTION BY: T. TURZAK  
DATE: 2015/08/13

CONSULTANT NO.: 474248

ENGINEER'S SEAL

13 August 2015

PROVINCE OF MANITOBA  
REGISTERED PROFESSIONAL ENGINEER

D.H. LE  
Member  
31604

THE CITY OF WINNIPEG  
Winnipeg WATER AND WASTE DEPARTMENT

SOUTH END WATER POLLUTION CONTROL CENTRE  
SEWPCC UPGRADING/EXPANSION PROJECT  
MECHANICAL  
GRIT TANKS 1 AND 2  
PLUMBING - BASEMENT PLAN AND ROOF PLAN

CITY DRAWING NUMBER: 1-0102-MGAD-G501

SHEET: 00  
REV: 00  
SIZE: A1