 



### GROUND FLOOR PLAN

1:100



- NOTES:
- ALL DRAINS ARE 100 DIAMETER AND ARE INSTALLED AT 1% SLOPE UNLESS NOTED OTHERWISE.
  - REFER TO DRAWING NUMBER 1-0102-MISO-K501 THRU 1-0102-MISO-K504 FOR PLUMBING ISOMETRICS.

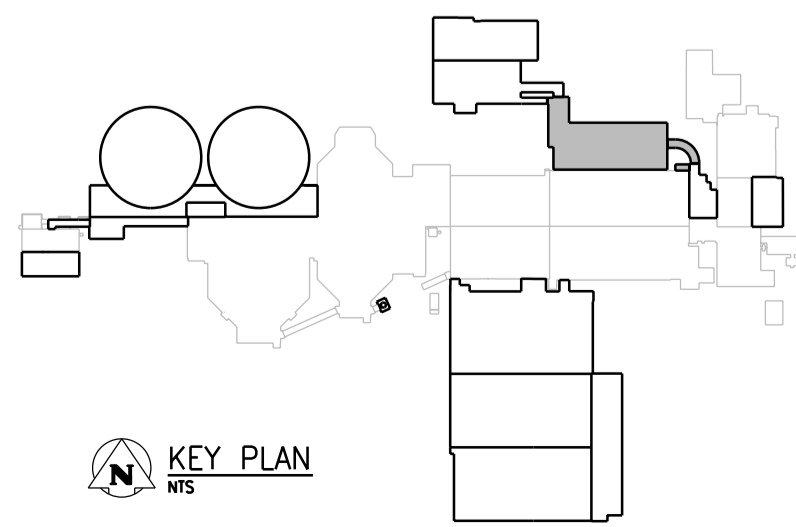


00	ISSUED FOR TENDER	08/2015	S.S. J.C.
NO.	REVISIONS	DATE	DESIGN CHECK

**CH2MHILL.**

SNC-LAVALIN

DESIGNED BY: T. TRAN  
 CHECKED BY: D. LE  
 DRAWN BY: R. ARCHER  
 APPROVED BY: T. TRAN  
 SCALE: 1:100  
 ISSUED FOR CONSTRUCTION BY: T. TURZAK  
 DATE: 2015/08/13  
 DATE: 2015/08/13  
 CONSULTANT NO.: 474248

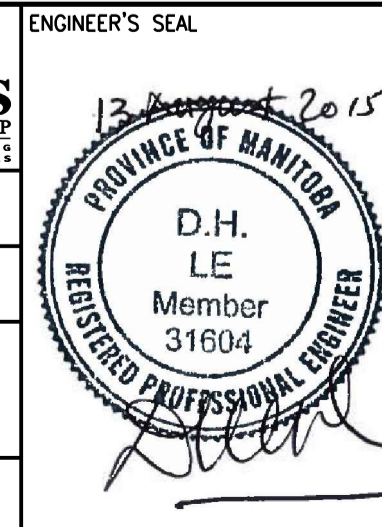

ENGINEER'S SEAL

**THE CITY OF WINNIPEG**  
 WATER AND WASTE DEPARTMENT

SOUTH END WATER POLLUTION CONTROL CENTRE  
 SEWPPCC UPGRADING/EXPANSION PROJECT  
 MECHANICAL  
 HIGH RATE CLARIFICATION BUILDING  
 PLUMBING - GROUND FLOOR PLAN

CITY DRAWING NUMBER: 1-0102-MGAD-K502  
 SHEET: 00  
 REV: A1  
 SIZE: A1