


PRIMARY CLARIFIER TANK 1

**ROOF PLAN**  
1:100



- NOTES:
- ALL RAIN WATER LEADERS ARE 150 DIAMETER, UNLESS NOTED OTHERWISE.  
ALL RAIN WATER LEADERS ARE INSTALLED AT 1% SLOPE.
  - REFER TO DRAWING NUMBER 1-0102-MISO-K501 THRU 1-0102-MISO-K504 FOR PLUMBING ISOMETRICS.

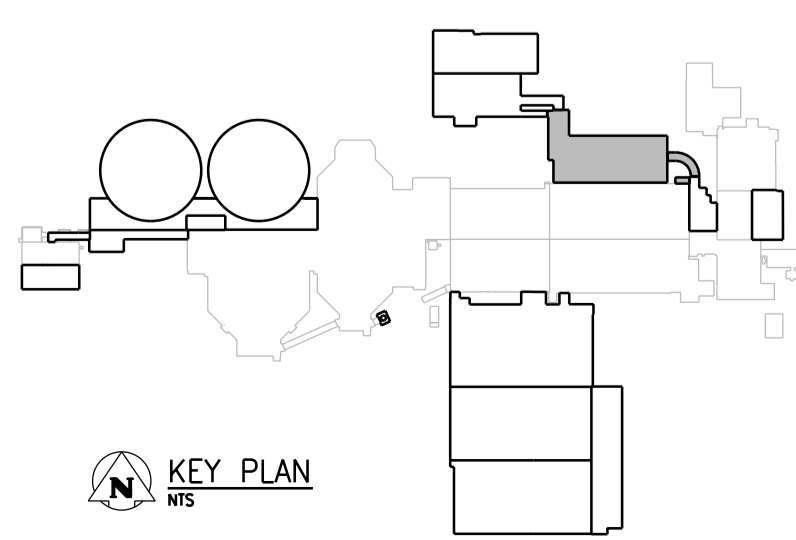

		DESIGNED BY: T. TRAN	CHECKED BY: D. LE		SOUTH END WATER POLLUTION CONTROL CENTRE SEWPC UPGRADING/EXPANSION PROJECT MECHANICAL HIGH RATE CLARIFICATION BUILDING PLUMBING - ROOF PLAN	
DRAWN BY: R. ARCHER		APPROVED BY: T. TRAN		ISSUED FOR CONSTRUCTION BY: T. TURZAK DATE: 2015/08/13		CITY DRAWING NUMBER 1-0102-MGAD-K503
SCALE: 1:100		DATE: 2015/08/13		SHEET REV. SIZE 00 00 A1		
00 ISSUED FOR TENDER		08/2015 S.S. J.C.		CONSULTANT NO.: 474248		FILE NAME: 1-0102-MGAD-K503.dgn