


ADDRESS: 1950 PACIFIC AVENUE WEST PROJECT No: 2015-NNN SHEET TITLE: ELECTRICAL SITE LIGHTING PLAN - DEMOLITION DATE: 2015.07.03 FILE NAME: 15-0107-010\_E01.dwg

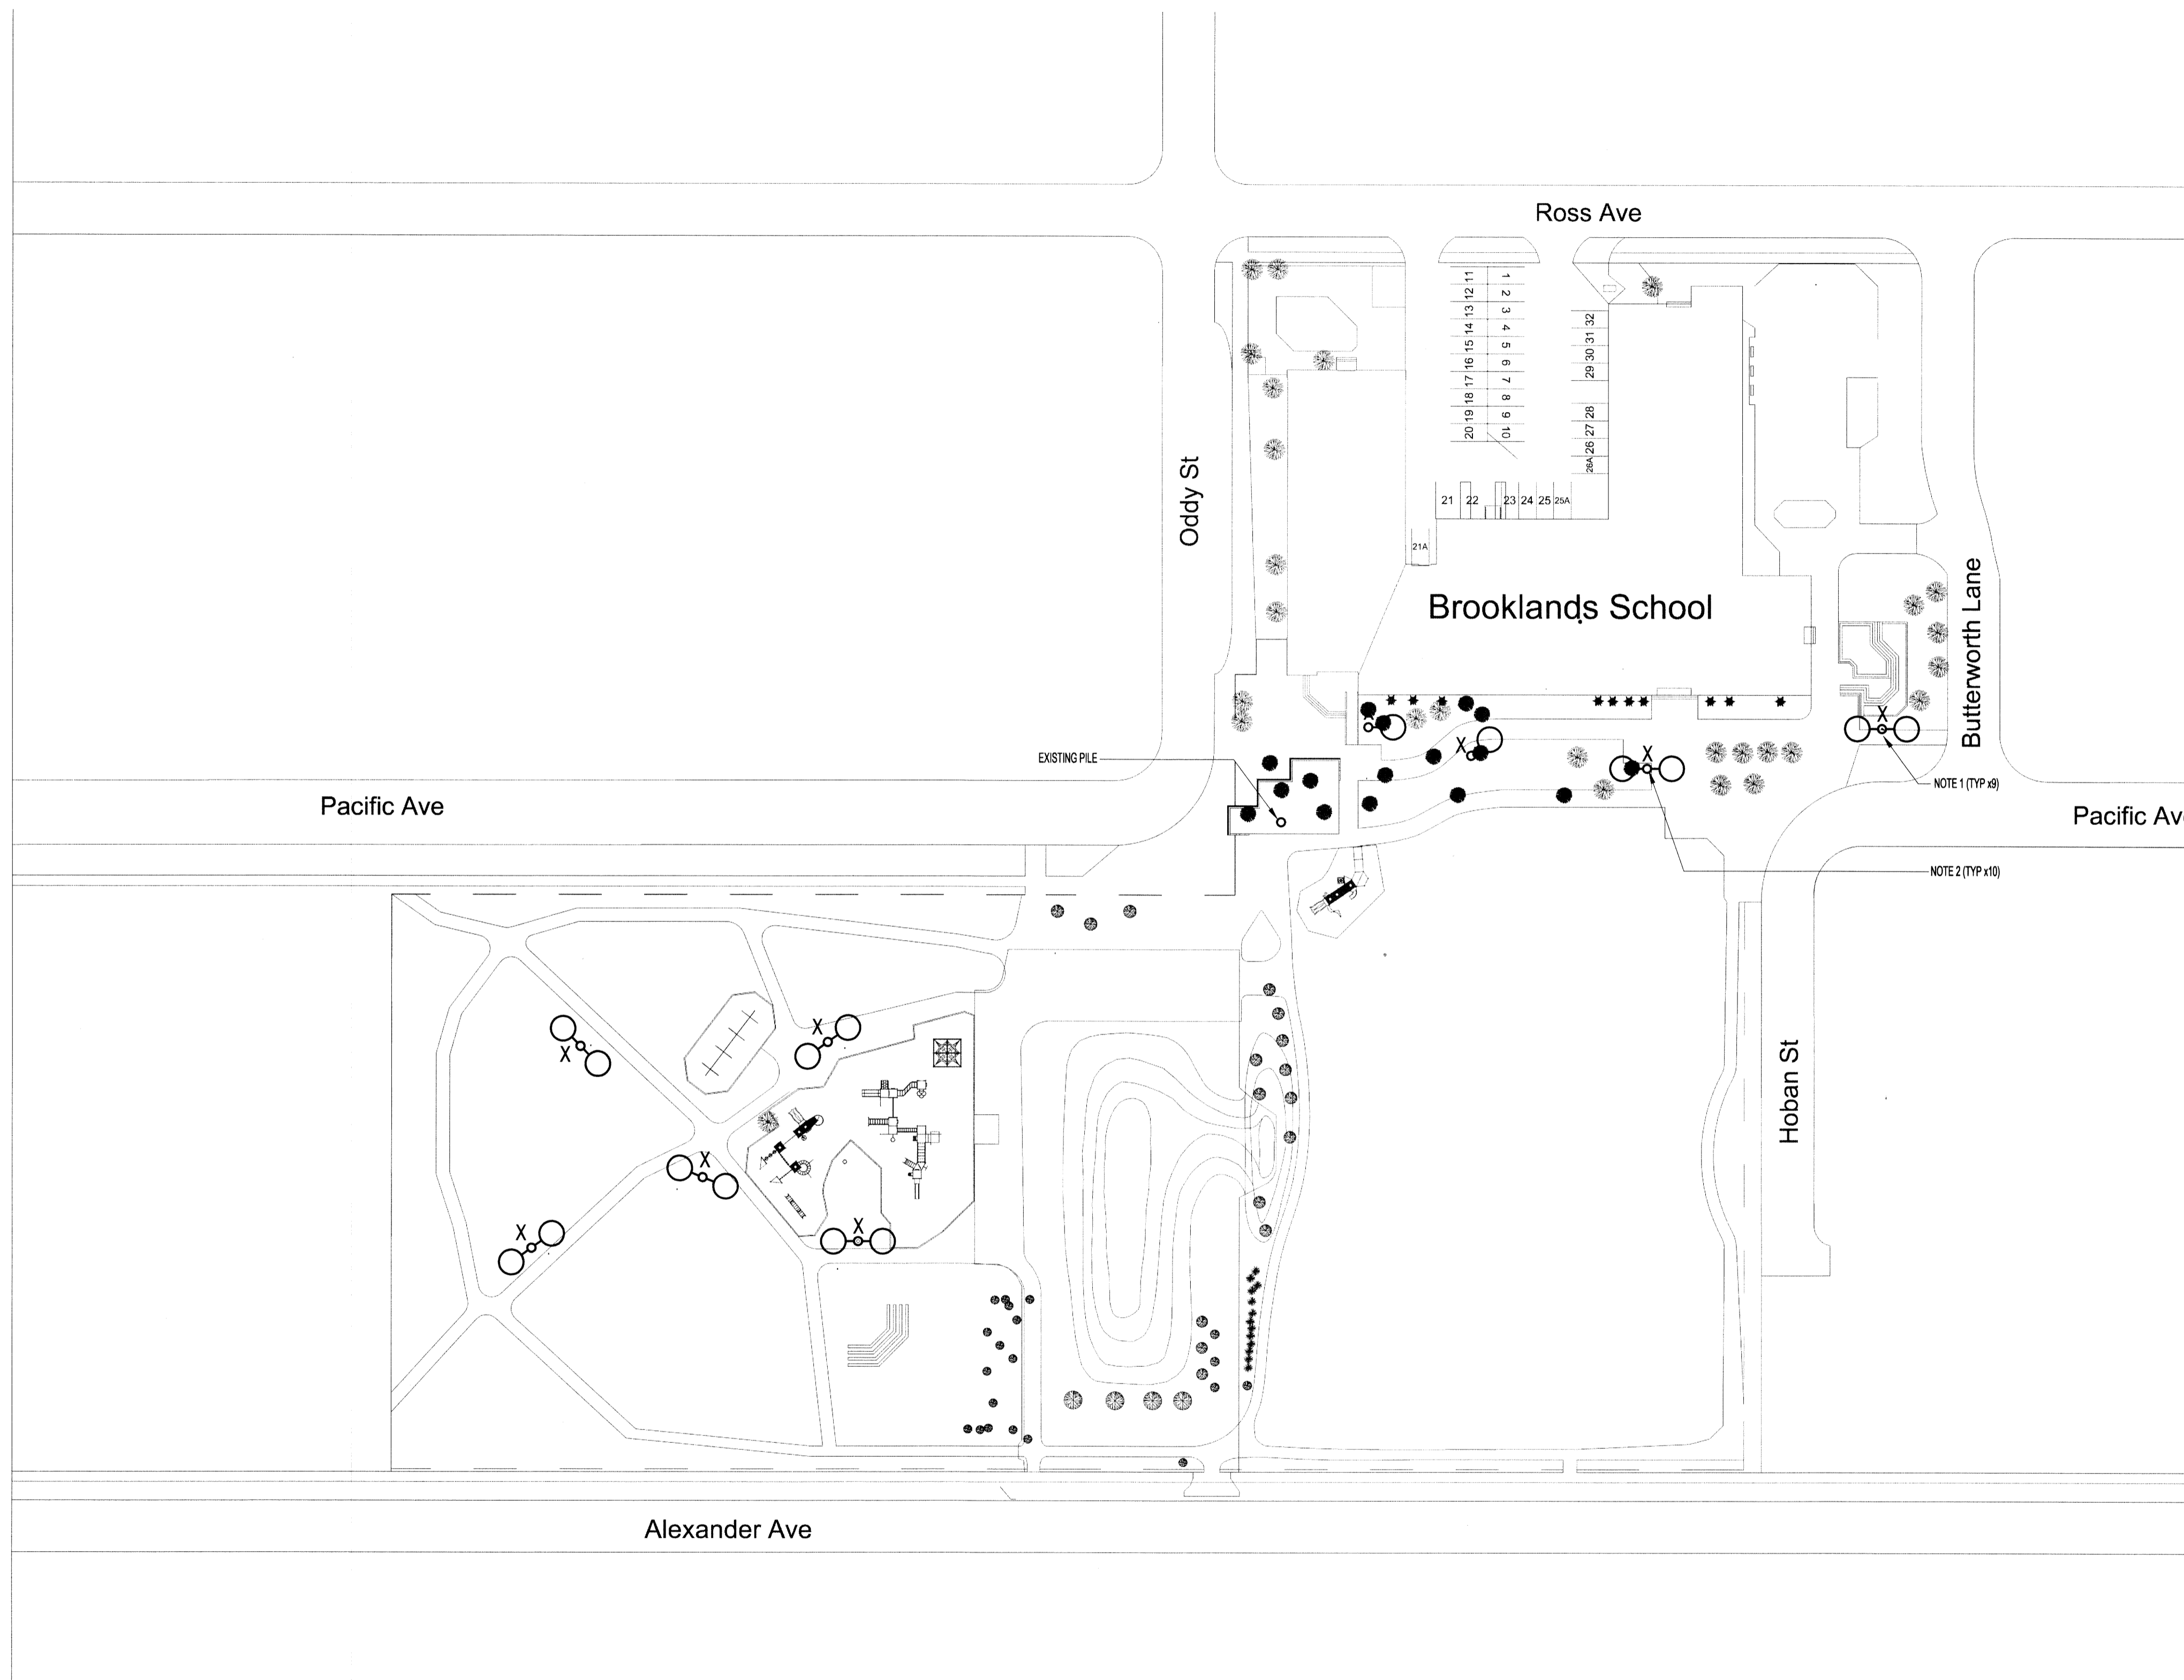

**ELECTRICAL NOTES:**

- DISCONNECT, REMOVE AND LEGALLY DISPOSE OF THE EXISTING POLES AND LUMINAIRES.
- CONTRACTOR SHALL DISCONNECT AND REMOVE EXISTING WIRING AND CONDUIT FOR THE EXTERIOR POLES WHERE ACCESSIBLE BACK TO SOURCE.

**NOTES:**


THESE DRAWINGS SHALL NOT BE SCALED.  
 THE CONTRACTOR SHALL VISIT THE SITE AND SATISFY ONESELF ALL DIMENSIONS, DATUM, AND DETAILED INFORMATION SHOWN ARE CORRECT.  
 ALL PRODUCTS AND MATERIALS TO BE USED AND INSTALLED SHALL CONFORM WITH MANUFACTURER'S SPECIFICATIONS & APPLICABLE CODES.

**LEGEND:**

- POLE MOUNTED LIGHT FIXTURE
- POLE MOUNTED LIGHT FIXTURE WITH TWO HEADS

**RENOVATION LEGEND:**

- X EXISTING ELECTRICAL EQUIPMENT SHALL BE LEGALLY DISPOSED OF OFF-SITE.

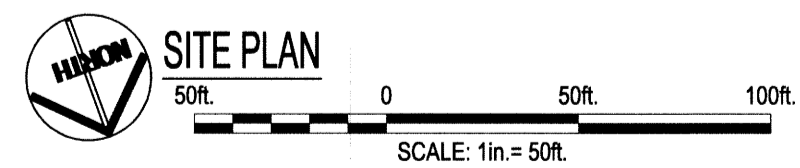

0	ISSUED FOR CONSTRUCTION	U	15.09.25
No.	REVISION/DESCRIPTION	BY	DATE

SEAL

SEPTEMBER 25, 2015

DRAWN	CHECKED	DESIGNED	APPROVED
GCN		CLS	
DATE	2015.07.03	USER	APPROVAL

Winnipeg THE CITY OF WINNIPEG  
 PLANNING, PROPERTY AND  
 DEVELOPMENT DEPARTMENT  
 MUNICIPAL ACCOMMODATIONS DIVISION  
 3-65 GARRY STREET, R3C 4K4

PROJECT  
**BROOKLANDS SCHOOL**  
 SITE LIGHTING UPGRADE

1950 PACIFIC AVENUE WEST

SHEET TITLE  
**ELECTRICAL**  
 SITE LIGHTING PLAN - DEMOLITION

SCALE	PROJECT No:	SHEET No:
N.T.S.	2015-701	E1

