
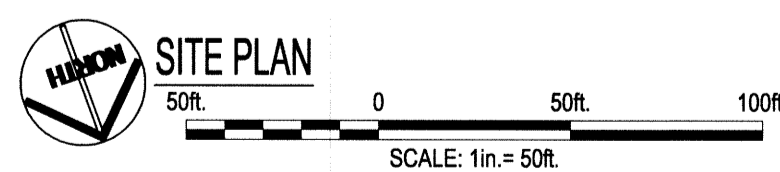


ADDRESS: 1950 PACIFIC AVENUE WEST PROJECT No: 2015-NNN SHEET TITLE: ELECTRICAL SITE LIGHTING PLAN - NEW DATE: 2015.07.03 FILE NAME: 15-0107-010_E02.dwg

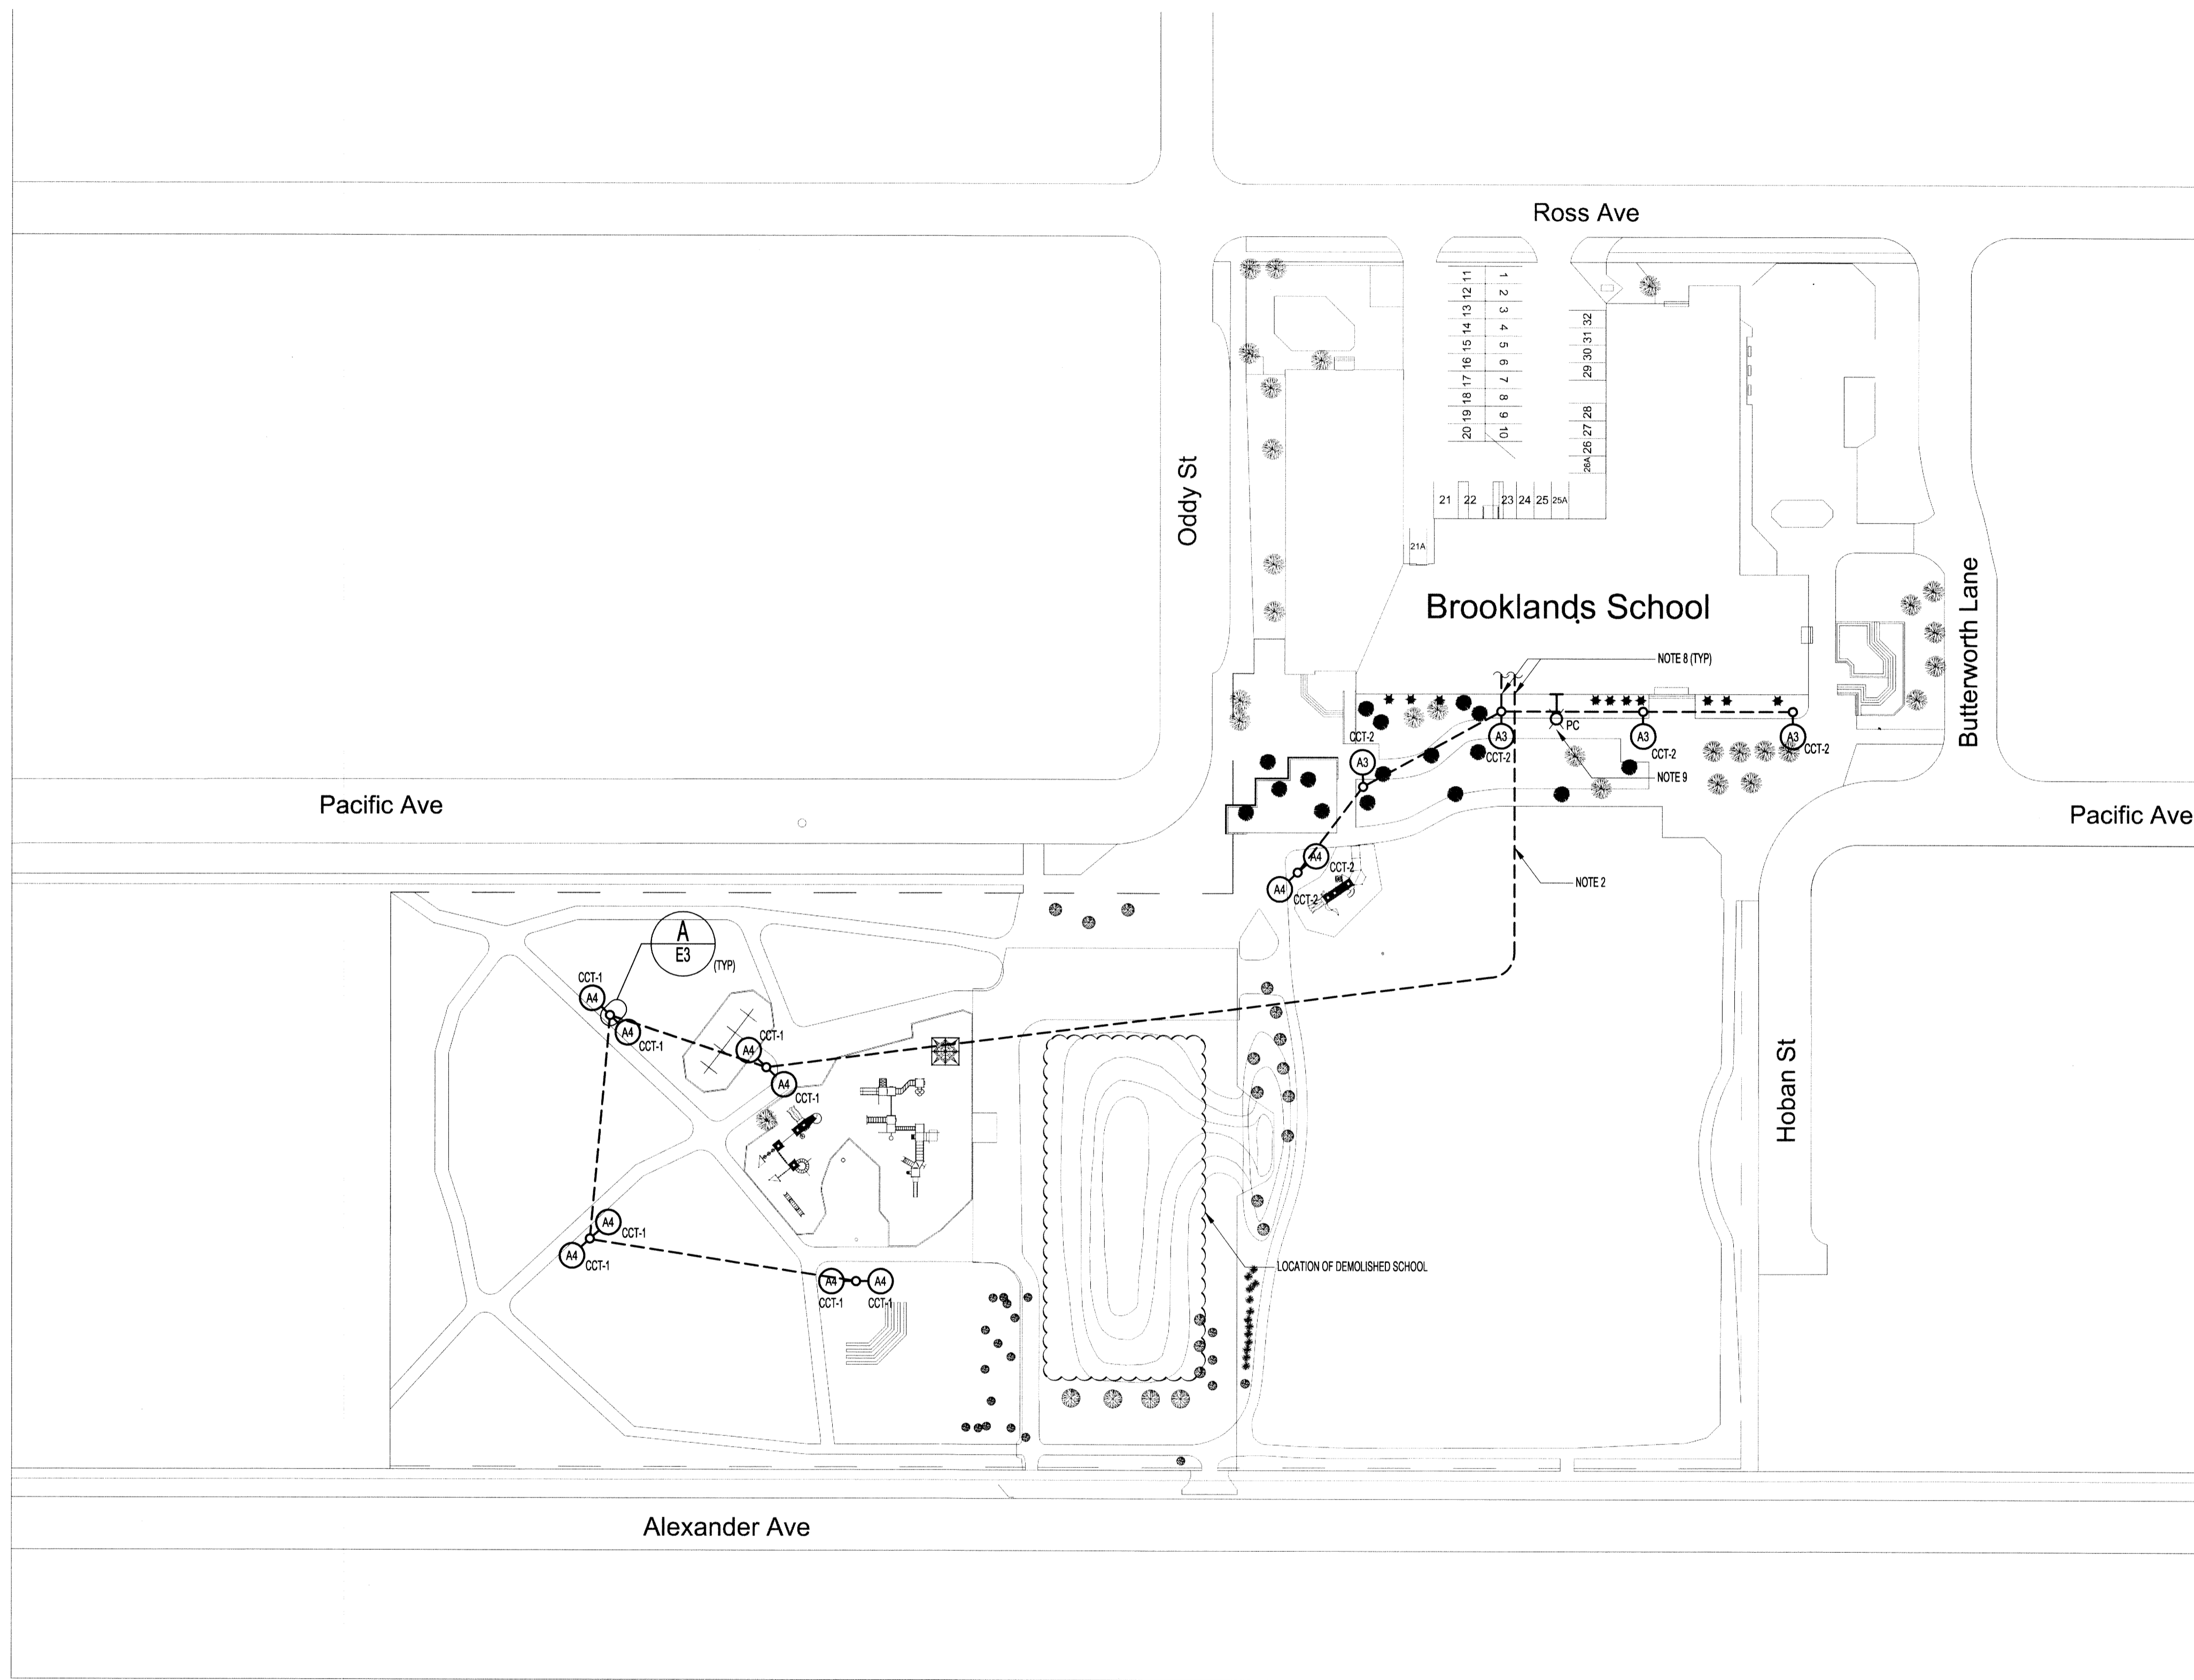


ELECTRICAL NOTES:

- GREY SHADED LINE WEIGHT DENOTES EXISTING.
- THE CONTRACTOR SHALL PUSH NEW FEEDERS IN HDPE CONDUIT FROM THE BROOKLANDS SCHOOL CRAWLSPACE TO THE POLES AS SHOWN. POWER FEEDERS SHALL BE 3/4" NMU 60. REMOVE ABANDONED CONDUCTORS AS REQUIRED. PROVIDE POWER FOR CIRCUITS CCT-1 AND CCT-2 FROM THE BOILER ROOM ELECTRICAL PANELBOARD. (REFER TO PHOTO ON DRAWING E3). PROVIDE TWO (2) NEW 120V, 1P, 15A BREAKERS TO SLIT THE EXISTING PANELBOARD. RUN NEW WIRING IN CONDUIT THROUGH THE SCHOOL'S CRAWLSPACE.
- PROVIDE NINE (9) NEW POLES COMPLETE WITH FIXTURES AND WIRING. MOUNT THE NEW POLES ON THE NEW PILES, CENTERED, PLUMBED AND TRUE. REFER TO STRUCTURAL DRAWINGS AND MANUFACTURER INSTRUCTIONS FOR MOUNTING DETAILS.
- CONTRACTOR TO CONFIRM THE LOCATIONS OF ALL UNDERGROUND UTILITIES AND SERVICES PRIOR TO PROCEEDING WITH THE NEW INSTALLATION.
- CONTRACTOR TO PROVIDE LOCATES AND SOFT EXCAVATIONS AS REQUIRED.
- THE CONTRACTOR SHALL PATCH AND RESTORE ANY DAMAGE CAUSED BY THIS SCOPE OF WORK.
- CONDUIT ROUTES ARE DIAGRAMMATIC ONLY. EXACT CONDUIT ROUTES WILL BE DETERMINED BY THE UNDERGROUND SERVICES AND OTHER EXISTING CONDITIONS.
- CONTRACTOR TO CORE AND PATCH THE CRAWLSPACE CONCRETE/BLOCK WALL AS REQUIRED.
- PROVIDE A NEW TORK MECHANICAL TIME CLOCK AND PHOTOCELL TO CONTROL THE NEW EXTERIOR LIGHTING. MOUNT THE NEW TIME CLOCK NEXT TO THE BOILER DISTRIBUTION PANEL.
- PATCH AND SEAL ALL BUILDING PENETRATIONS.

NOTES:

THESE DRAWINGS SHALL NOT BE SCALED.
 THE CONTRACTOR SHALL VISIT THE SITE AND SATISFY ONESELF ALL DIMENSIONS, DATUM, AND DETAILED INFORMATION SHOWN ARE CORRECT.
 ALL PRODUCTS AND MATERIALS TO BE USED AND INSTALLED SHALL CONFORM WITH MANUFACTURER'S SPECIFICATIONS & APPLICABLE CODES.

LEGEND:

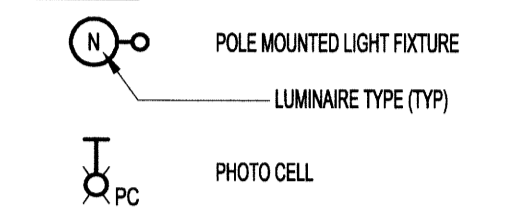

0	ISSUED FOR CONSTRUCTION		15.09.25
No.	REVISION/DESCRIPTION	BY	DATE

SEAL

SEPTEMBER 25, 2015

DRAWN	GON	CHECKED	DESIGNED	CLS	APPROVED
DATE	2015.07.03	USER	APPROVAL		

Winnipeg THE CITY OF WINNIPEG
 PLANNING, PROPERTY AND
 DEVELOPMENT DEPARTMENT
 MUNICIPAL ACCOMMODATIONS DIVISION
 3-65 GARRY STREET, R3C 4K4

PROJECT
 BROOKLANDS SCHOOL
 SITE LIGHTING UPGRADE

1950 PACIFIC AVENUE WEST
 SHEET TITLE

ELECTRICAL
 SITE LIGHTING PLAN - NEW

SCALE	PROJECT No:	SHEET No:
N.T.S.	2015-701	E2

