



ADDRESS: 481 PORTAGE AVENUE PROJECT No: 2013-127-01 SHEET TITLE: PARTIAL MAIN FLOOR PLAN - DEMO - POWER, DATA & COMM. DATE: 2015.04.15 FILE NAME: 2013127VME1.dwg

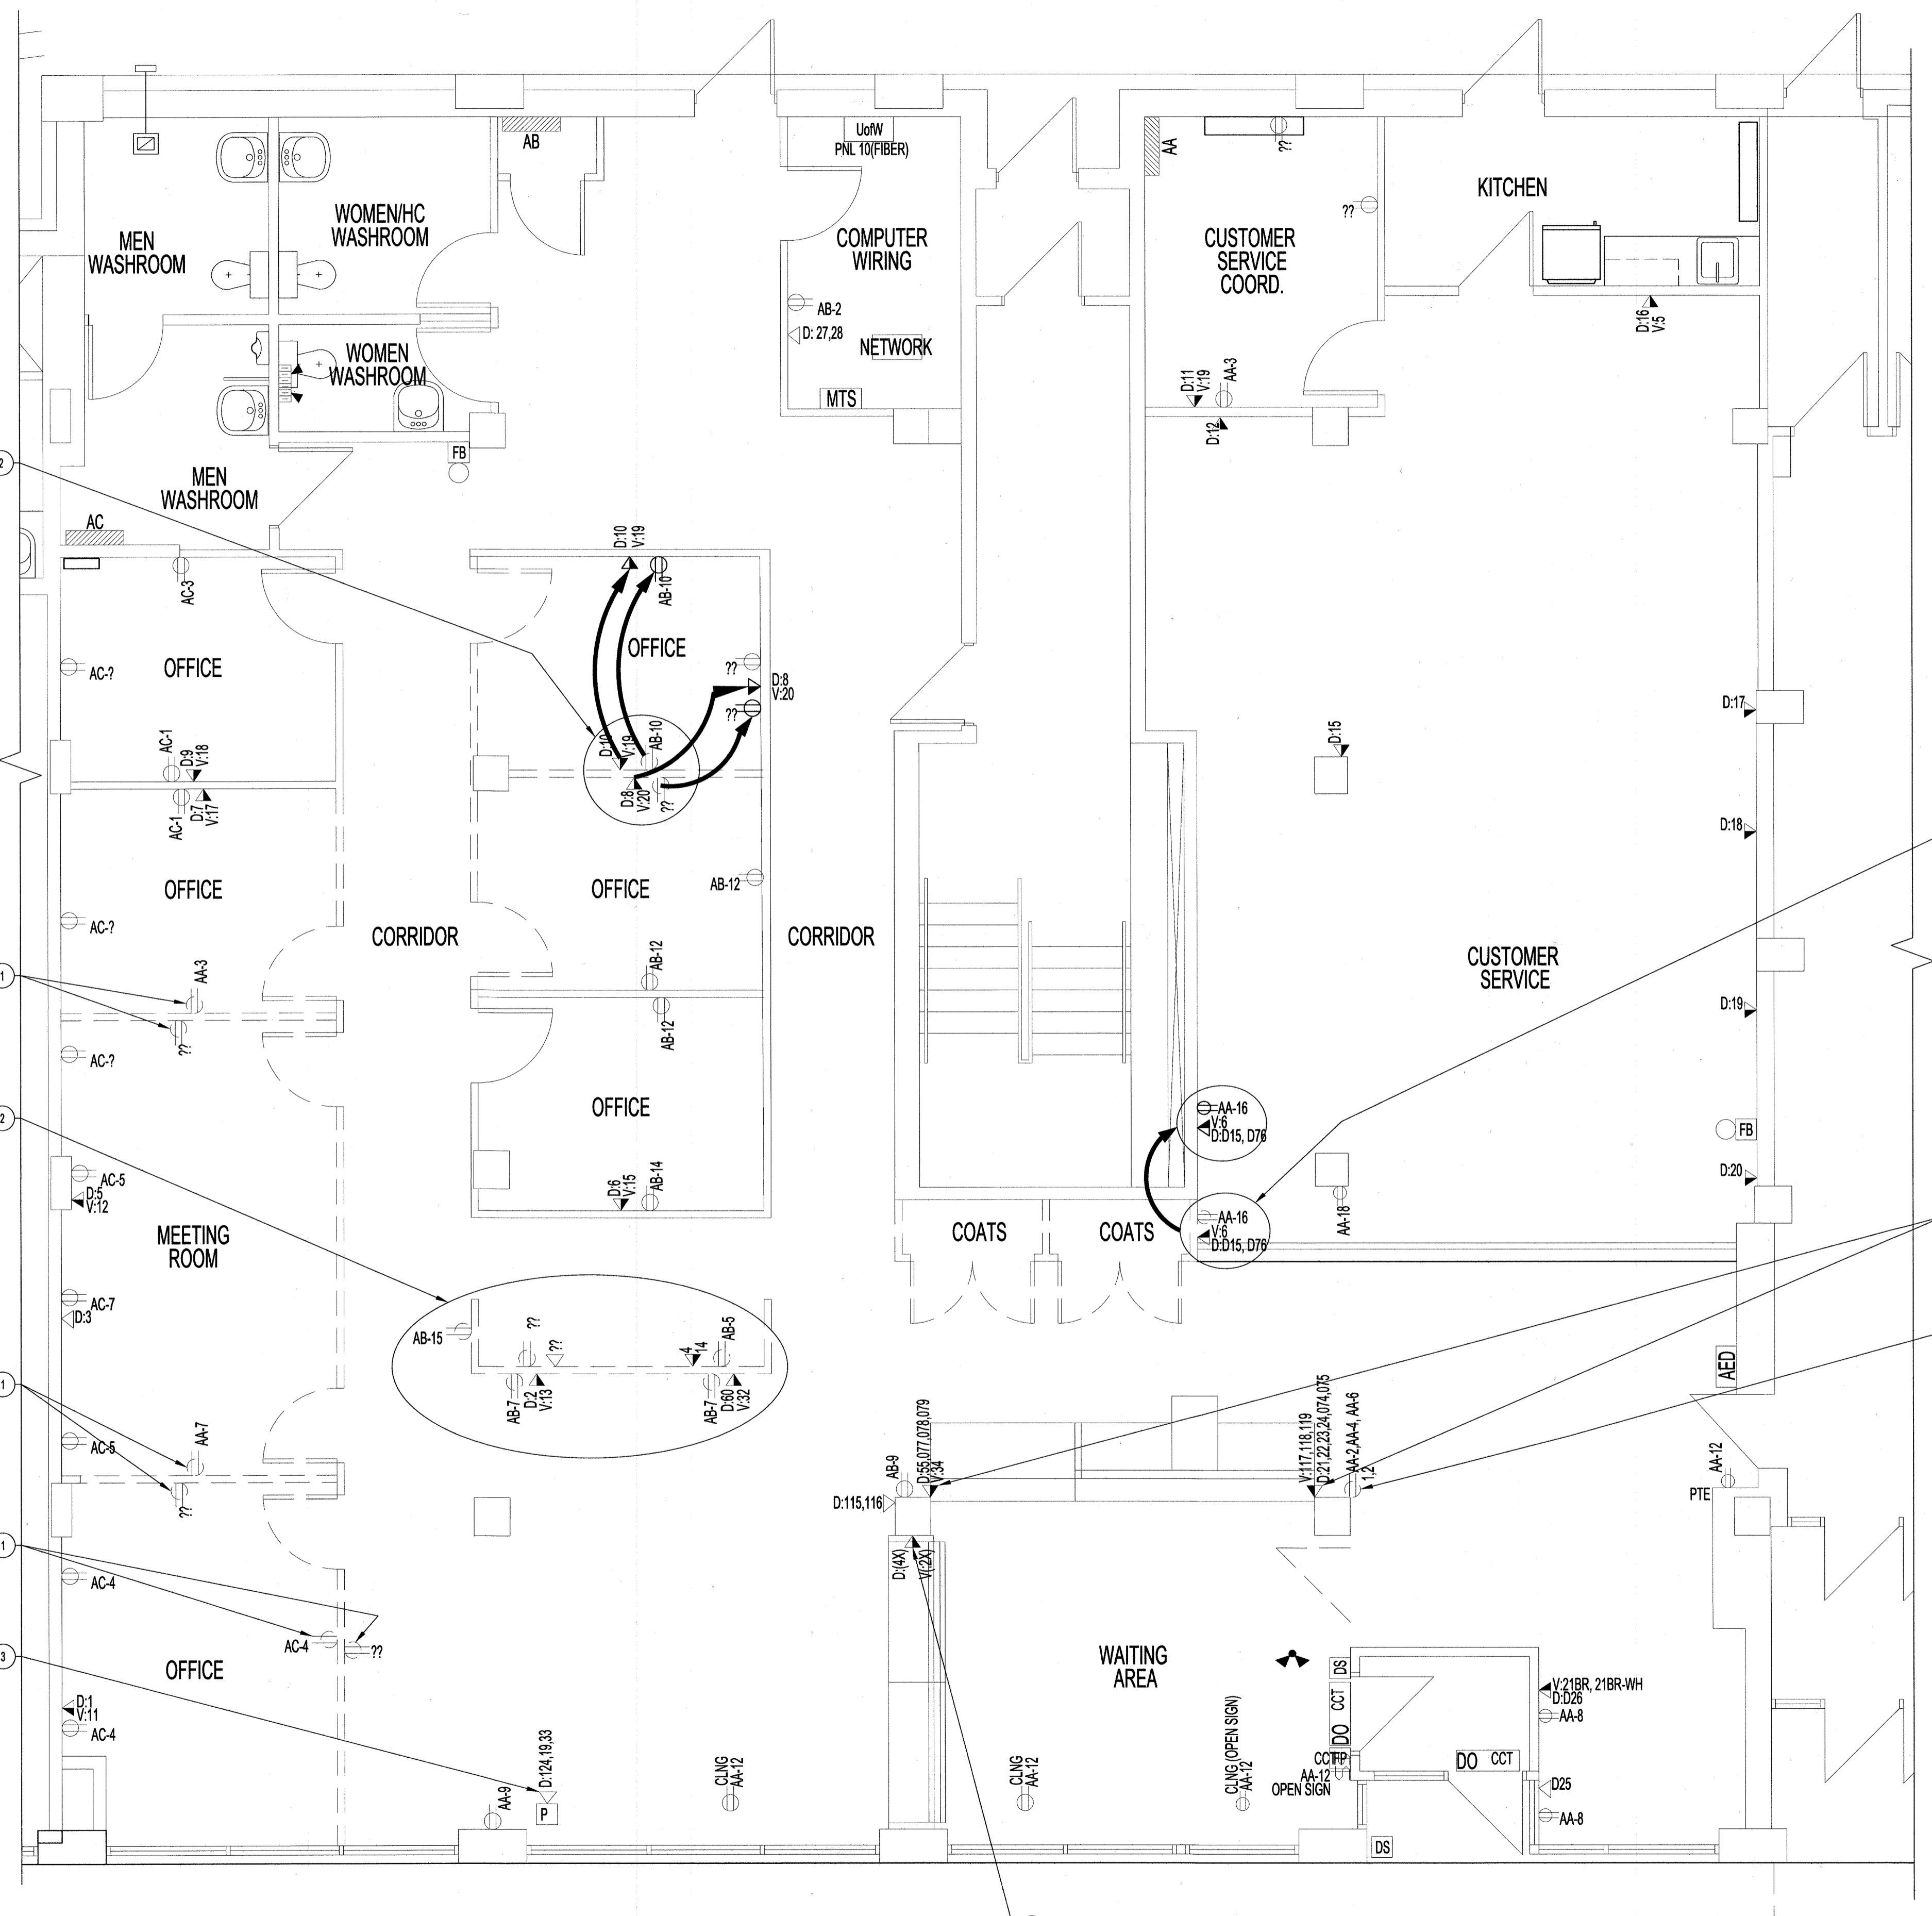

AREA OF WORK

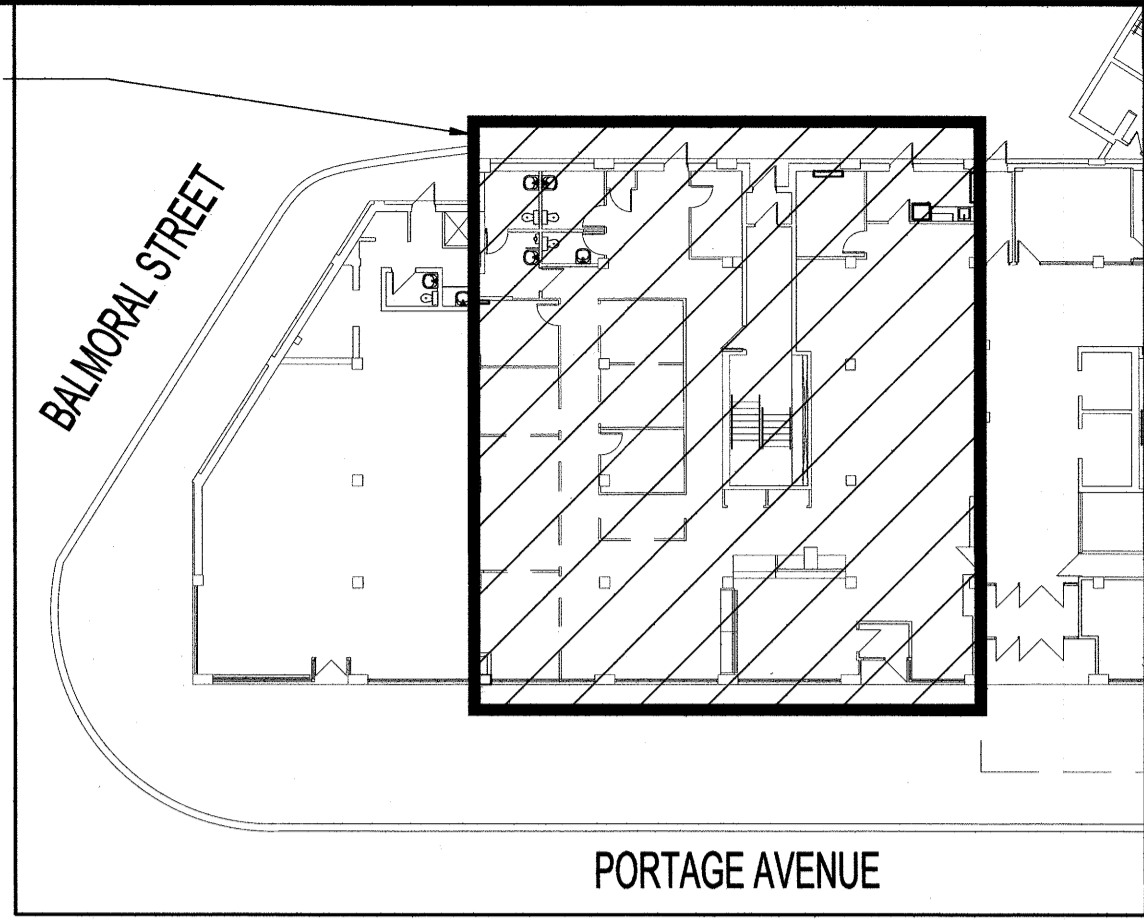

**NOTES:**  
 THESE DRAWINGS SHALL NOT BE SCALED. CONSULT WITH CLIENT AND DESIGNER ON ANY CONCERNS.  
 SUBMISSION OF SITE MARK-UPS, AS-BUILTS, OPERATING & MAINTENANCE MANUALS AND OTHER SUPPORTING DOCUMENTS TO CLIENT ARE MANDATORY AT THE COMPLETION OF THIS PROJECT.  
 THE CONTRACTOR SHALL VISIT THE SITE AND SATISFY ONESELF ALL DIMENSIONS, DATUM, AND DETAILED INFORMATION SHOWN ARE CORRECT.  
 THE CONTRACTOR IS TO REVIEW AND COORDINATE ALL ARCHITECTURAL, STRUCTURAL, MECHANICAL AND ELECTRICAL DRAWINGS FOR ADDITIONAL OPENINGS THROUGH FLOORS, WALLS, AND CEILINGS FOR DUCTS, PIPES & ELECTRICAL RISERS AND ALL OPENINGS NOT SHOWN ON DRAWINGS.  
 ALL OPENINGS THROUGH FIRE ASSEMBLIES INCLUDING FLOORS AND CEILINGS ARE TO BE FIRE STOPPED AND SEALED WITH UL-C APPROVED FIRE STOPPING TO MAINTAIN THE INTEGRITY OF THE FIRE SEPARATION, AND PROVIDE A SMOKE-TIGHT BARRIER.  
 ALL PRODUCTS AND MATERIALS TO BE USED AND INSTALLED SHALL CONFORM WITH MANUFACTURER'S SPECIFICATIONS, APPLICABLE CODES AND AUTHORITY HAVING JURISDICTION.  
 THE CONTRACTOR SHALL BE RESPONSIBLE TO PATCH AND MAKE GOOD ALL EXISTING CONSTRUCTION AFFECTED BY THE REMOVAL OF ALL ITEMS FORMING PART OF THE RENOVATION WORK.  
 GENERAL DUTY RECEPTABLES SHALL BE IVORY (MATCH EXISTING) & CSA APPROVED, CW IVORY (MATCH EXISTING) TRIM PLATES MOUNTED AS PER EXISTING OR OTHERWISE NOTED.  
 THERMOSTATS SHALL BE MOUNTED AS PER EXISTING OR OTHERWISE NOTED.  
 SUPPLY & INSTALL LAMACOID NAME PLATES ON ALL INCLUDING EXISTING PANEL BOARDS, SWITCHES & RECEPTABLES. PANEL SCHEDULE SHALL BE UPDATED, RETYPED & INSERTED TO INSIDE OF ASSOCIATED PANEL DOOR SLEEVE PROTECTOR.  
 ALL ABANDONED ELECTRICAL FIXTURES, COMPONENTS, RECEPTABLE & DATA WIRING SHALL BE REMOVED BACK TO SOURCE & TERMINATED AS PER APPLICABLE CODES.




ELECTRICAL LEGEND	
TYPE	DESCRIPTION
	ELECTRICAL PANEL BOARD
CCT	CIRCUIT (AA-1 INDICATES PANEL "AA"-CIRCUIT "1")
PTE	PUSH-TO-EXIT
	LIGHT SWITCH, SINGLE, CCT (AA-1 INDICATES PANEL "AA"-CIRCUIT "1")
	LIGHT SWITCH, 3-WAY
	LIGHT SWITCH, DIMMER
	DUPLEX RECEPTACLE
	HEIGHT IN INCHES ABOVE FINISH FLOOR TO CENTERLINE OF DEVICE
	AUTOMATIC DOOR ACTUATOR SWITCH
	AUTOMATIC DOOR OPERATOR
	FIRE ALARM MANUAL PULL STATION
	VOICE (TELEPHONE) PORT
	DATA/VOICE PORTS IN SINGLE DEVICE BOX.
	DATA PORT
	PANIC ALARM PUSH BUTTON
	FIRE BELL
	EMERGENCY BATTERY UNIT WITH DUAL HEADS
	EMERGENCY DUAL HEAD LIGHTS
	THERMOSTAT, HEAT-COOL
	AUTOMATED EXTERNAL DEFIBRILLATOR

DRAWING LIST	
SHEET No:	SHEET TITLE
E1	PARTIAL MAIN FLOOR PLAN: DEMOLITION POWER, DATA, COMMUNICATION
E2	PARTIAL MAIN FLOOR PLAN: RENOVATION POWER, DATA, COMMUNICATION
E3	PARTIAL MAIN FLOOR REFLECTED CEILING PLAN: EXISTING
E4	PARTIAL MAIN FLOOR REFLECTED CEILING PLAN: RENOVATION; LIGHTING
E5	ELECTRICAL AND DATA SPECIFICATIONS

**POWER, DATA & COMMUNICATION DEMOLITION NOTES:**  
 ALSO SEE NOTES & SPECIFICATIONS.

- REMOVE WIRING & COMPONENTS BACK TO SOURCE. ABANDON WIRING, COMPONENTS & SUPPORTS NOT ALLOW.
- RELOCATE VOICE & DATA PORT DESIGNATIONS TO NEW LOCATIONS AS SHOWN. REUSE TAGGED VOICE & DATA DESIGNATIONS FOR NEW LOCATIONS BUT DO NOT REUSE OLD PORTS OR CABLING. SEE DATA CABLING SPECIFICATIONS.
- REMOVE POWER POLE & REPLACE CEILING TILE WITH NEW TO MATCH EXISTING.
- RELOCATION TO-BE-DETERMINED BASED ON LOCATION OF NEW SELF-SERVE KIOSK, CONSULT WITH CONTRACT ADMINISTRATOR.
- RELOCATE POWER, DATA & TELEPHONE PORT FOR EXISTING XEROX WORKCENTRE. CONFIRM LOCATION WITH CONTRACT ADMINISTRATOR.

No.	REVISION/DESCRIPTION	BY	DATE
1	ISSUED FOR CONSTRUCTION	DTA	2015.08.24
0	REVISED TO REFLECT CLIENT CHANGES.	DTA	2015.07.29

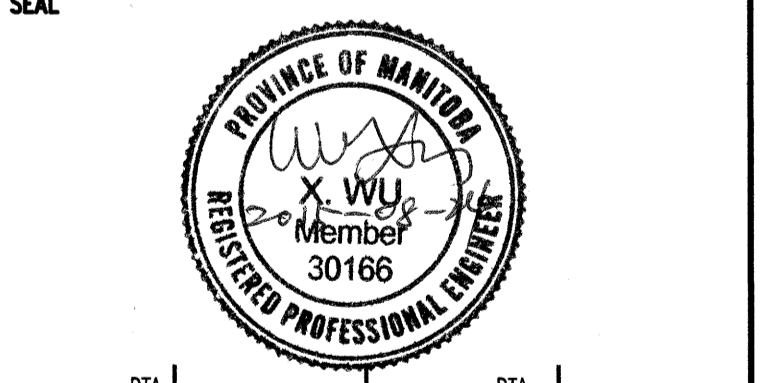

DRAWN DATE	CHECKED USER	DESIGNED	APPROVED
2015.04.15			

THE CITY OF WINNIPEG  
 PLANNING, PROPERTY AND  
 DEVELOPMENT DEPARTMENT  
 MUNICIPAL ACCOMMODATIONS DIVISION  
 3-65 GARRY STREET, R3C 4K4

PROJECT  
 RICE BUILDING  
 WINNIPEG PARKING AUTHORITY  
 RENOVATION DESIGN  
 491 PORTAGE AVENUE

SHEET TITLE  
 PARTIAL MAIN FLOOR PLAN  
 DEMOLITION  
 POWER, DATA AND COMMUNICATION

SCALE	PROJECT No:	SHEET No:
AS SHOWN	2013-127-01	E1R1

PARTIAL MAIN FLOOR PLAN - DEMO - POWER, DATA AND COMMUNICATION  
 SCALE: 1/4"=1'-0"