



**PLAN**  
SCALE: 1 : 20

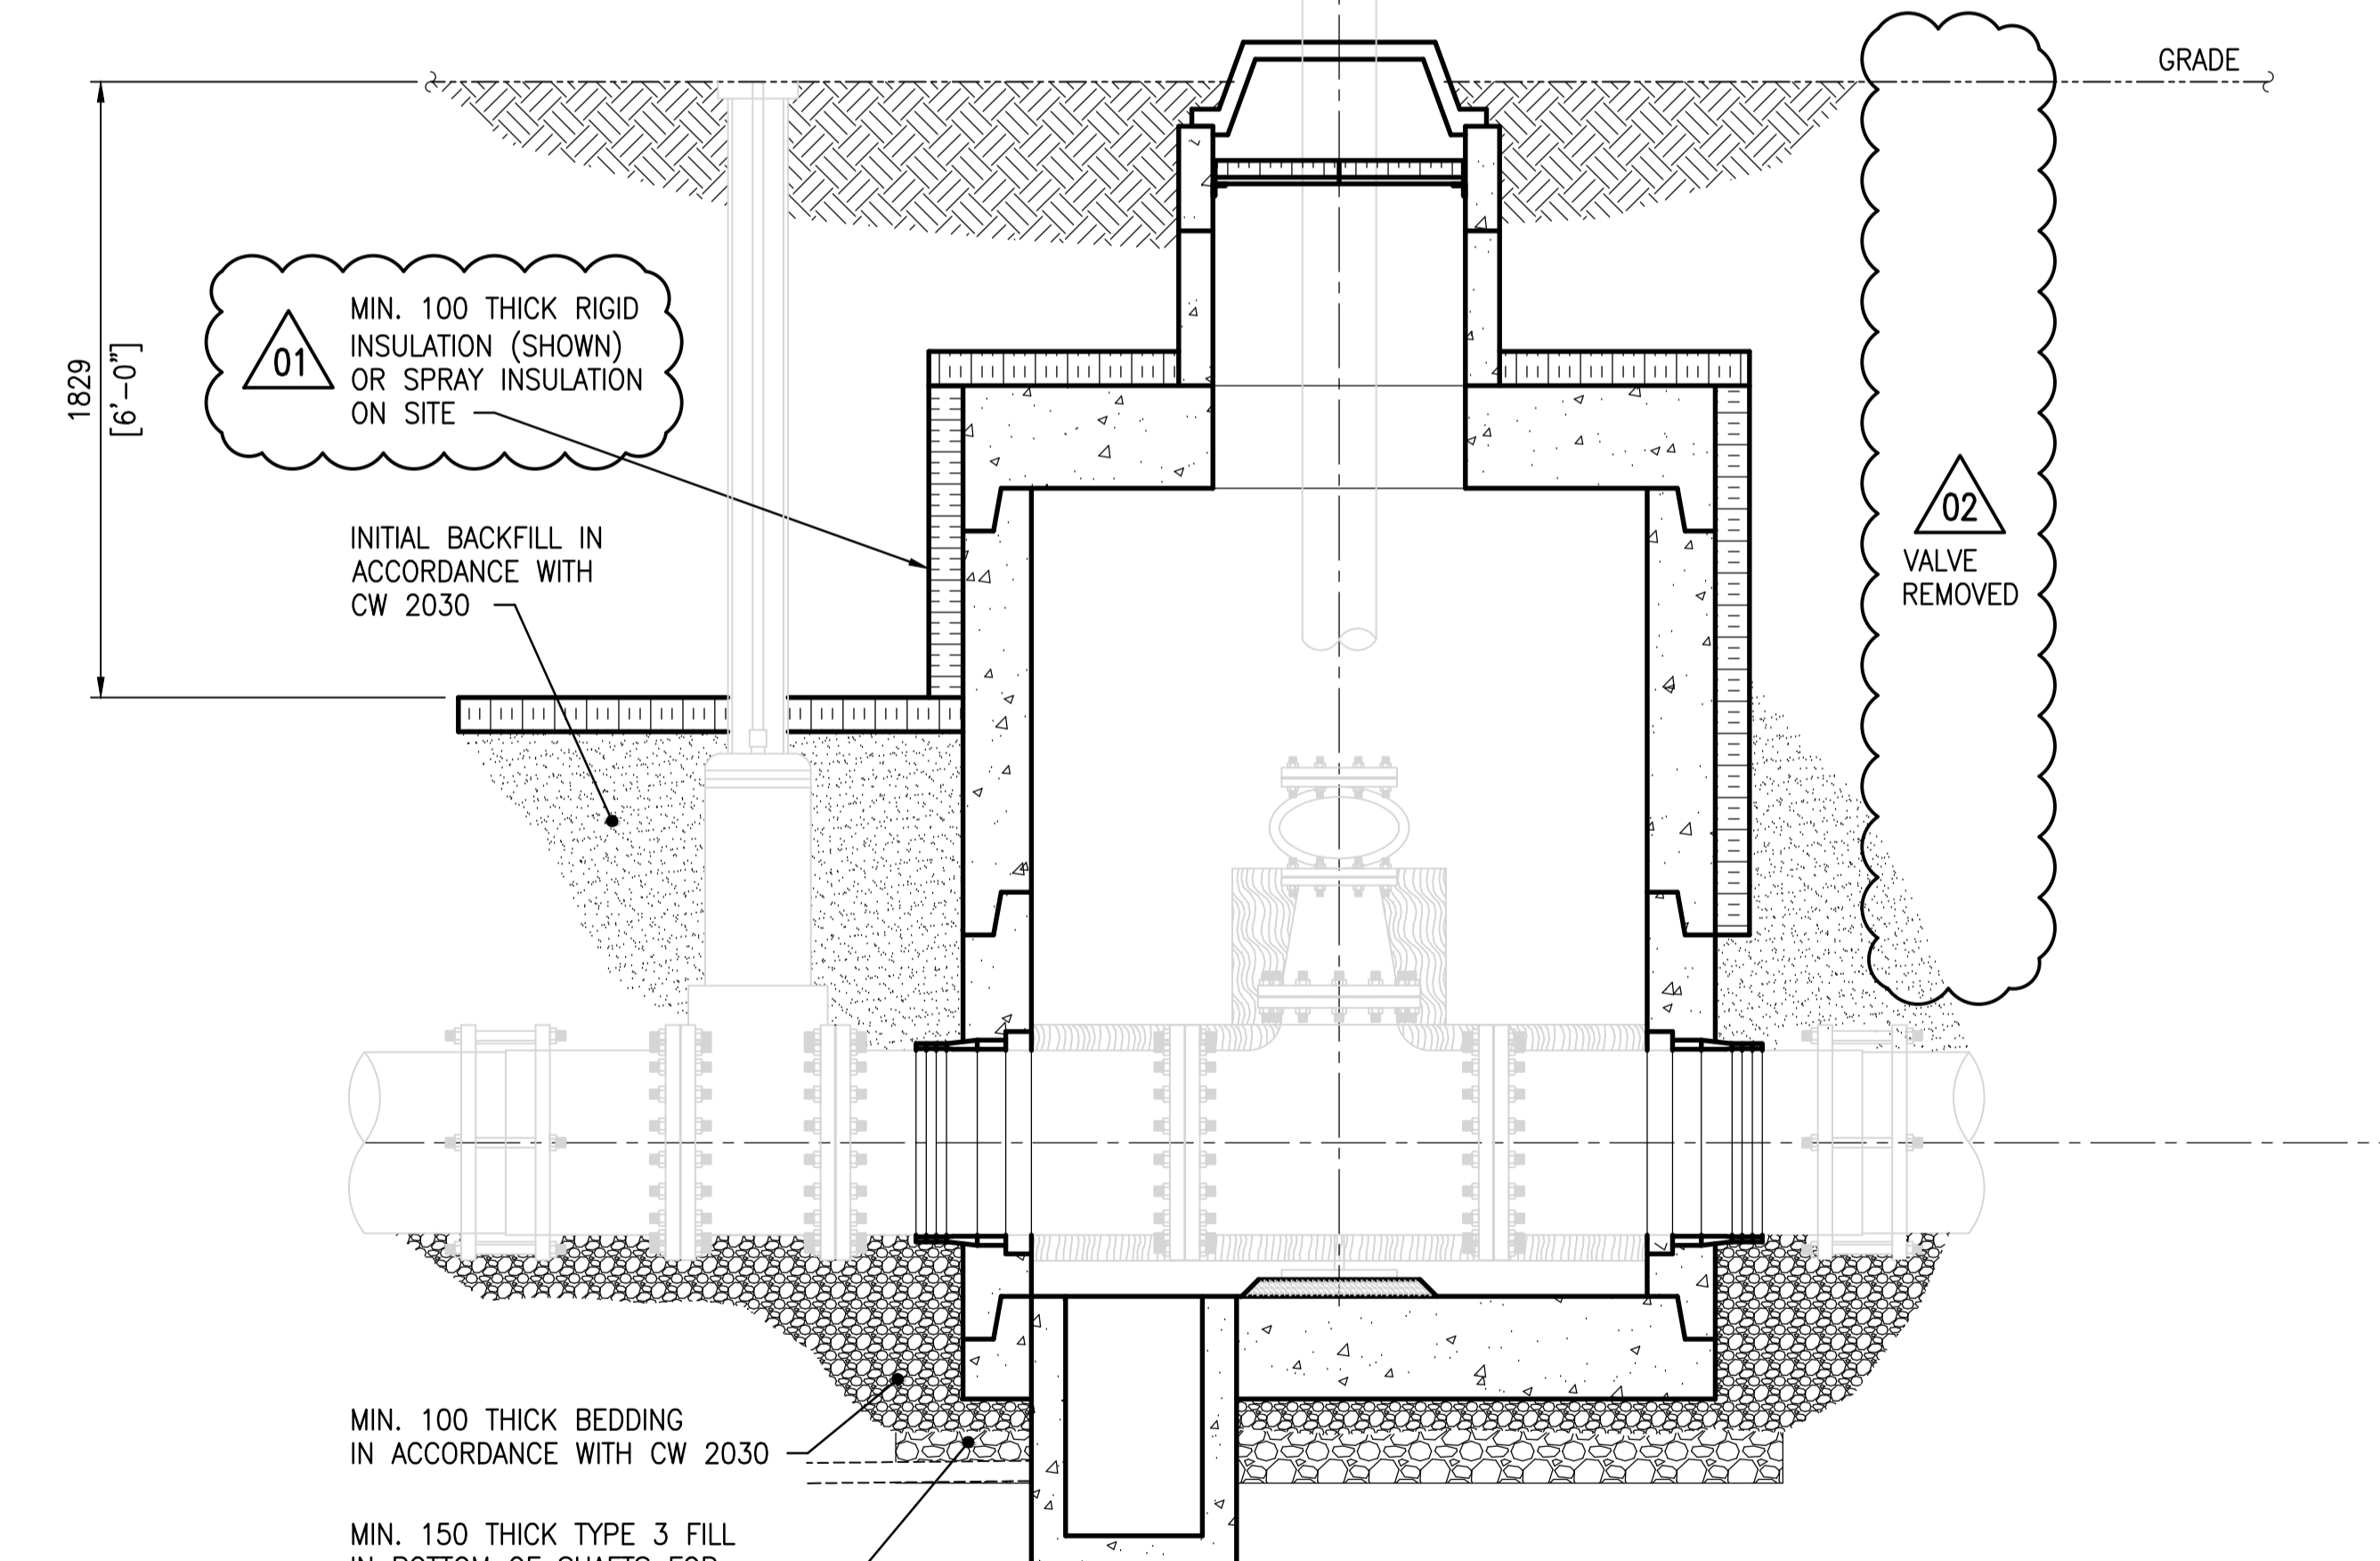


**A ELEVATION**  
SCALE: 1 : 20

DRAWING NUMBER	REFERENCE DRAWINGS
S-265	AINSLIE COMM. & PUMPING STATION - SITE PLAN
403-B	AINSLIE COMM. & PUMPING STATION - SUPERSTRUCTURE & DETAILS
403-A	AINSLIE COMM. & PUMPING STATION - REINFORCING DETAILS
403	AINSLIE COMM. & PUMPING STATION

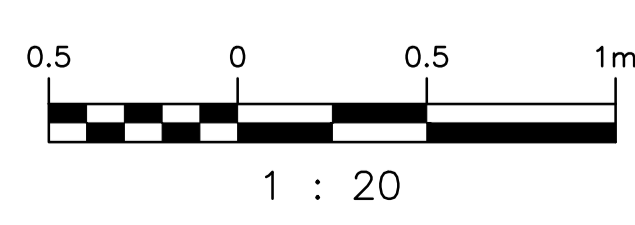

**NOTES:**  
 1. SEE DRAWING 1-0169L-S0004 FOR GENERAL NOTES.  
 2. SEE DRAWING 1-0169L-S0005 FOR STRUCTURAL NOTES.

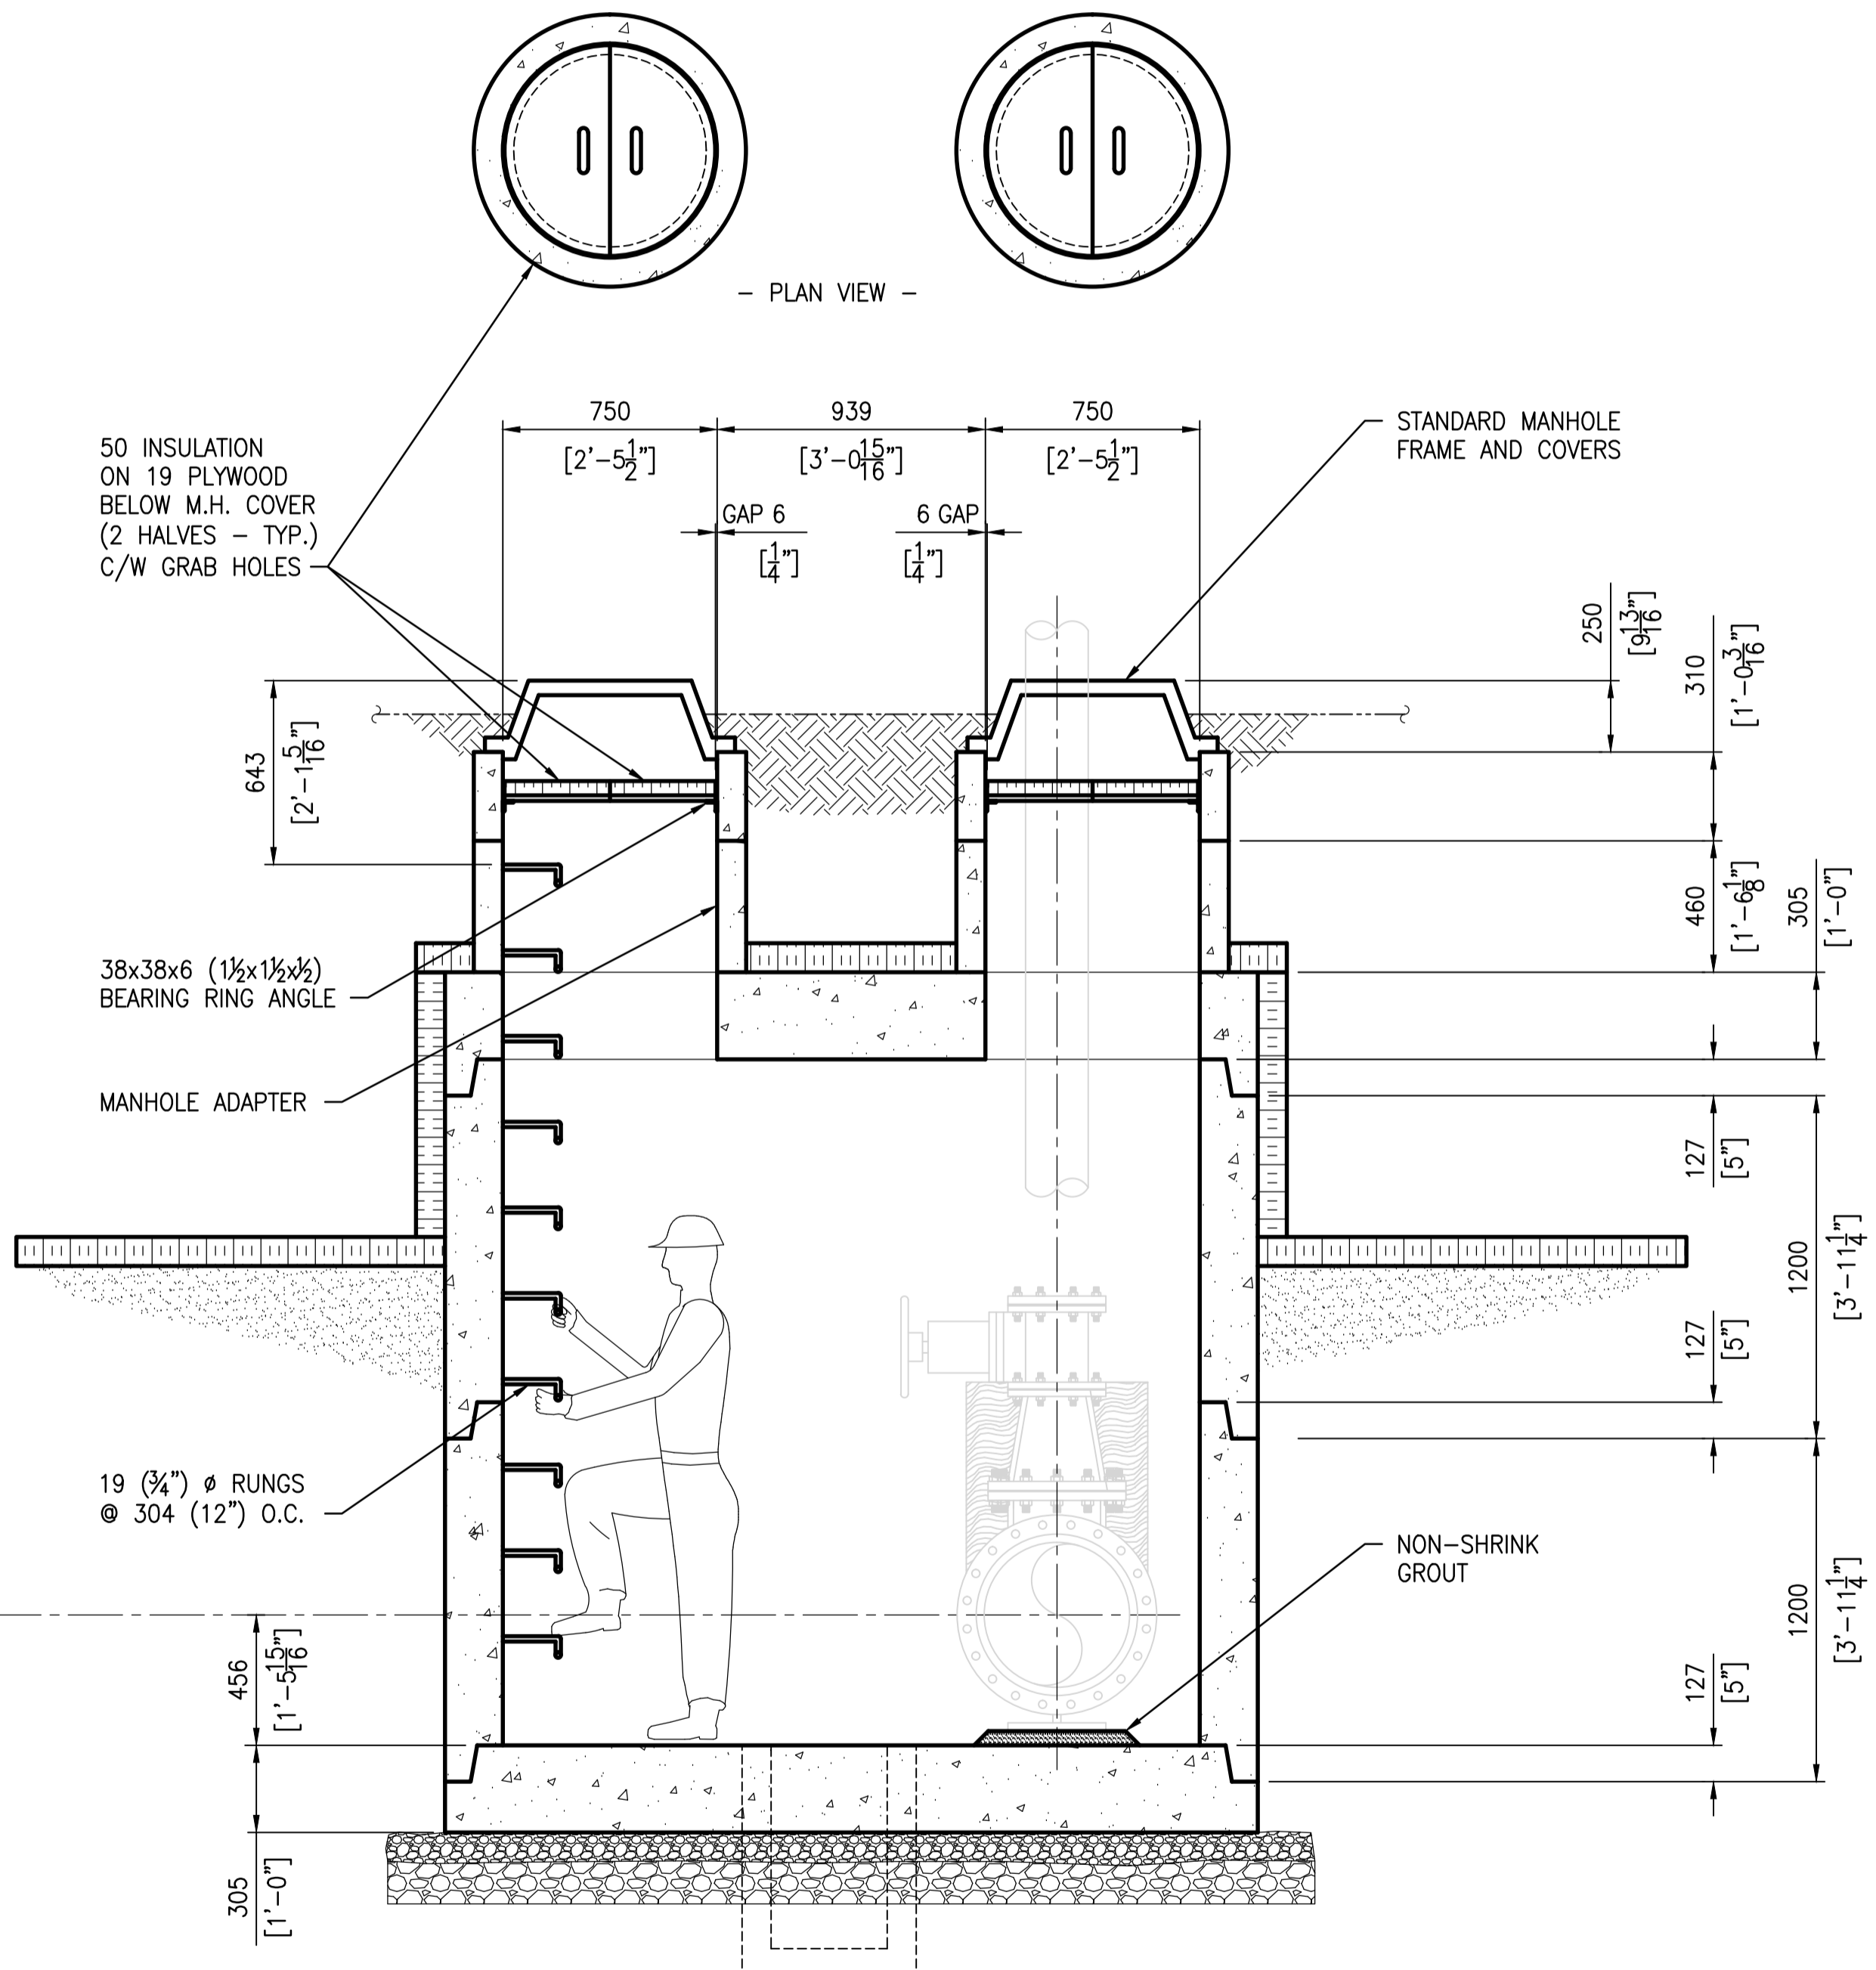

**B ELEVATION**  
SCALE: 1 : 20

NO.	REVISIONS	DATE	DESIGN/CHECK
02	VALVE REMOVED	2015/10/09	
01	REVISED INSULATION NOTE/MANHOLE COVER	2015/10/08	
00	ISSUED FOR ADDENDUM - MANHOLE DETAILS	2015/09/28	

SNC-LAVALIN INC. 148 Nature Park Way Winnipeg, MB, Canada R3P 0X7 204-786-8080	
DESIGNED BY: I. PARKINSON	CHECKED BY:
DRAWN BY: B. DICKSON	APPROVED BY:
SCALE: 1:20	ISSUED FOR CONSTRUCTION
DATE: 2015/09/23	BY:
CONSULTANT NO.:	DATE:

ENGINEER'S SEAL  
**PRELIMINARY**  
 NOT TO BE  
 USED FOR  
 CONSTRUCTION

**THE CITY OF WINNIPEG**  
 WATER AND WASTE DEPARTMENT

OLIVE WASTEWATER LIFT STATION  
 2015 UPGRADES  
 PLAN AND ELEVATION  
 MANHOLE STRUCTURE

CITY DRAWING NUMBER	SHEET	REV.	SIZE
1-0169L-S0010	001	02	A1