



File Name: P:\Projects\2015\15-0107-011\DWG\Mech\15-0107-011_M01.dwg - Tab: M01 Plotted By: dderoché 10/02/2015 [Fri 10:46am]

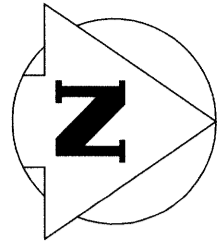


LEGEND:


	NEW EQUIPMENT/PIPING
	EXISTING PIPING
	EXISTING SHUTOFF VALVE
	NEW CHECK VALVE

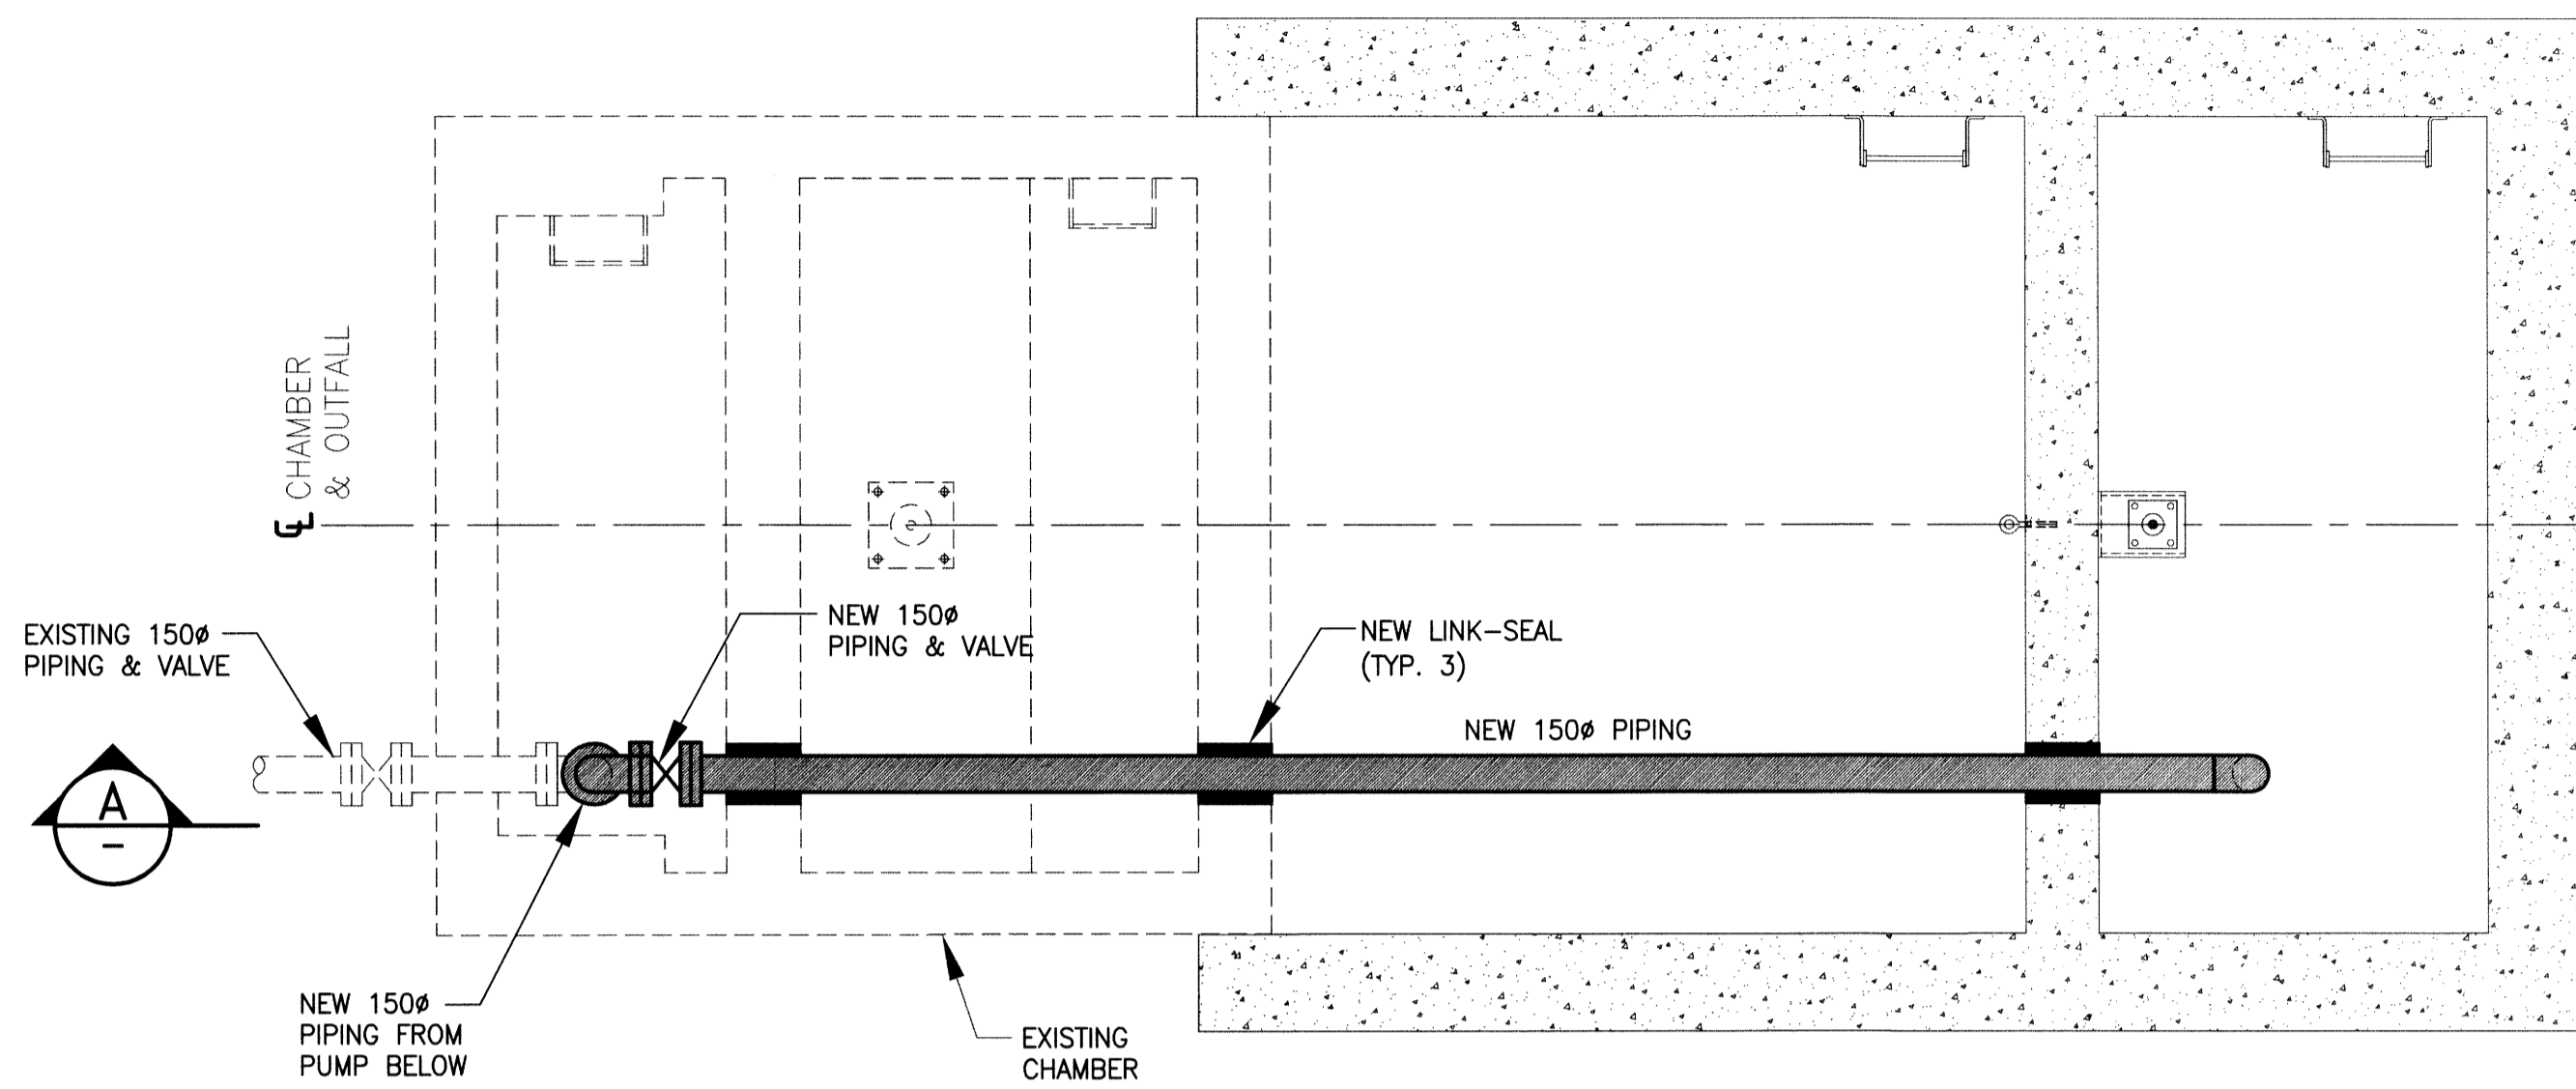

B PLAN - ELEV. - 231.2M
SCALE: 1:30

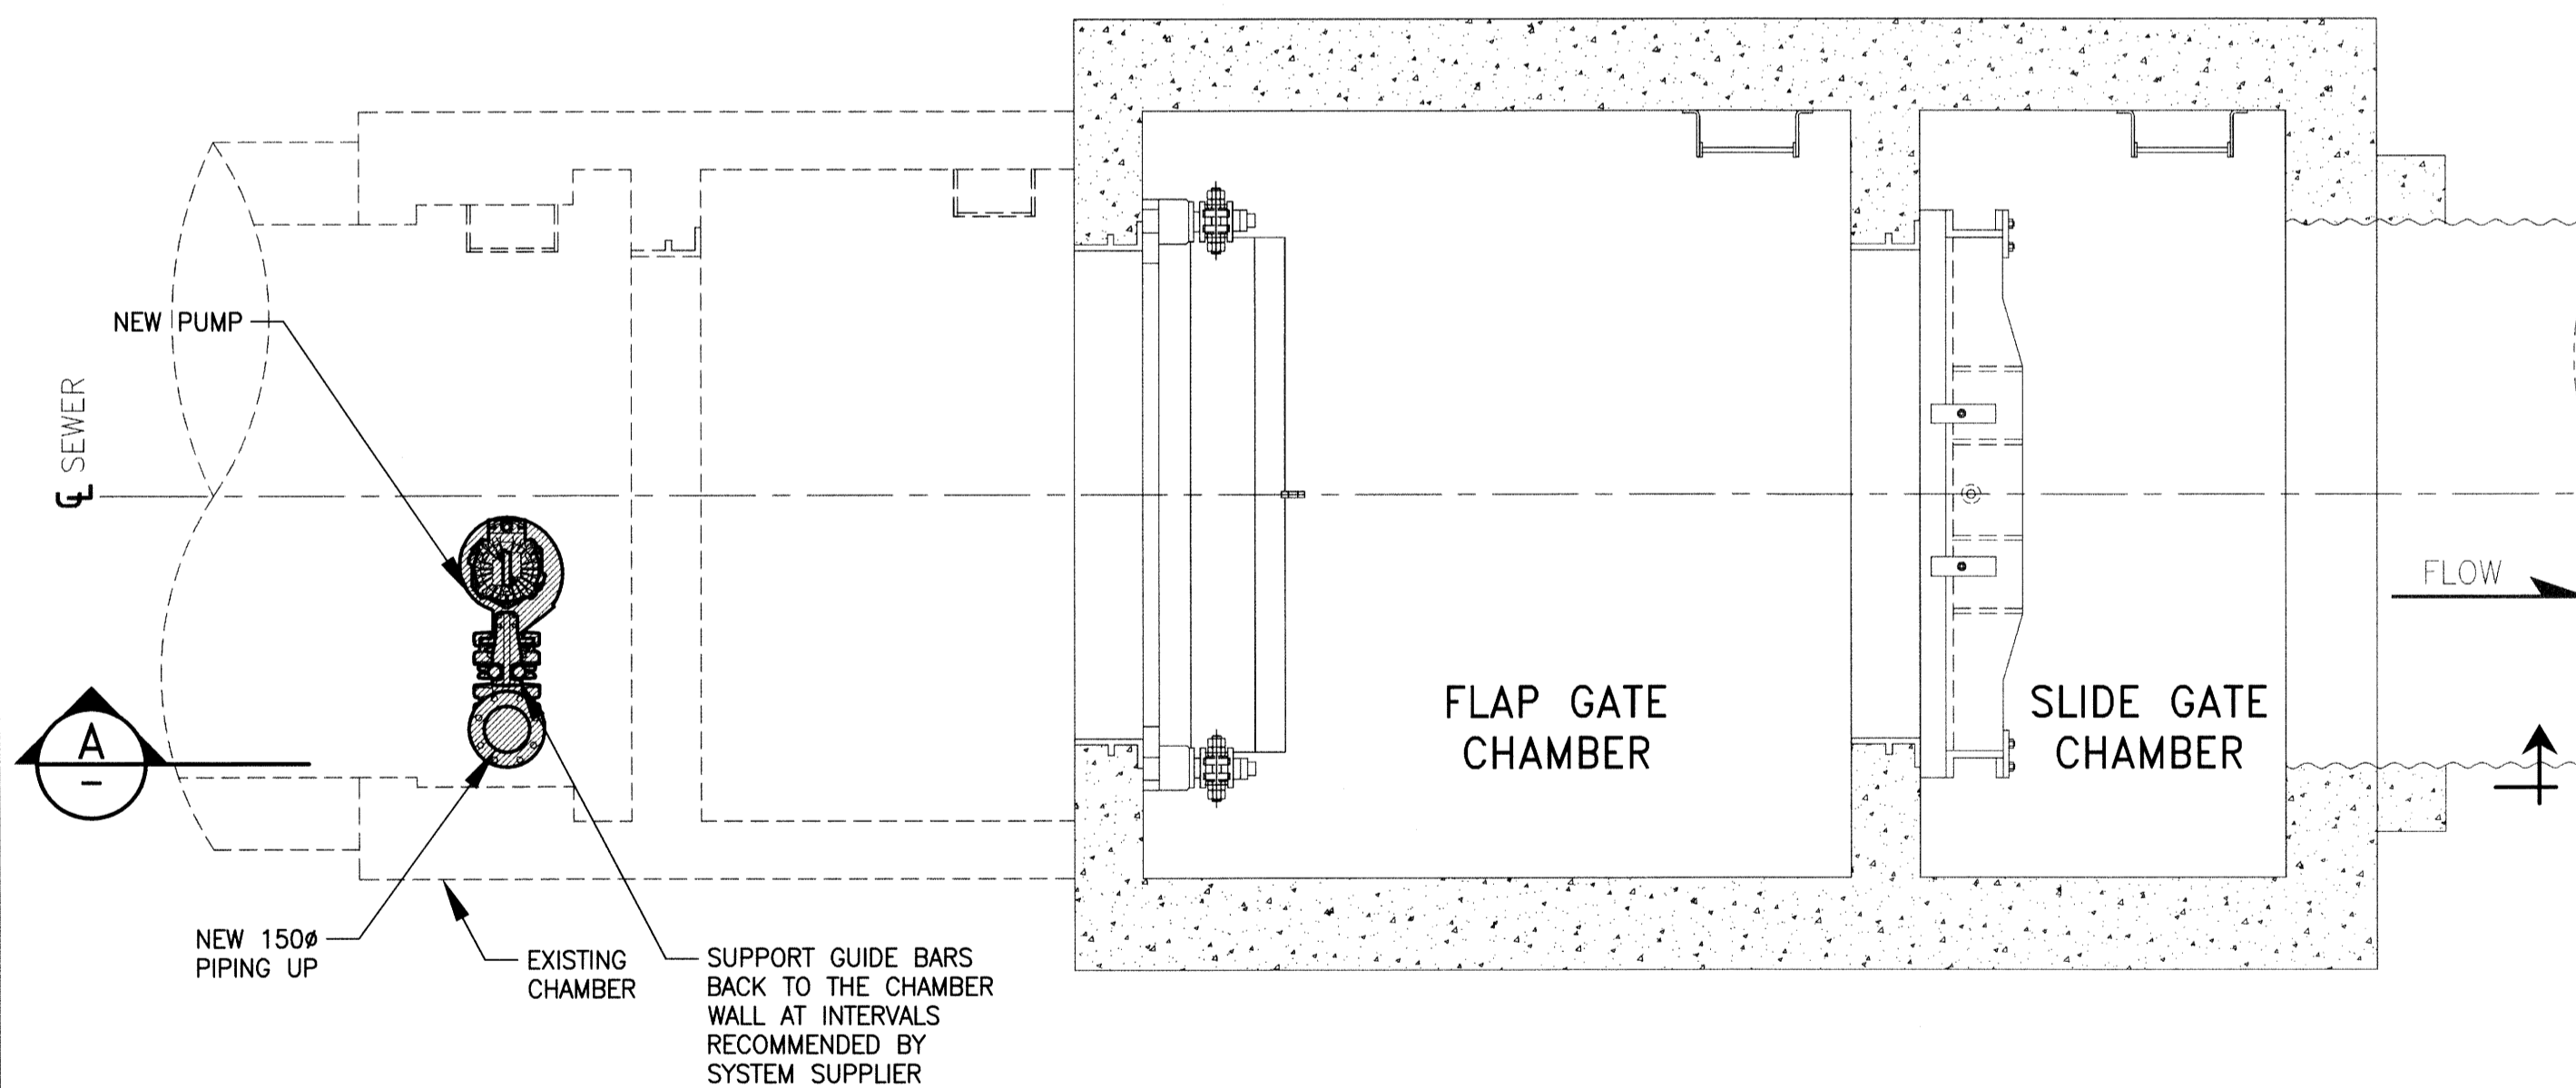


C PLAN - ELEV. - 223M
SCALE: 1:30

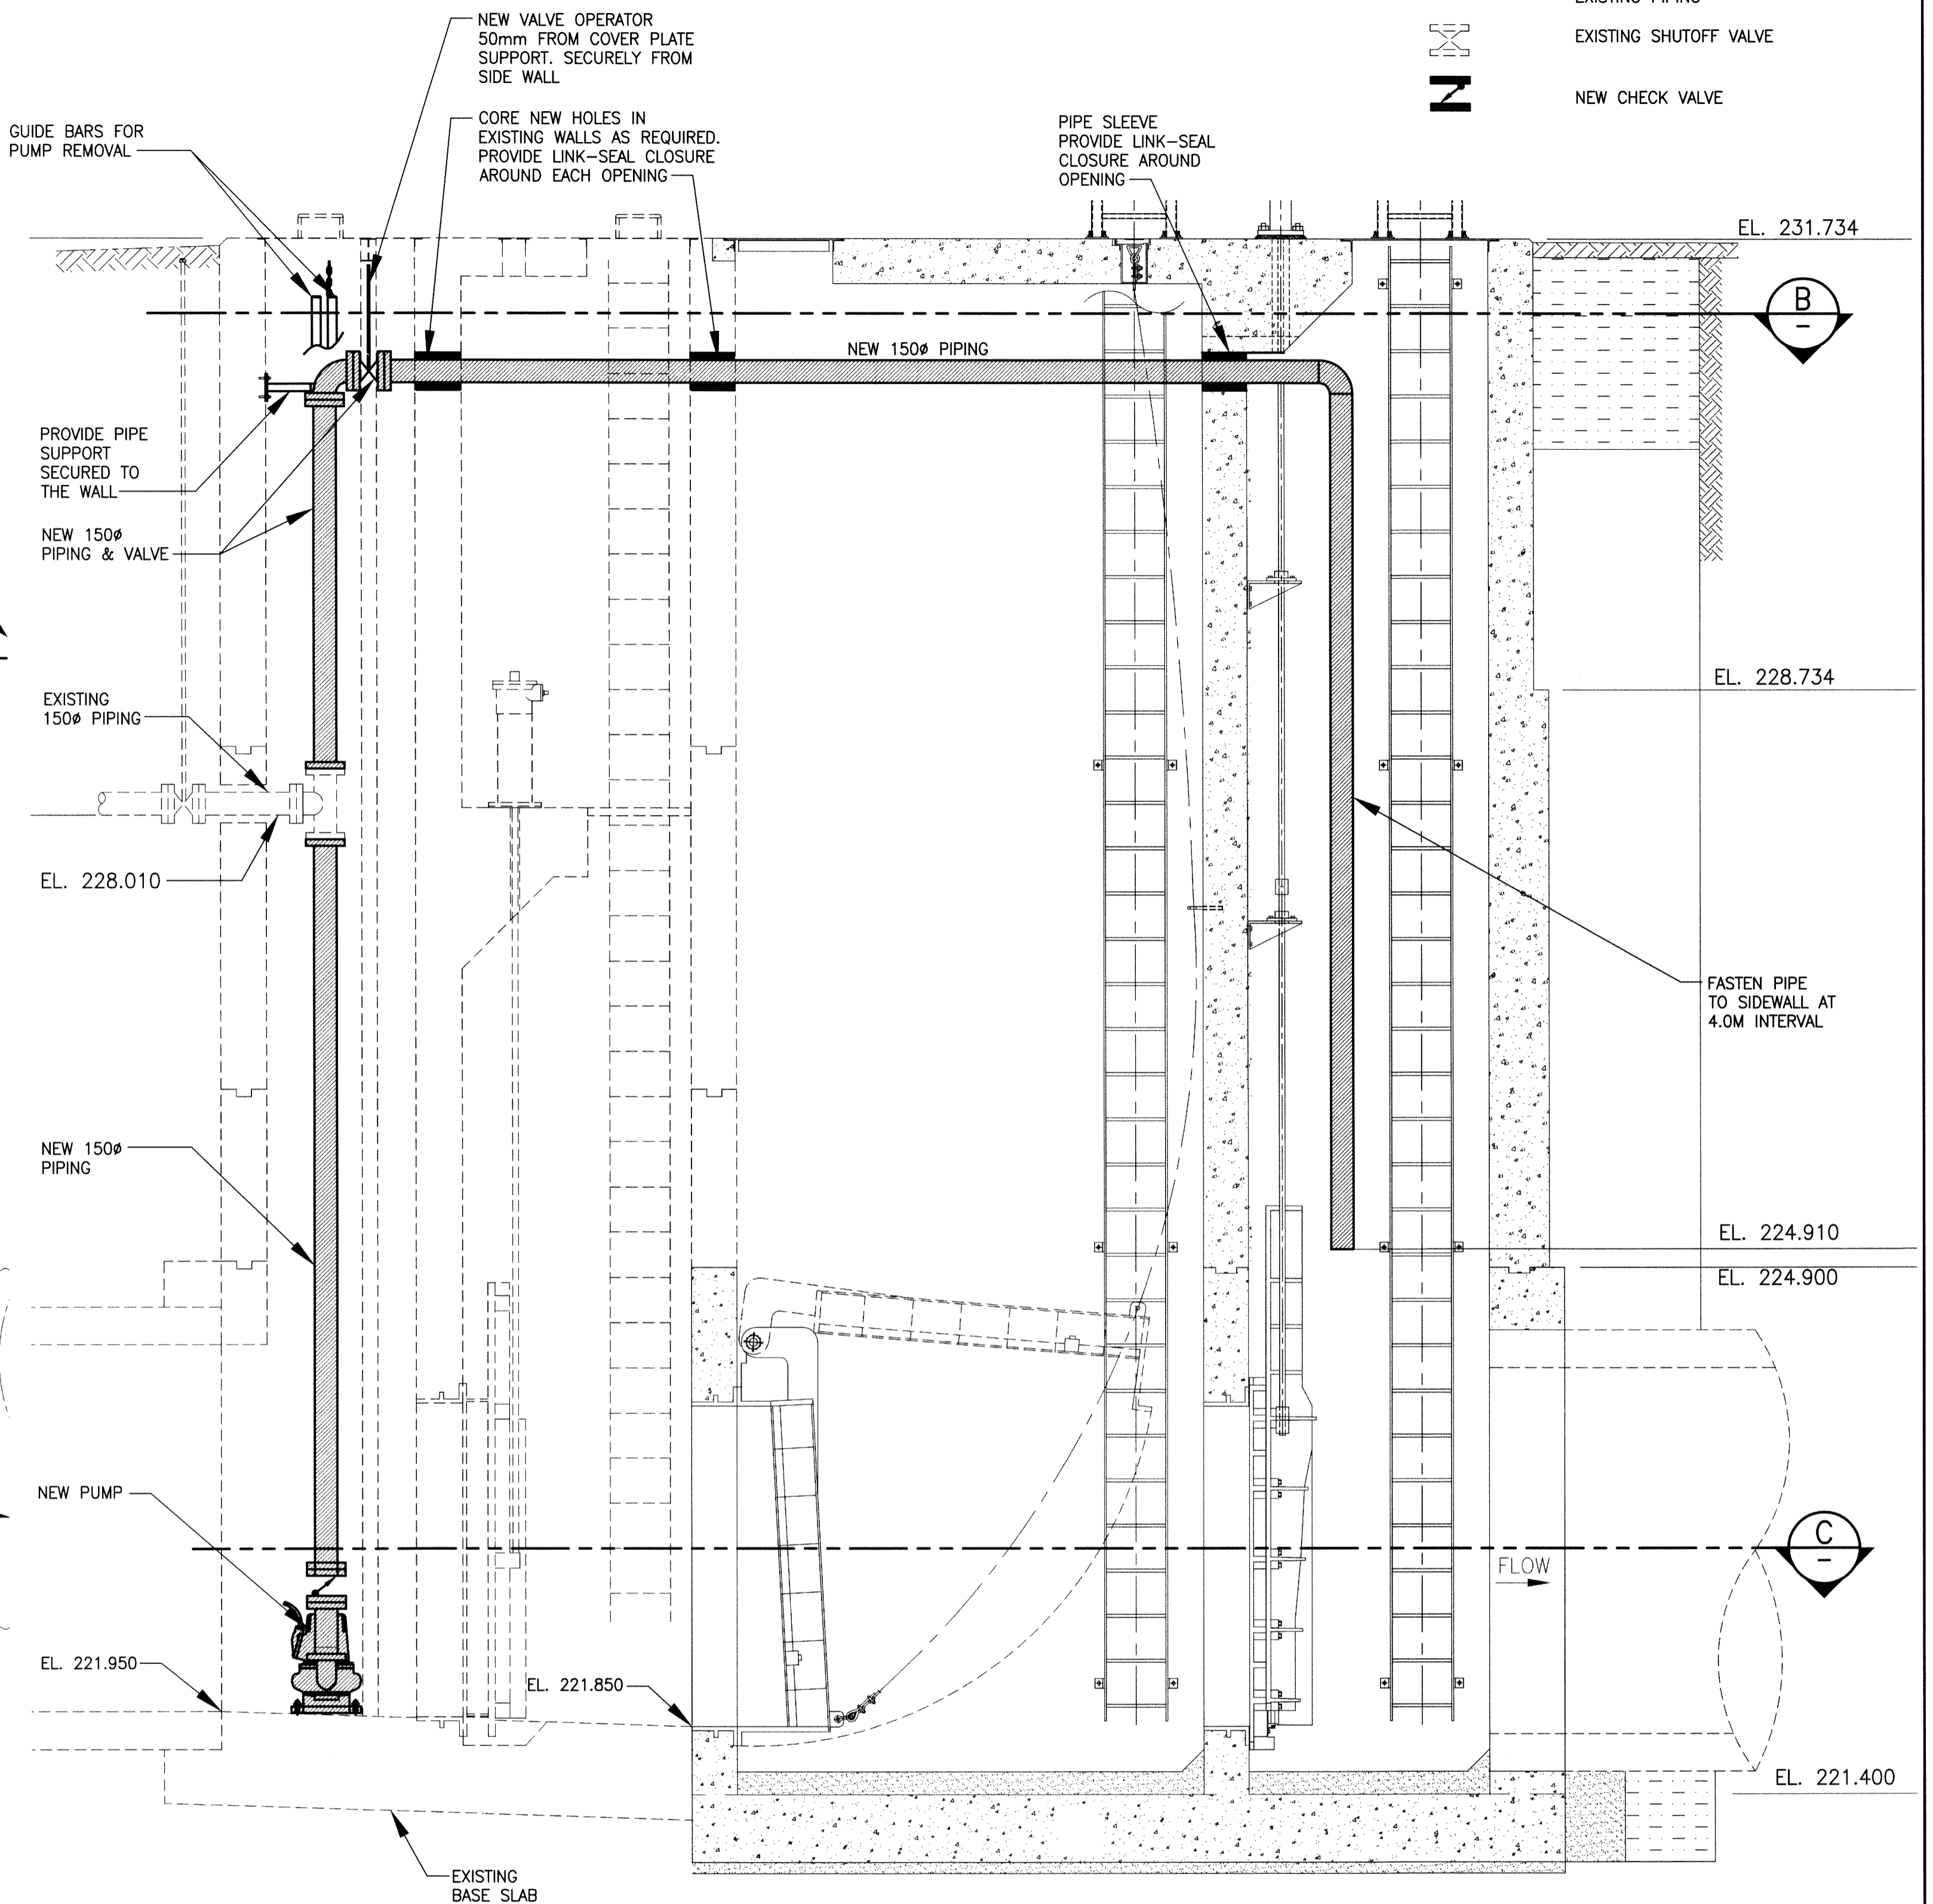

A SECTION
SCALE: 1:30

METRIC
WHOLE NUMBERS INDICATE MILLIMETRES
DECIMALIZED NUMBERS INDICATE METRES

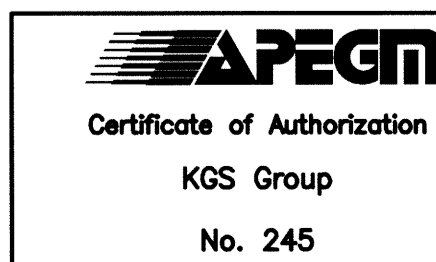

FIELD BOOK #:		POSTED TO LBIS	
DESIGNED BY	RED	CHECKED BY	DJ
DRAWN BY	RLR	APPROVED BY	[Signature]
HDR. SCALE	AS NOTED	RELEASED FOR CONSTRUCTION	
VERTICAL SCALE	AS NOTED	DATE	2015 08 19
NO. REVISIONS	DATE	BY	
0	ISSUED FOR CONSTRUCTION	15/10/08	LAB

KGS GROUP CONSULTING ENGINEERS		ENGINEER'S SEAL
		M01

 THE CITY OF WINNIPEG WATER AND WASTE DEPARTMENT		SHEET 1 OF 1
FORT ROUGE OUTFALL CHAMBER UPGRADES FORT ROUGE MECHANICAL PLANS AND SECTION		CITY DRAWING NUMBER 1-0204A-M0001-001