



THE CITY OF WINNIPEG

WATER AND WASTE DEPARTMENT
ENGINEERING DIVISION

CITY OF WINNIPEG WATER TREATMENT RESEARCH AND PROCESS OPTIMIZATION FACILITY


VENTILATION AND CIVIL SERVICES

BID OPPORTUNITY NUMBER 85-2015

DRAWING LIST

<u>CONSULTANT DWG No.</u>	<u>CITY DWG No.</u>	<u>TITLE</u>
WX-H0001	1-0601X-H0001-001-01	AIR FLOW SCHEMATIC
WX-H0121	1-0601X-H0002-001-01	PARTIAL PLANS AND SECTIONS
WX-M0112	1-0601X-M0002-001-02	RAW WATER SUPPLY TO PILOT PLANT/ RESIDUALS DRAIN TO TSET
WX-M0501	1-0601X-M0008-001-02	STANDARD DETAILS SHEET 1 OF 2
WR-H0121	1-0601R-H0001-001-03	RESIDUALS HANDLING AREA SECOND FLOOR PLAN
WR-H0131	1-0601R-H0002-001-02	RESIDUALS HANDLING AREA THIRD FLOOR PLAN

DRAWINGS SHOWN SCREENED ARE PROVIDED FOR INFORMATION ONLY

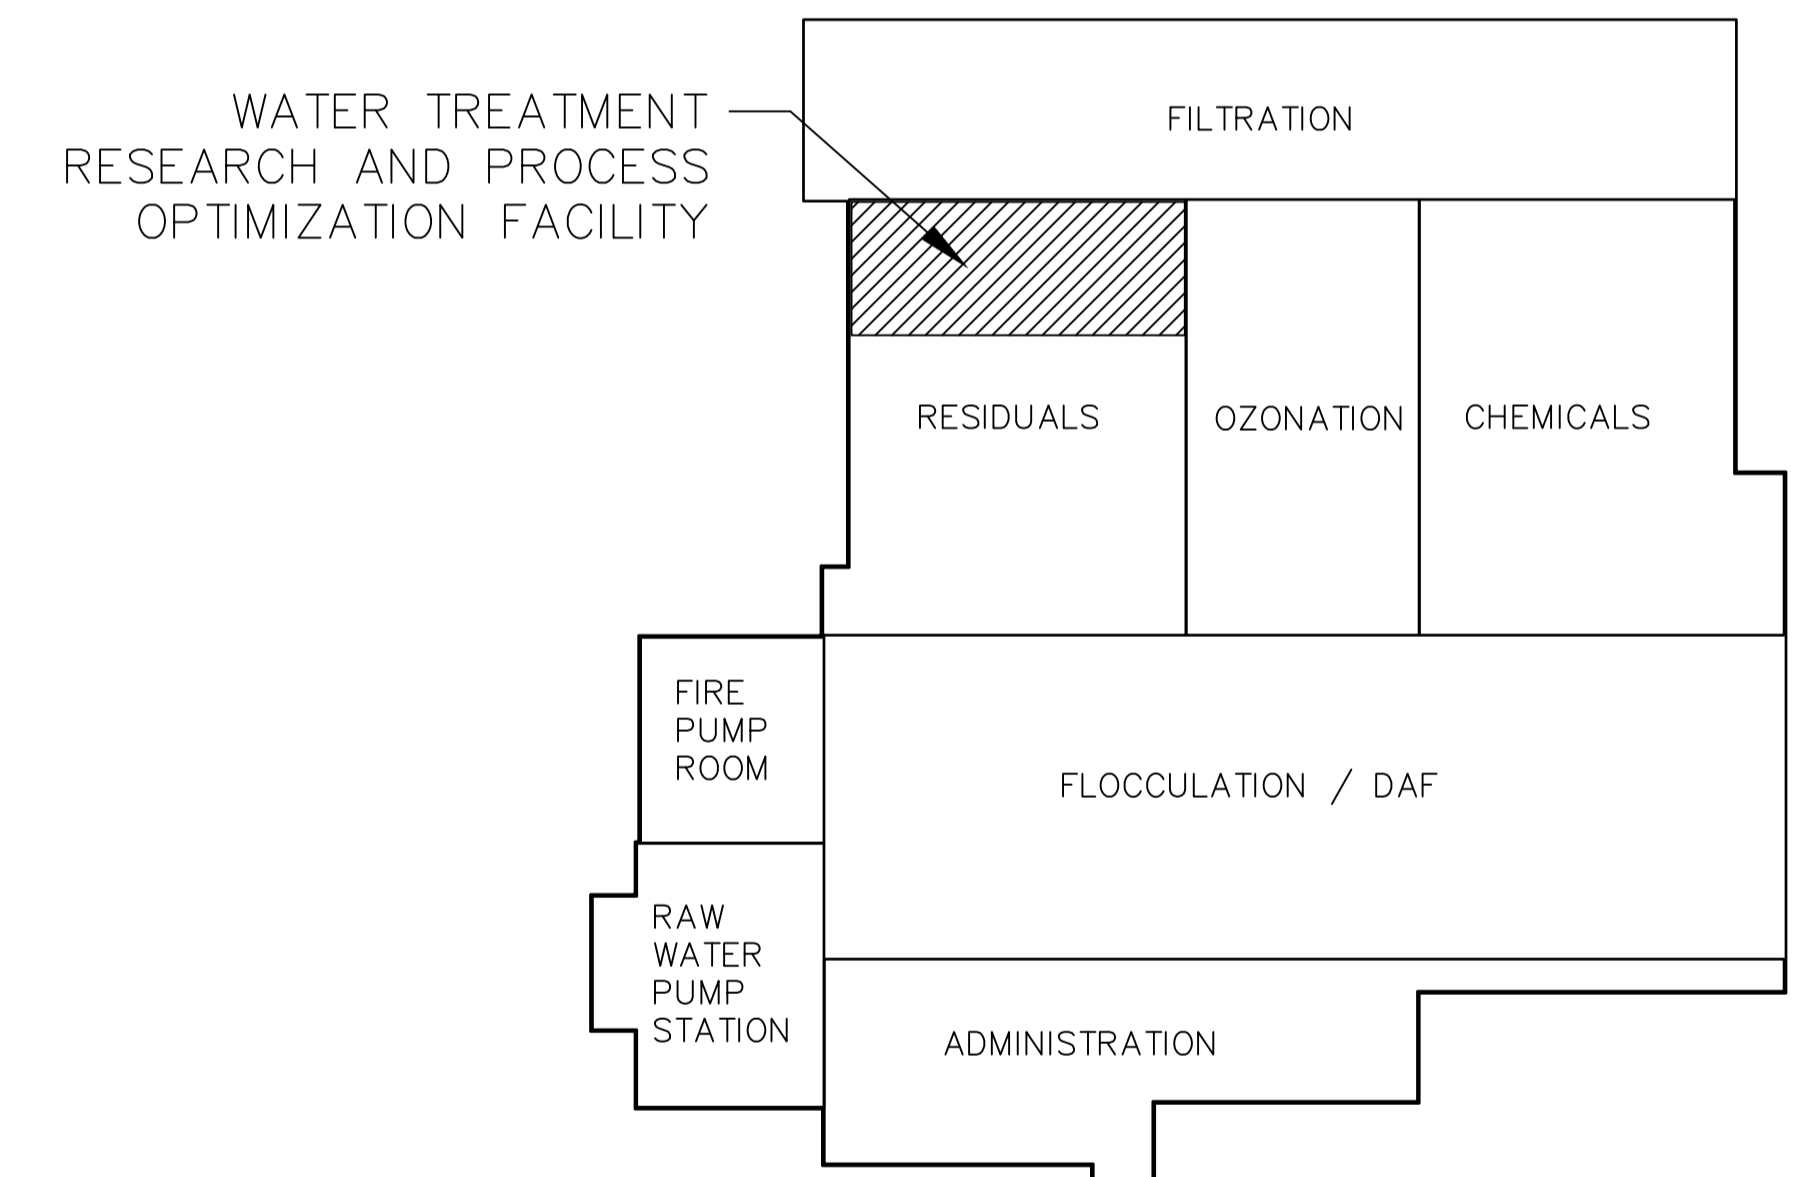

WATER TREATMENT PLANT
KEY MAP
NTS