
 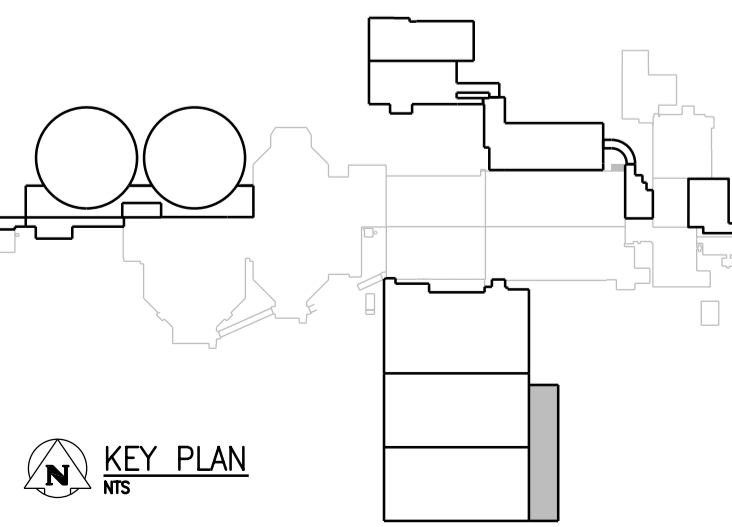


NOTES:

- REFER TO DUCT SCHEDULE FOR MATERIAL
- REFER TO ARCHITECTURAL STANDARD DETAILS FOR GAS PIPE SUPPORT ON ROOF AND PIPE THROUGH ROOF
- REFER TO ARCHITECTURAL STANDARD DETAILS FOR VENT THROUGH ROOF

GROUND FLOOR PART - PLAN B

1:50



NO.	REVISIONS	DATE	DESIGN	CHECK
01	ISSUED FOR ADD. 2 - B.O. 899-2015	02/2016	A.B.	J.C.
00	ISSUED FOR TENDER - B.O. 899-2015	01/2016	A.B.	J.C.

CH2MHILL
SNC-LAVALIN

DESIGNED BY: D. LE
DRAWN BY: A. BERSHTEIN
SCALE: 1:50
DATE: 2016/01/29
CONSULTANT NO.: 474248

CHECKED BY: T. TRAN
APPROVED BY: H.T. FREIHAMMER
ISSUED FOR CONSTRUCTION BY: T. TURZAK
DATE: 2016/01/29

ENGINEER'S SEAL
2016/02/2016
PROVINCE OF MANITOBA
REGISTERED PROFESSIONAL ENGINEER
D.H. LE
Member
31804

THE CITY OF WINNIPEG
Winnipeg WATER AND WASTE DEPARTMENT

SOUTH END WATER POLLUTION CONTROL CENTRE
SEWPPC UPGRADING/EXPANSION PROJECT
MECHANICAL
BIOREACTOR/BLOWER BUILDING
HVAC - GROUND FLOOR PLAN - PART B

CITY DRAWING NUMBER: 1-0102-MGAD-R609
SHEET: 001
REV.: 01
SIZE: A1