
 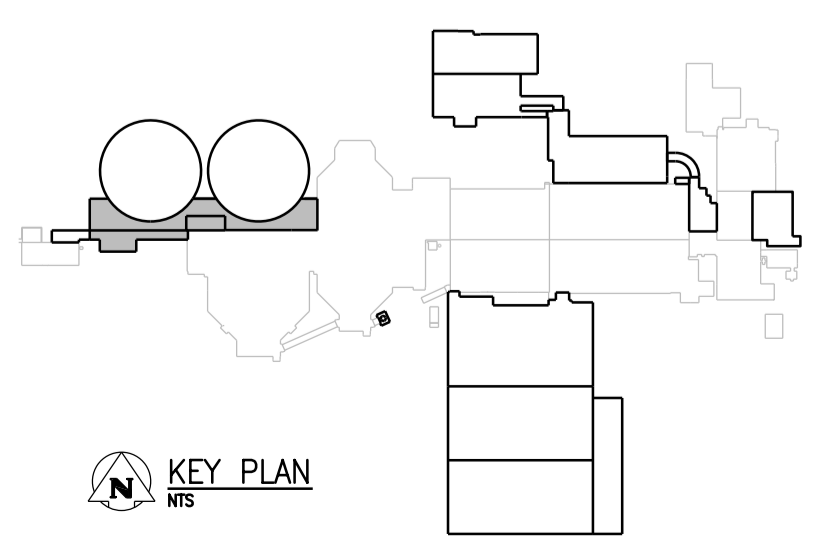


ROOF PLAN - PART B
1:100



APEGM
Certificate of Authorization
CH2M HILL Canada Ltd.
No. 1441

NO.	REVISIONS	DATE	DESIGN	CHECK
01	ISSUED FOR ADD. 2 - B.O. 899-2015	02/2016	G.O.	J.C.
00	ISSUED FOR TENDER - B.O. 899-2015	01/2016	G.O.	J.C.

CH2MHILL		ENGINEER'S SEAL	
SNC-LAVALIN		KCS GROUP	
DESIGNED BY: A. THAKKAR	CHECKED BY: E. LUI		
DRAWN BY: G. OMORI	APPROVED BY: H.T. FREIHAMMER		
SCALE: 1:100	ISSUED FOR CONSTRUCTION BY: T. TURZAK		
DATE: 2016/01/29	DATE: 2016/01/29		
CONSULTANT NO.: 474248			

THE CITY OF WINNIPEG
Winnipeg WATER AND WASTE DEPARTMENT

SOUTH END WATER POLLUTION CONTROL CENTRE
SEWPCC UPGRADING/EXPANSION PROJECT
STRUCTURAL
SECONDARY CLARIFIERS 4 AND 5
ROOF PLAN - PART B

CITY DRAWING NUMBER: 1-0102-SGAD-S018 | SHEET: 001 | REV.: 01 | SIZE: A1