
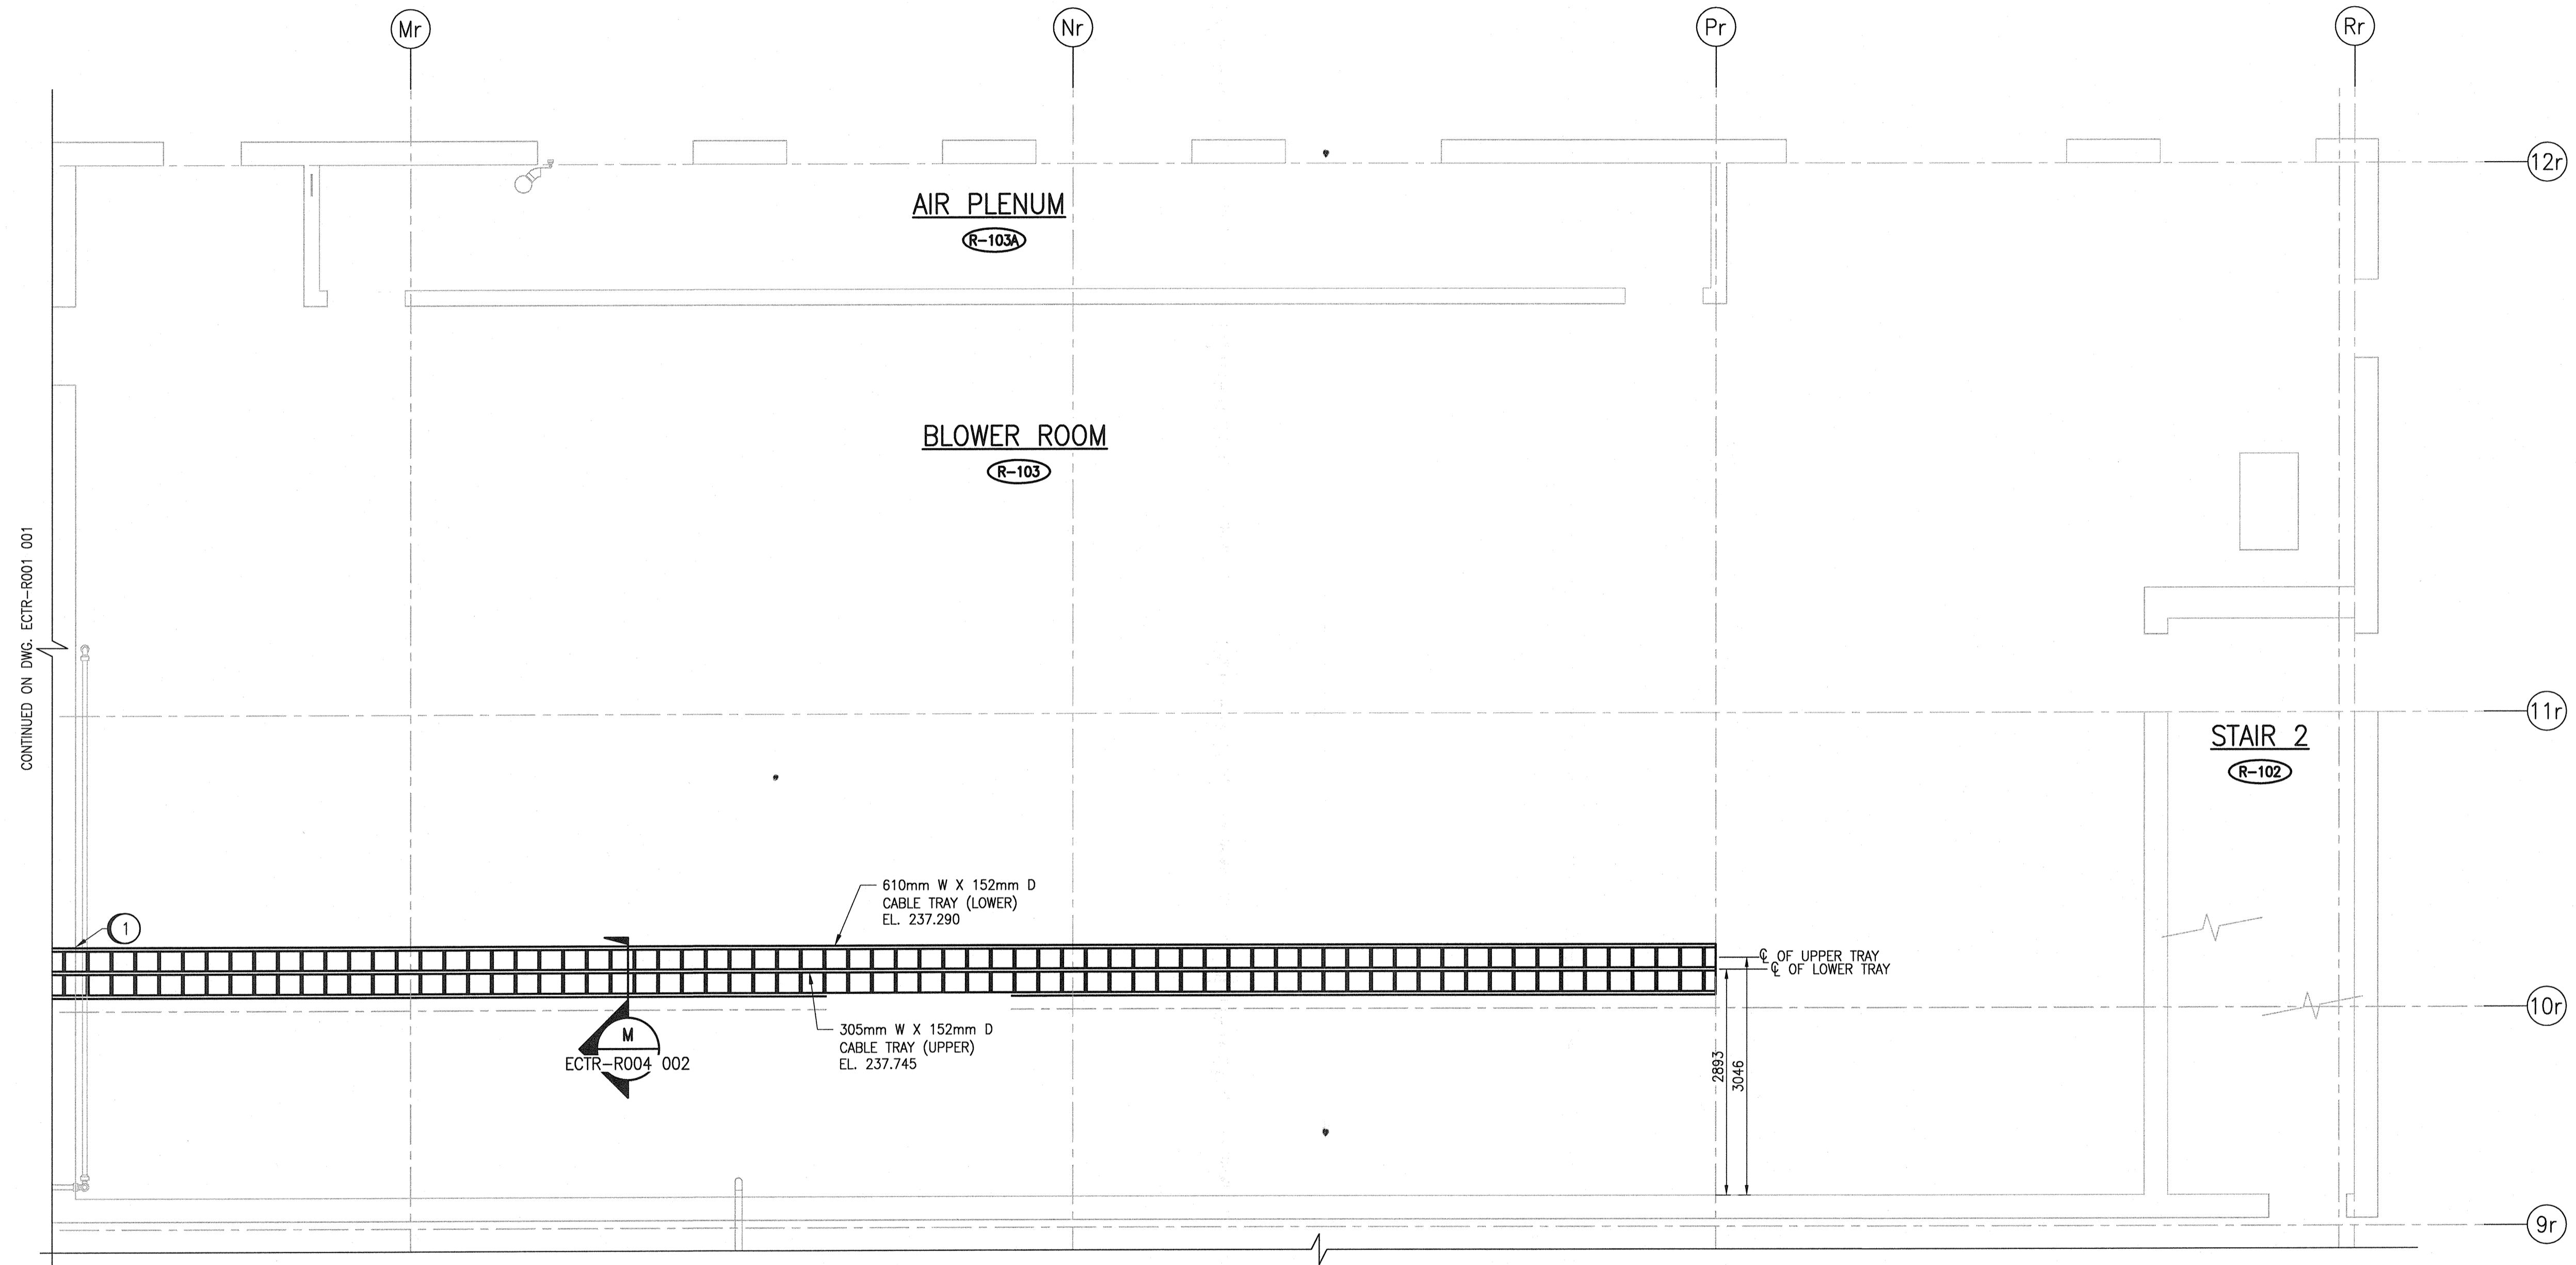


GENERAL NOTES:

1. REFER TO DWG. ECTR-R001 001 FOR GENERAL NOTES.
2. NOT ALL CABLE TRAYS ARE SHOWN ON THIS DRAWING FOR CLARITY. REFER TO DWG. ECTR-R001 004 FOR ADDITIONAL CABLE TRAY LAYOUT.

SPECIFIC NOTES:



- 1 PROVIDE FIRE RATED ASSEMBLY AND SEAL ALL CABLES PENETRATING THE WALL / FLOOR TO SEPARATE THE AREAS.

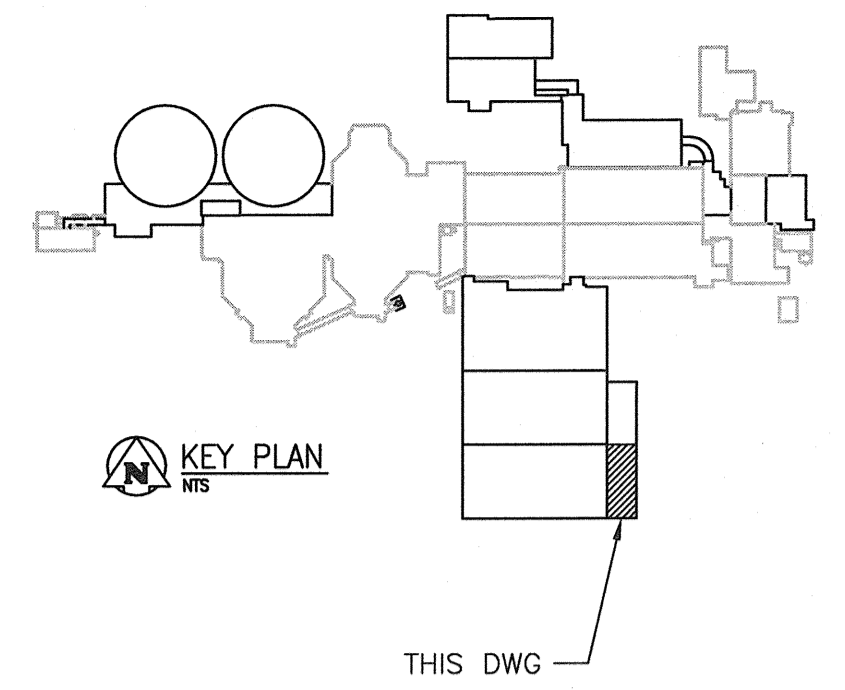

PARTIAL GROUND FLOOR PLAN

SCALE: 1 : 50

1-0102-ECTR-R004	CABLE TRAY DETAILS
REFERENCE DRAWINGS	DESCRIPTION

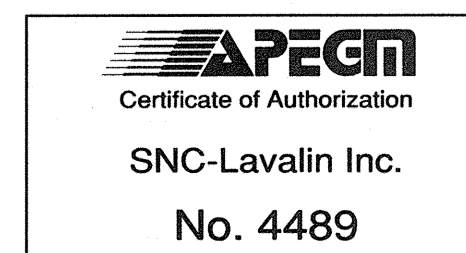 

00	ISSUED FOR TENDER - B.O. 899-2015	01/2016	SLJ	DEB
NO.	REVISIONS	DATE	DESIGN	CHECK

CH2MHILL.
 SNC-Lavalin

DESIGNED BY: S. JUGANAS
 CHECKED BY: D. BECKER

DRAWN BY: S. JUGANAS
 APPROVED BY: E. RYCKOWSKI

SCALE: 1:50
 ISSUED FOR CONSTRUCTION BY: T. TURZAK

DATE: 2015/08/25
 DATE: 2016/01/29

CONSULTANT NO.: 474248

ENGINEER'S SEAL
 PROVINCE OF MANITOBA
 E. M. RYCKOWSKI
 Member 4771
 REGISTERED PROFESSIONAL ENGINEER
 2016/01/29

THE CITY OF WINNIPEG
 WATER AND WASTE DEPARTMENT

SOUTH END WATER POLLUTION CONTROL CENTRE
 SEWPCC UPGRADING/EXPANSION PROJECT
 ELECTRICAL - CABLE TRAY LAYOUT
 BIOREACTORS/BLOWER BUILDING
 GROUND FLOOR PLAN

CITY DRAWING NUMBER: 1-0102-ECTR-R001 002

SHEET	REV.	SIZE
002	00	A1