 



ROOF PLAN



- NOTES:
 1. ALL RAIN WATER LEADERS ARE 150 DIAMETER, UNLESS NOTED OTHERWISE.
 ALL RAIN WATER LEADERS ARE INSTALLED AT 1% SLOPE.

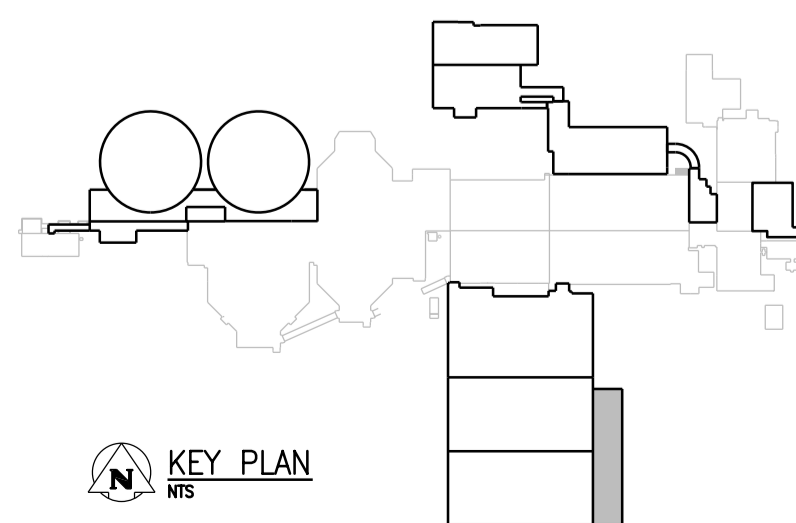

00	ISSUED FOR TENDER - B.O. 899-2015	01/2016	P.K.	J.C.
NO.	REVISIONS	DATE	DESIGN	CHECK

CH2MHILL	
SNC-LAVALIN	
DESIGNED BY: T. TRAN	CHECKED BY: D. LE
DRAWN BY: P. KWONG	APPROVED BY: H.T. FREIHAMMER
SCALE: 1:100	ISSUED FOR CONSTRUCTION BY: T. TURZAK
DATE: 2016/01/29	DATE: 2016/01/29
CONSULTANT NO.: 474248	



THE CITY OF WINNIPEG WATER AND WASTE DEPARTMENT		
SOUTH END WATER POLLUTION CONTROL CENTRE SEWPCC UPGRADING/EXPANSION PROJECT MECHANICAL BIOREACTOR/BLOWER BUILDING PLUMBING - ROOF PLAN		
CITY DRAWING NUMBER 1-0102-MGAD-R509	SHEET 001	REV. 00
		SIZE A1