



OVERALL GROUND FLOOR PLAN
1:200

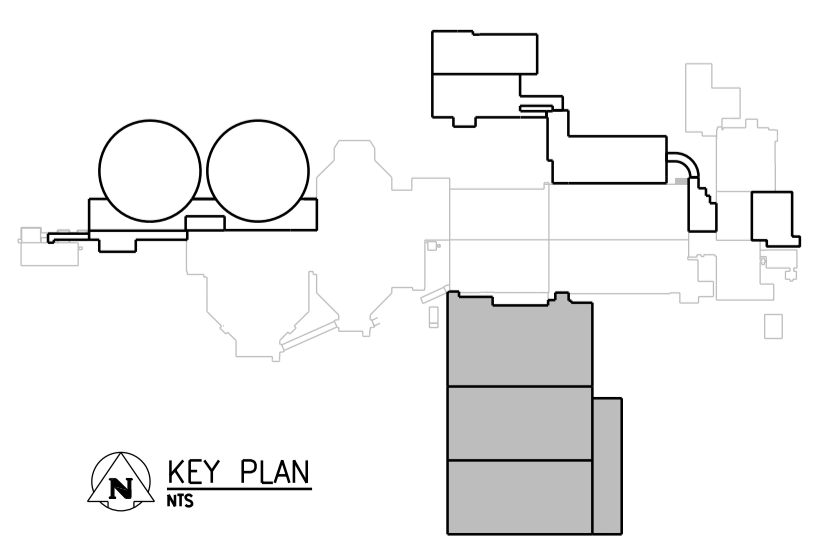

APEGM
Certificate of Authorization
CH2M HILL Canada Ltd.
No. 1441

NO.	REVISIONS	DATE	DESIGN	CHECK
00	ISSUED FOR TENDER - B.O. 899-2015	01/2016	A.B.	J.C.

CH2MHILL	
DESIGNED BY: D. LE	CHECKED BY: T. TRAN
DRAWN BY: A. BERSHTEIN	APPROVED BY: H.T. FREIHAMMER
SCALE: 1:200	ISSUED FOR CONSTRUCTION BY: T. TURZAK
DATE: 2016/01/29	DATE: 2016/01/29
CONSULTANT NO.: 474248	

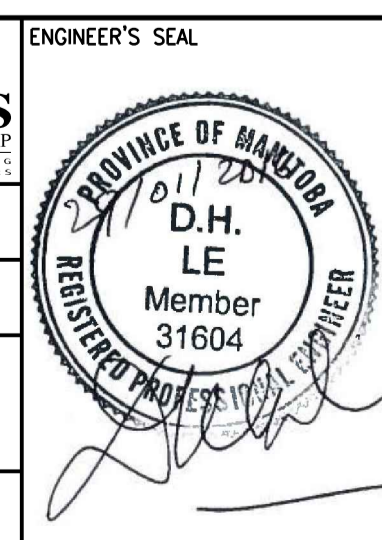

THE CITY OF WINNIPEG
Winnipeg WATER AND WASTE DEPARTMENT

SOUTH END WATER POLLUTION CONTROL CENTRE
SEWPCC UPGRADING/EXPANSION PROJECT
MECHANICAL
BIOREACTOR/BLOWER BUILDING
HVAC - OVERALL GROUND FLOOR PLAN

CITY DRAWING NUMBER: 1-0102-MGAD-R607 | SHEET: 001 | REV: 00 | SIZE: A1