
 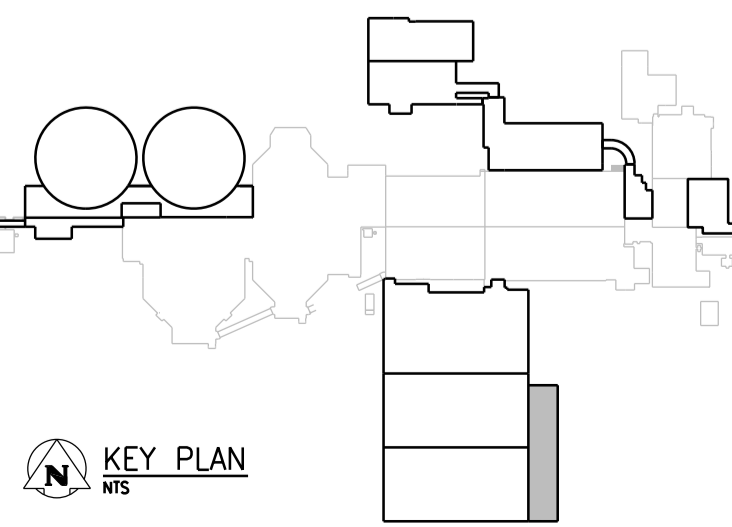


NOTES:
1. REFER TO DUCT SCHEDULE FOR MATERIAL

GROUND FLOOR PART - PLAN B

1:50




NO.	REVISIONS	DATE	DESIGN	CHECK
00	ISSUED FOR TENDER - B.O. 899-2015	01/2016	A.B.	J.C.

CH2MHILL
SNC-LAVALIN

DESIGNED BY: D. LE
DRAWN BY: A. BERSHTEIN
SCALE: 1:50
DATE: 2016/01/29

CHECKED BY: T. TRAN
APPROVED BY: H.T. FREIHAMMER
ISSUED FOR CONSTRUCTION BY: T. TURZAK
DATE: 2016/01/29

CONSULTANT NO.: 474248

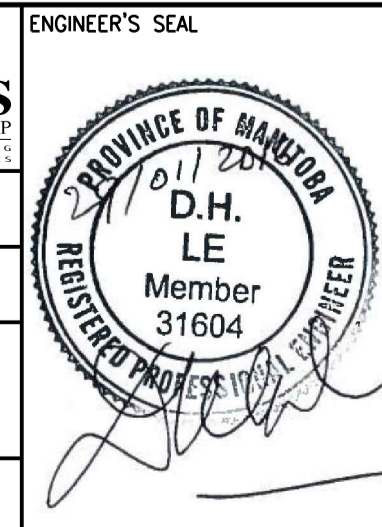

THE CITY OF WINNIPEG
Winnipeg WATER AND WASTE DEPARTMENT

SOUTH END WATER POLLUTION CONTROL CENTRE
SEWPPC UPGRADING/EXPANSION PROJECT
MECHANICAL
BIOREACTOR/BLOWER BUILDING
HVAC - GROUND FLOOR PLAN - PART B

CITY DRAWING NUMBER: 1-0102-MGAD-R609
SHEET: 001
REV: 00
SIZE: A1