
 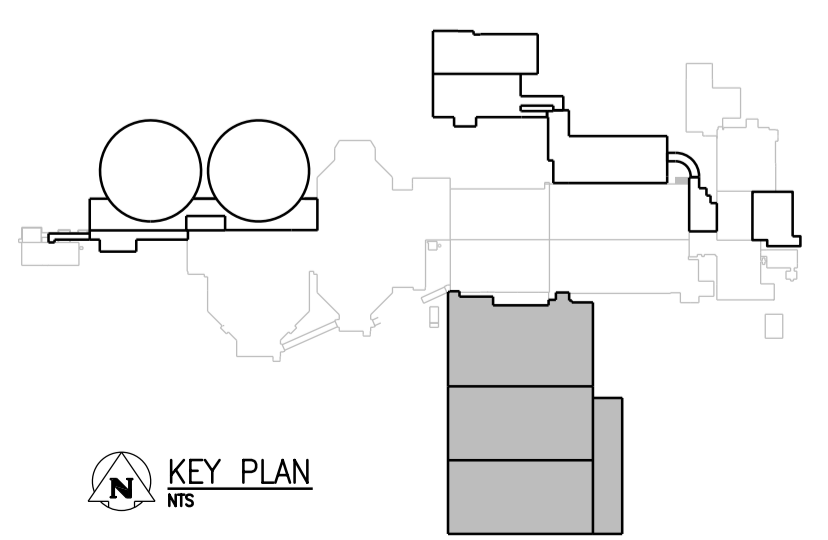


**OVERALL GROUND FLOOR PLAN**  
1:200



**APEGM**  
Certificate of Authorization  
CH2M HILL Canada Ltd.  
No. 1441

NO.	REVISIONS	DATE	DESIGN CHECK
00	ISSUED FOR TENDER - B.O. 899-2015	01/2016	A.B. J.C.

<b>CH2MHILL</b>		<b>KCS GROUP</b>	
SNC-LAVALIN		ENGINEER	
DESIGNED BY: R. BLACKWOOD	CHECKED BY: T. TRAN	ENGINEER'S SEAL	
DRAWN BY: B. COOPER	APPROVED BY: H.T. FREIHAMMER		
SCALE: 1:200	ISSUED FOR CONSTRUCTION BY: T. TURZAK		
DATE: 2016/01/29	DATE: 2016/01/29	CONSULTANT NO.: 474248	

**THE CITY OF WINNIPEG**  
Winnipeg WATER AND WASTE DEPARTMENT

SOUTH END WATER POLLUTION CONTROL CENTRE  
SEWPC UPGRADING/EXPANSION PROJECT  
MECHANICAL  
BIOREACTOR/BLOWER BUILDING  
FOA - OVERALL GROUND FLOOR PLAN

CITY DRAWING NUMBER: 1-0102-MGAD-R621 | SHEET: 001 | REV: 00 | SIZE: A1