


GROUND FLOOR PLAN - PART A


1:100
0 1000 2000 3000 4000 5000

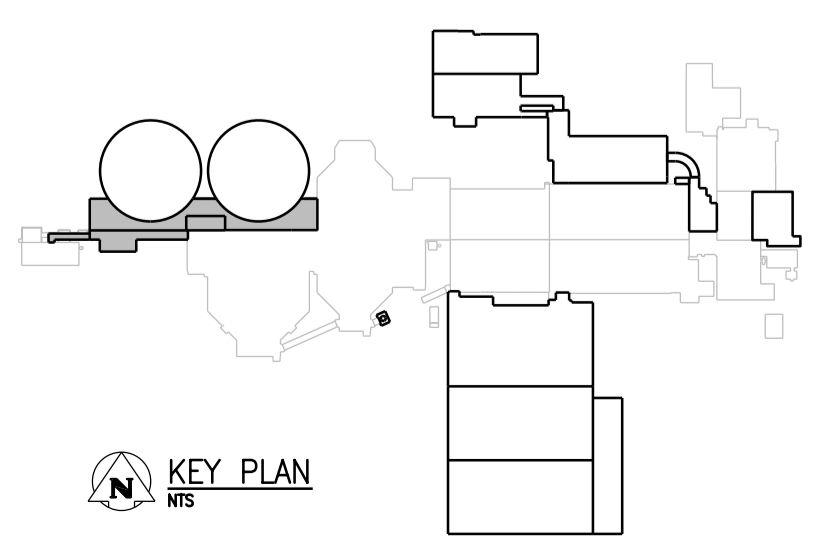

APEGM
 Certificate of Authorization
 CH2M HILL Canada Ltd.
 No. 1441

NO.	REVISIONS	DATE	DESIGN	CHECK
00	ISSUED FOR TENDER - B.O. 899-2015	01/2016	P.K.	T.T.

CH2MHILL	
DESIGNED BY: T. TRAN	CHECKED BY: D. LE
DRAWN BY: P. KWONG	APPROVED BY: H.T. FREIHAMMER
SCALE: 1:100	ISSUED FOR CONSTRUCTION BY: T. TURZAK
DATE: 2016/01/29	DATE: 2016/01/29
CONSULTANT NO.: 474248	

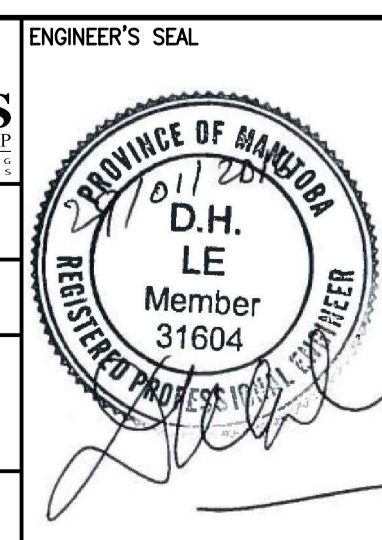

THE CITY OF WINNIPEG WATER AND WASTE DEPARTMENT		
SOUTH END WATER POLLUTION CONTROL CENTRE SEWPCC UPGRADING/EXPANSION PROJECT MECHANICAL SECONDARY CLARIFIERS 4 AND 5 PLUMBING - GROUND FLOOR PLAN - PART A		
CITY DRAWING NUMBER 1-0102-MGAD-S505	SHEET 001	REV. 00
		SIZE A1