


ROOF PLAN
1:100

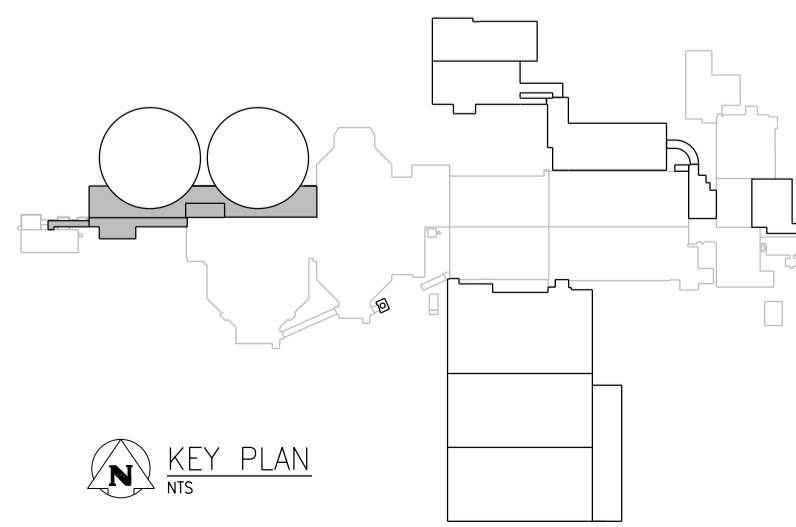

APEGM
Certificate of Authorization
CH2M HILL Canada Ltd.
No. 1441


NO.	REVISIONS	DATE	DESIGN	CHECK
00	ISSUED FOR TENDER - B.O. 899-2015	01/2016	P.K.	I.T.

CH2MHILL.
SNC-LAVALIN

DESIGNED BY: T. TRAN
DRAWN BY: P. KWONG
SCALE: 1:100
DATE: 2016/01/29

CHECKED BY: D. LE
APPROVED BY: H.T. FREIHAMMER
ISSUED FOR CONSTRUCTION BY: T. TURZAK
DATE: 2016/01/29

CONSULTANT NO.: 474248

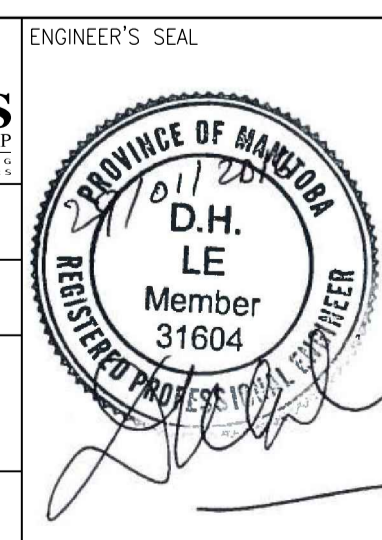

THE CITY OF WINNIPEG
Winnipeg WATER AND WASTE DEPARTMENT

SOUTH END WATER POLLUTION CONTROL CENTRE
SEWPCC UPGRADING/EXPANSION PROJECT
PLUMBING
SECONDARY CLARIFIERS 4 AND 5
PLUMBING - ROOF PLAN

CITY DRAWING NUMBER: 1-0102-MGAD-S507
SHEET: 001
REV.: 00
SIZE: A1