
 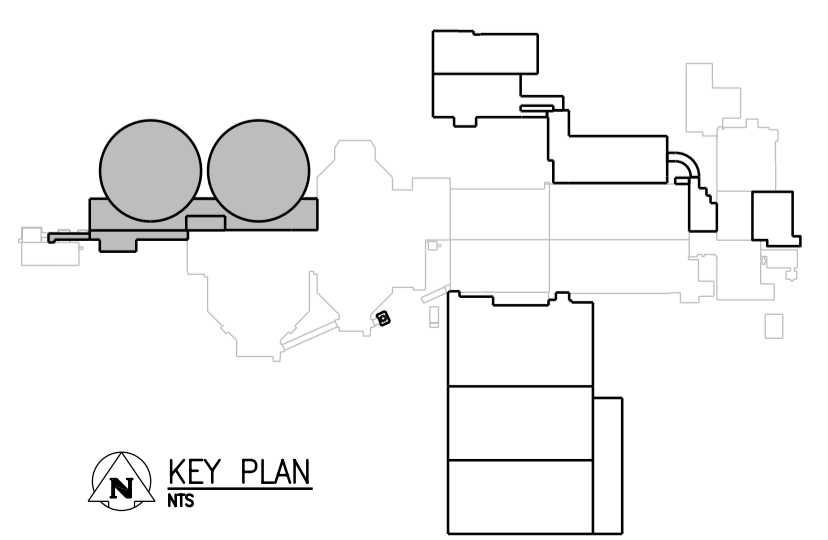



**OVERALL GROUND FLOOR PLAN**  
1:200



**APEGM**  
Certificate of Authorization  
CH2M HILL Canada Ltd.  
No. 1441

NO.	REVISIONS	DATE	DESIGN	CHECK
00	ISSUED FOR TENDER - B.O. 899-2015	01/2016	A.B.	T.T.

<b>CH2MHILL</b>	
DESIGNED BY: D. LE	CHECKED BY: T. TRAN
DRAWN BY: A. BERSHTEIN	APPROVED BY: H.T. FREIHAMMER
SCALE: 1:200	ISSUED FOR CONSTRUCTION BY: T. TURZAK
DATE: 2016/01/29	DATE: 2016/01/29
CONSULTANT NO.: 474248	

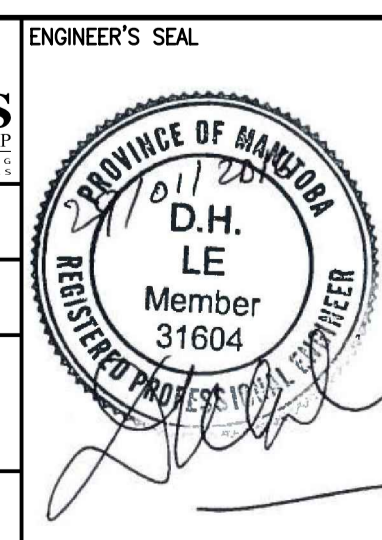

**THE CITY OF WINNIPEG**  
Winnipeg WATER AND WASTE DEPARTMENT

SOUTH END WATER POLLUTION CONTROL CENTRE  
SEWPCC UPGRADING/EXPANSION PROJECT  
MECHANICAL  
SECONDARY CLARIFIERS 4 AND 5  
HVAC - OVERALL GROUND FLOOR PLAN

CITY DRAWING NUMBER: 1-0102-MGAD-S605 | SHEET: 001 | REV.: 00 | SIZE: A1