
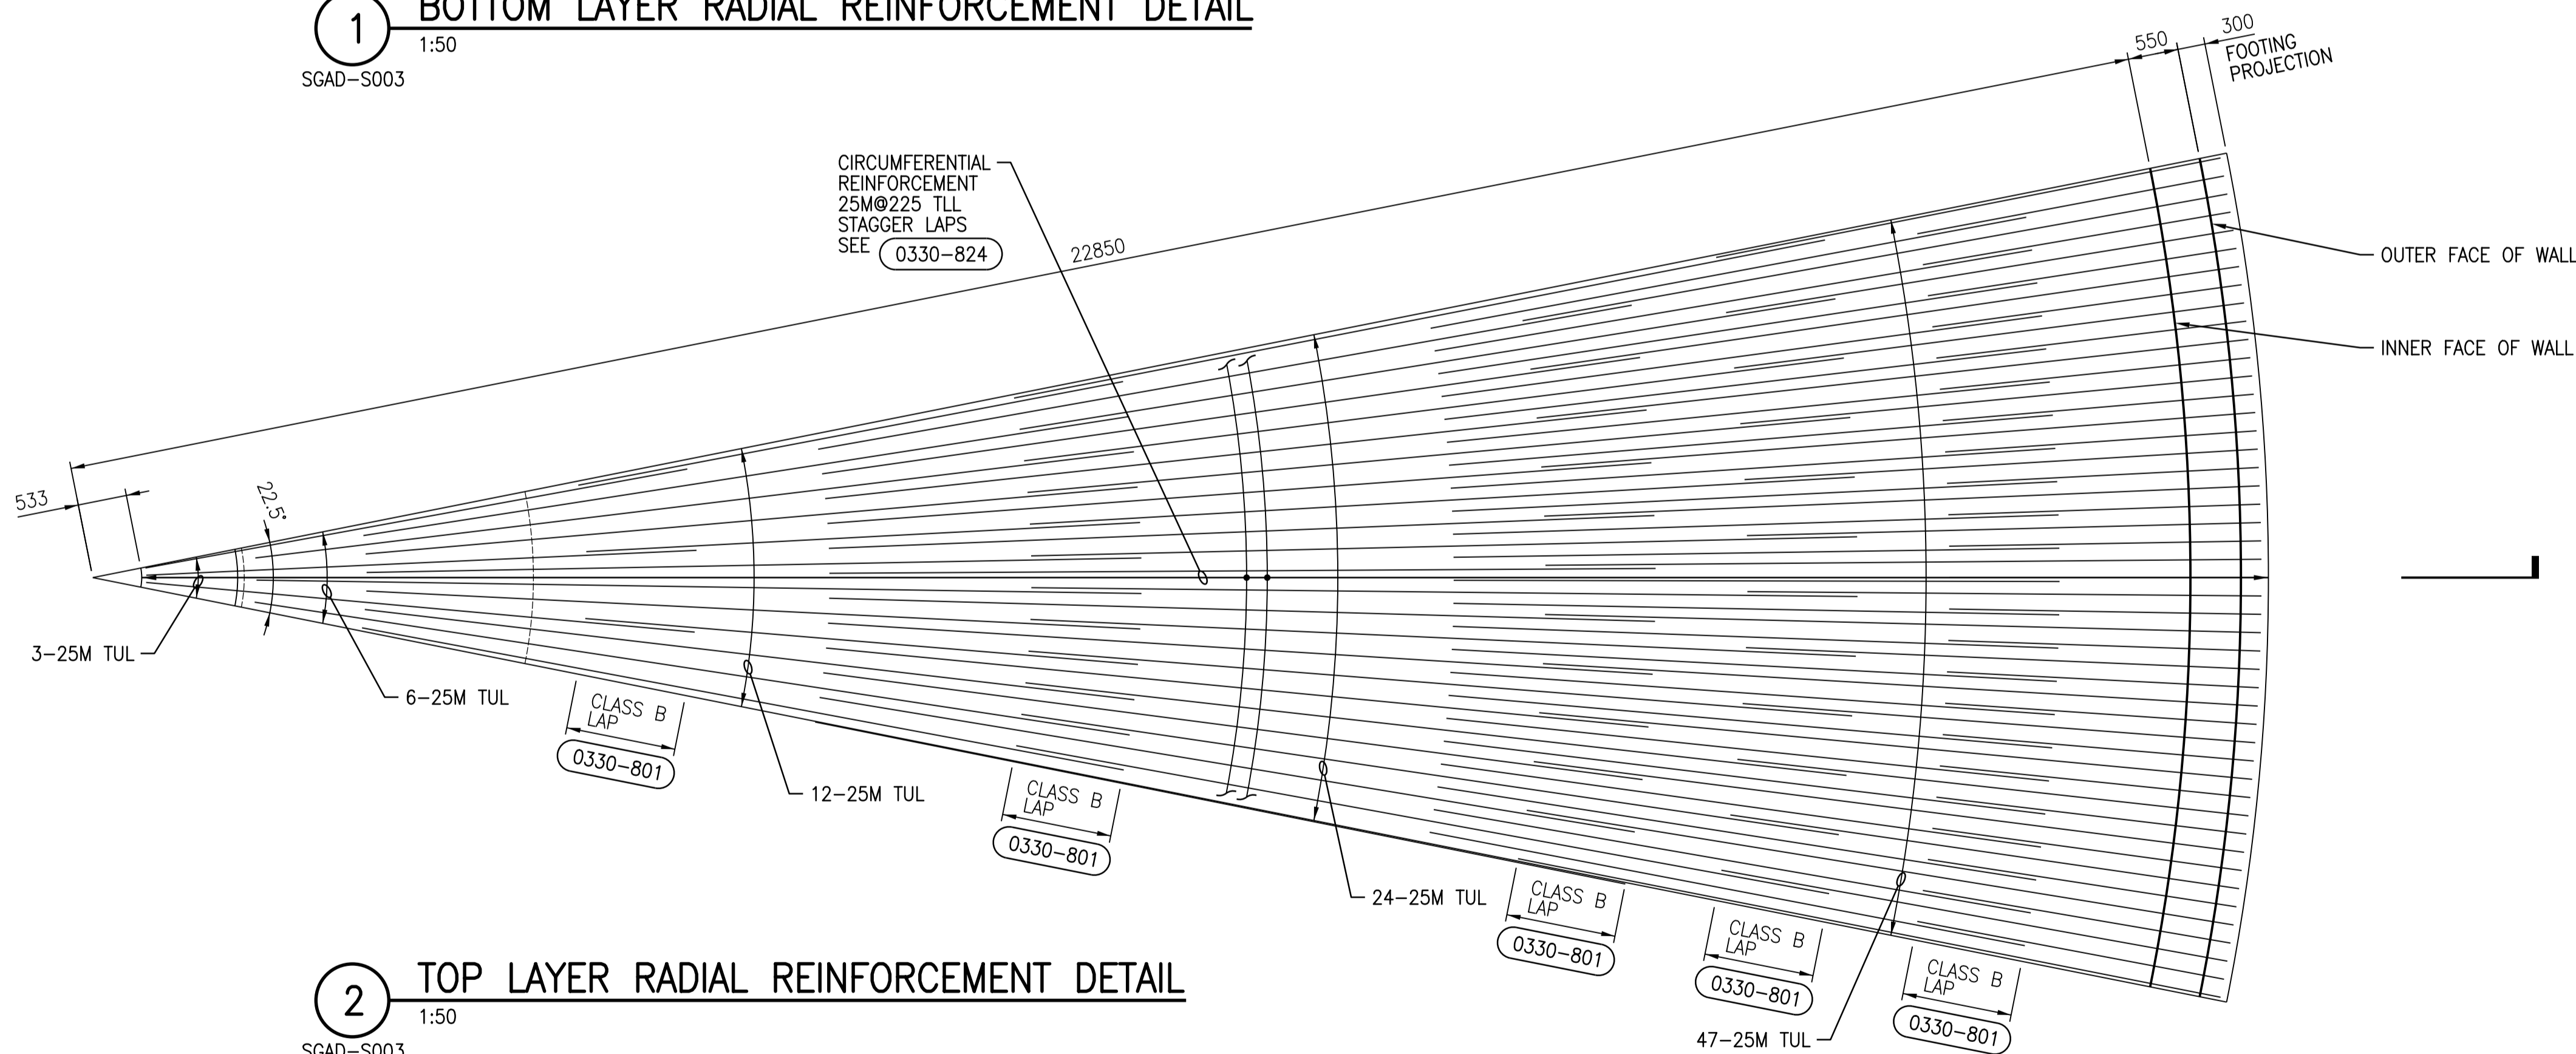
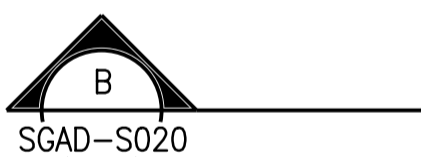


1 BOTTOM LAYER RADIAL REINFORCEMENT DETAIL
1:50
SGAD-S003

GENERAL NOTES:

1. READ THIS DRAWING IN CONJUNCTION WITH SECTION  FOR THE REINFORCEMENT NOT SHOWN.
2. THE 1/16TH PORTION (22.5°) SHOWS PART REINFORCEMENT. THE SAME REINFORCEMENT IS APPLICABLE ALL AROUND FOR BOTH CLARIFIER BASE SLABS (360°).



2 TOP LAYER RADIAL REINFORCEMENT DETAIL
1:50
SGAD-S003




NO.	REVISIONS	DATE	DESIGN	CHECK
00	ISSUED FOR TENDER - B.O. 899-2015	01/2016	G.O.	J.C.

CH2MHILL
SNC-LAVALIN

DESIGNED BY: A THAKKAR
DRAWN BY: G. OMORI
SCALE: 1:50
DATE: 2016/01/29

CHECKED BY: R. PARIKH
APPROVED BY: H.T. FREIHAMMER
ISSUED FOR CONSTRUCTION BY: T. TURZAK
DATE: 2016/01/29

CONSULTANT NO.: 474248

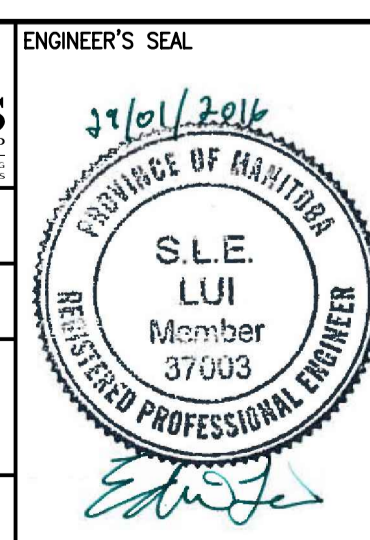

THE CITY OF WINNIPEG
Winnipeg WATER AND WASTE DEPARTMENT

SOUTH END WATER POLLUTION CONTROL CENTRE
SEWPC UPGRADING/EXPANSION PROJECT
STRUCTURAL
SECONDARY CLARIFIERS 4 AND 5
DETAILS

CITY DRAWING NUMBER: 1-0102-SDTL-S002
SHEET: 001
REV: 00
SIZE: A1