

SECONDARY CLARIFIER 4

METAL WALKWAY BRIDGE TO BE DESIGNED SUPPLIED AND INSTALLED BY EQUIPMENT SUPPLIER, TYP SEE SPECIFICATIONS

THE WALKWAY BRIDGE TO BE ATTACHED TO TOP OF WALL. COORDINATE ANCHOR BOLTS DETAILS WITH EQUIPMENT SUPPLIER, BOTH ENDS, TYP

CONNECT THE FUTURE AL DOME ON TOP OF WALL, TYP

TOP MOUNTED AL RAILING ALL AROUND CLARIFIER, TYP SEE XX SGAD-S???

TOP OF WALL EL. 233.180

EFFLUENT LAUNDER SLAB

EFFLUENT LAUNDER WALL

550
300
850

 
R 22850

FOR CONT SEE DWG SGAD-S012


FOR CONT SEE DWG SGAD-S015

GROUND FLOOR PLAN

1:125



APEGM
Certificate of Authorization
CH2M HILL Canada Ltd.
No. 1441

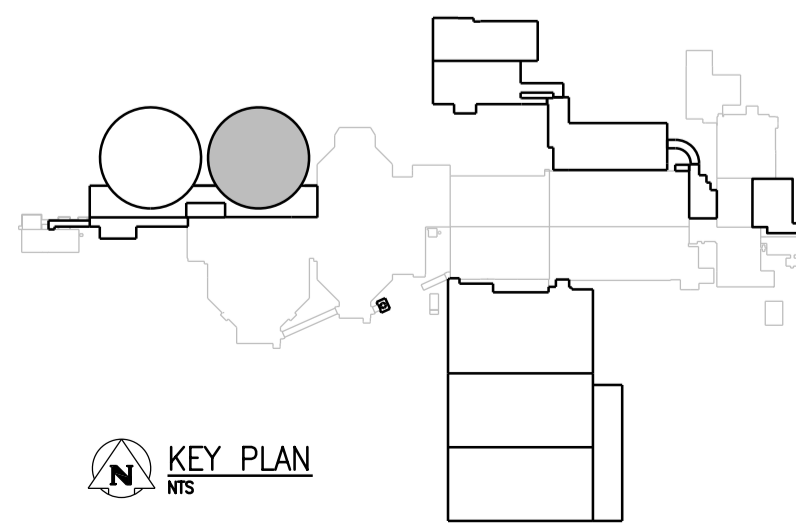

NO.	REVISIONS	DATE	DESIGN	CHECK
00	ISSUED FOR TENDER - B.O. 899-2015	01/2016	G.O.	J.C.

CH2MHILL		KCS GROUP	
DESIGNED BY: A. THAKKAR	CHECKED BY: E. LUI	ENGINEER'S SEAL	
DRAWN BY: G. OMORI	APPROVED BY: H.T. FREIHAMMER		
SCALE: 1:125	ISSUED FOR CONSTRUCTION BY: T. TURZAK		
DATE: 2016/01/29	DATE: 2016/01/29	CONSULTANT NO.: 474248	

31/01/2016
PROVINCE OF MANITOBA
S.L.E. LUI
Member 37003
REGISTERED PROFESSIONAL ENGINEER

THE CITY OF WINNIPEG
Winnipeg WATER AND WASTE DEPARTMENT

SOUTH END WATER POLLUTION CONTROL CENTRE
SEWPCC UPGRADING/EXPANSION PROJECT
STRUCTURAL
SECONDARY CLARIFIER 4
GROUND FLOOR PLAN

CITY DRAWING NUMBER	SHEET	REV.	SIZE
1-0102-SGAD-S013	001	00	A1