


1 MAIN FLOOR PLAN - DEMOLITION - VENTILATION
SCALE: 1/16" = 1'-0"

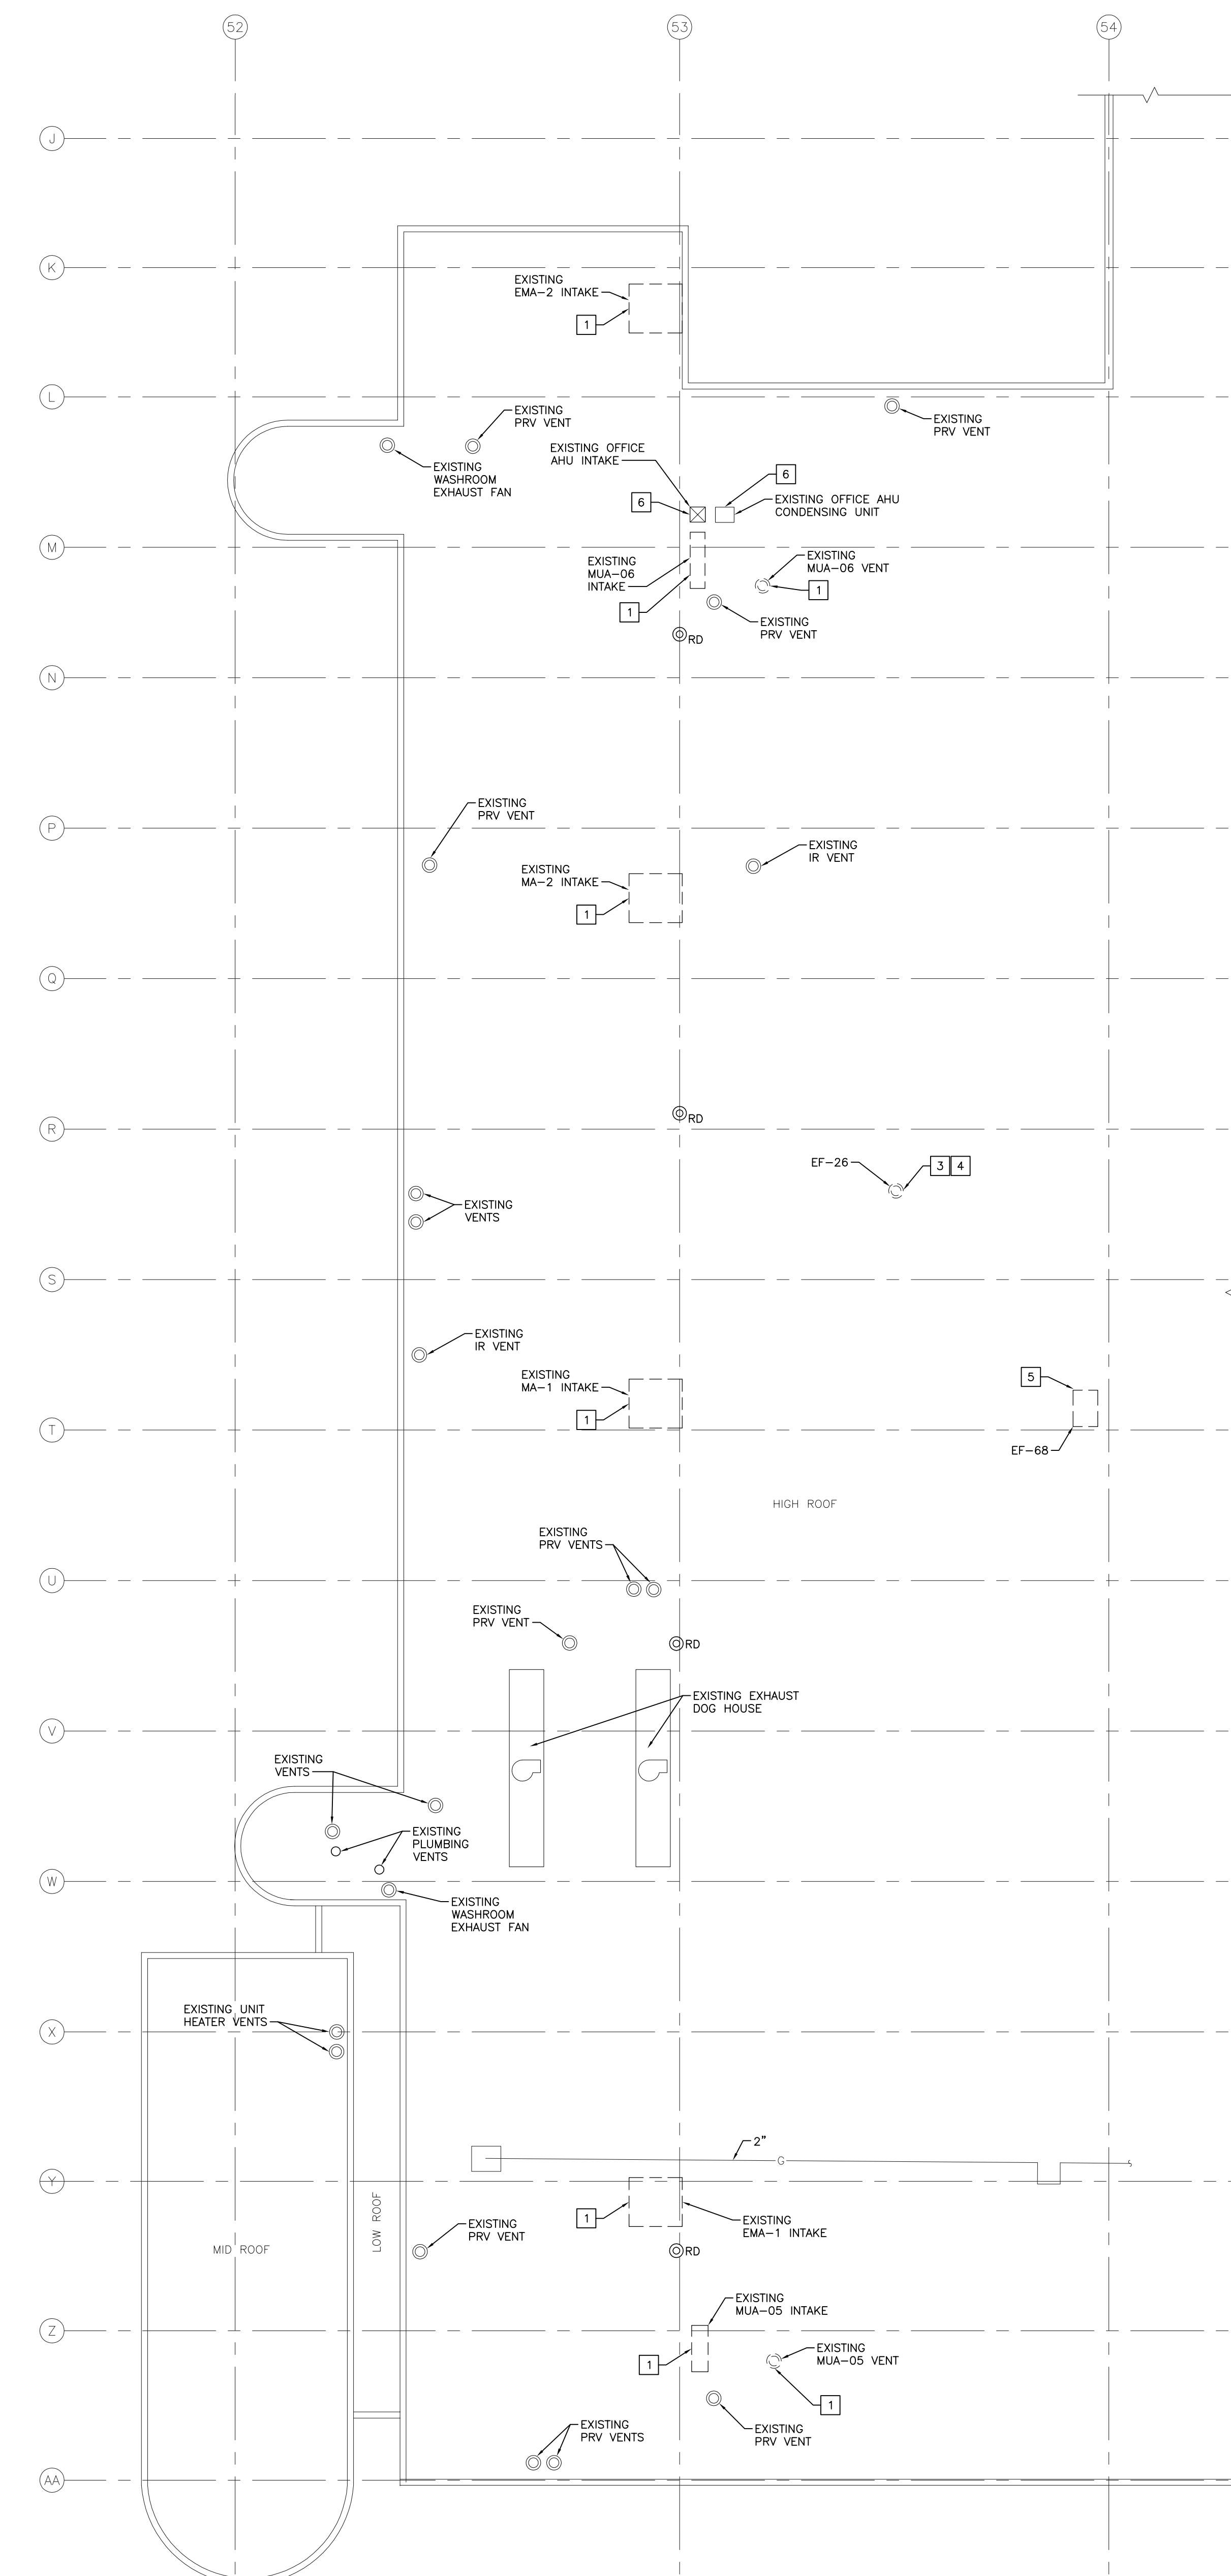


2 ROOF PLAN - DEMOLITION - VENTILATION
SCALE: 1/16" = 1'-0"

GENERAL NOTES

- A. REFER TO SCOPE OF WORK DESCRIPTION IN FRONT END SPECIFICATIONS FOR SEQUENCING.
- B. ALL ABANDONED EQUIPMENT AND SERVICES WITHIN AREA OF WORK SHALL BE REMOVED.
- C. THIS BUILDING MAY CONTAIN ASBESTOS. REFER TO FRONT END SPECIFICATIONS FOR FURTHER INFORMATION.

DEMOLITION KEYNOTES

- 1. DEMOLISH AND REMOVE EXISTING MUA'S AND ASSOCIATED DUCTWORK VENTING AND INTAKES. REPAIR AND SEAL ROOF OPENING (REFER TO STRUCTURAL). REMOVED EXISTING CONTROLLERS AND RETURN TO OWNER FOR SPARES. REMOVE DEMOLISHED UNITS FROM BAS.
- 2. DEMOLISH AND REMOVE EXISTING TRANSFER FAN, F-1 SILENCER AND DUCTWORK TO GRIDLINE 54. PATCH BLOCK WALL TO MATCH EXISTING. REMOVE DEMOLISHED FAN FROM BAS.
- 3. DEMOLISH AND REMOVE EXISTING EXHAUST FAN. REPAIR AND SEAL ROOF OPENING (REFER TO STRUCTURAL). REMOVE DEMOLISHED FAN FROM BAS.
- 4. EMA-1, MA-1, MA-2, EMA-2, MUA-05, MUA-06, EF-26 AND ASSOCIATED SYSTEMS SHALL BE DEMOLISHED AFTER SUBSTANTIAL PERFORMANCE OF NEW SYSTEMS HAS BEEN GRANTED.
- 5. DEMOLISH AND REMOVE EXISTING DUCTWORK AND ABANDONED FAN. REPAIR AND SEAL ROOF OPENING (REFER TO STRUCTURAL). REMOVE DEMOLISHED FAN FROM BAS.
- 6. EXISTING OFFICE AHU INTAKE AND CONDENSING UNIT TO REMAIN.
- 7. DEMOLISH AND REMOVE EXISTING CO AND NOX STAND ALONE SENSORS.
- 8. OPEN NUMBER
- 9. MAINTAIN EXISTING TRANSFER FAN, F-2.
- 10. MAINTAIN EXISTING 100% EXHAUST BUS INTERIOR CLEANER CYCLONE, CY-1 IS 17,900 CFM AND CY-2 IS 18,700 CFM BASED ON AIR MEASUREMENT TESTING CONDUCTED ON OCTOBER 1, 2014.

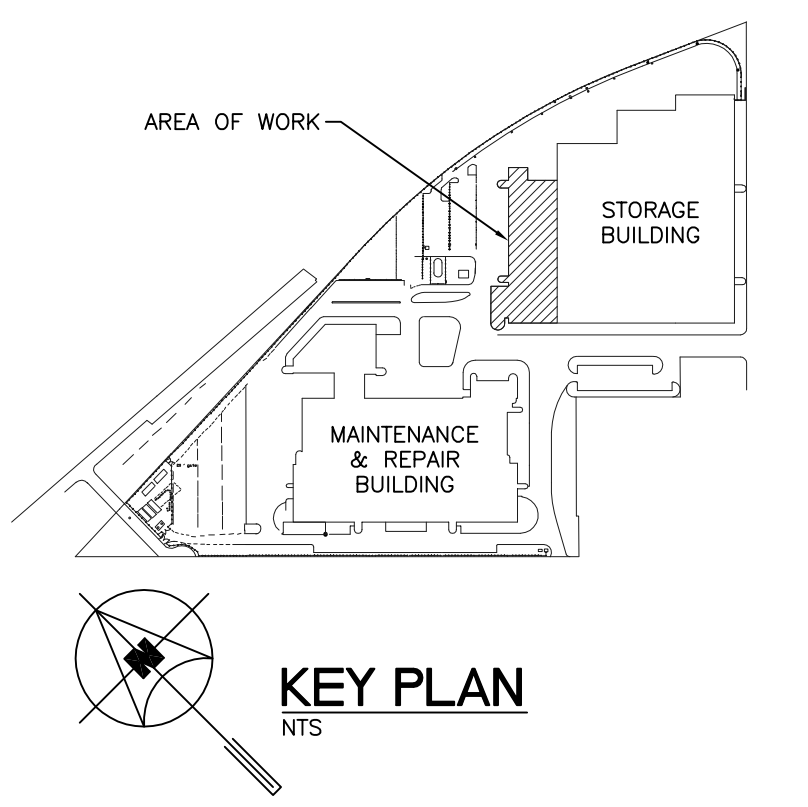

KEY PLAN
NTS

5			
4			
3			
2			
1	ISSUED FOR ADDENDUM 2	JH	20/11/15
0	ISSUED FOR CONSTRUCTION	JH	27/10/15
NO.	Description	BY	DD/MM/YY

APEGM
Certificate of Authorization
SMB Engineering Ltd.
No. 166 Expiry: April 30, 2016

ORIGINAL CONTRACT DRAWING
BONDED AND SEALED BY
J. T. HORROCKS, P. ENG
OCTOBER 27, 2015

770 Bradford Street
Winnipeg, Canada
T 204 775 0291
SMSeng.com

SMS ENGINEERING

Winnipeg Transit

Project Title
**CITY OF WINNIPEG FORT ROUGE
TRANSIT BASE - SERVICE BAY AND
B-SECTION VENTILATION UPGRADE**

WINNIPEG MANITOBA

Drawing Title
**MAIN FLOOR AND ROOF PLAN -
DEMOLITION - VENTILATION**

Drawn By	GB/IE	Checked By	JH	Approved By	JH
Scale	AS SHOWN	Date	JULY 2014	Project No	14-194-01
Revision Number	1	Drawing Number	M1.2	Sheet Order	2 OF 11