


1 MAIN FLOOR PLAN - DEMOLITION - VENTILATION  
SCALE: 1/16" = 1'-0"

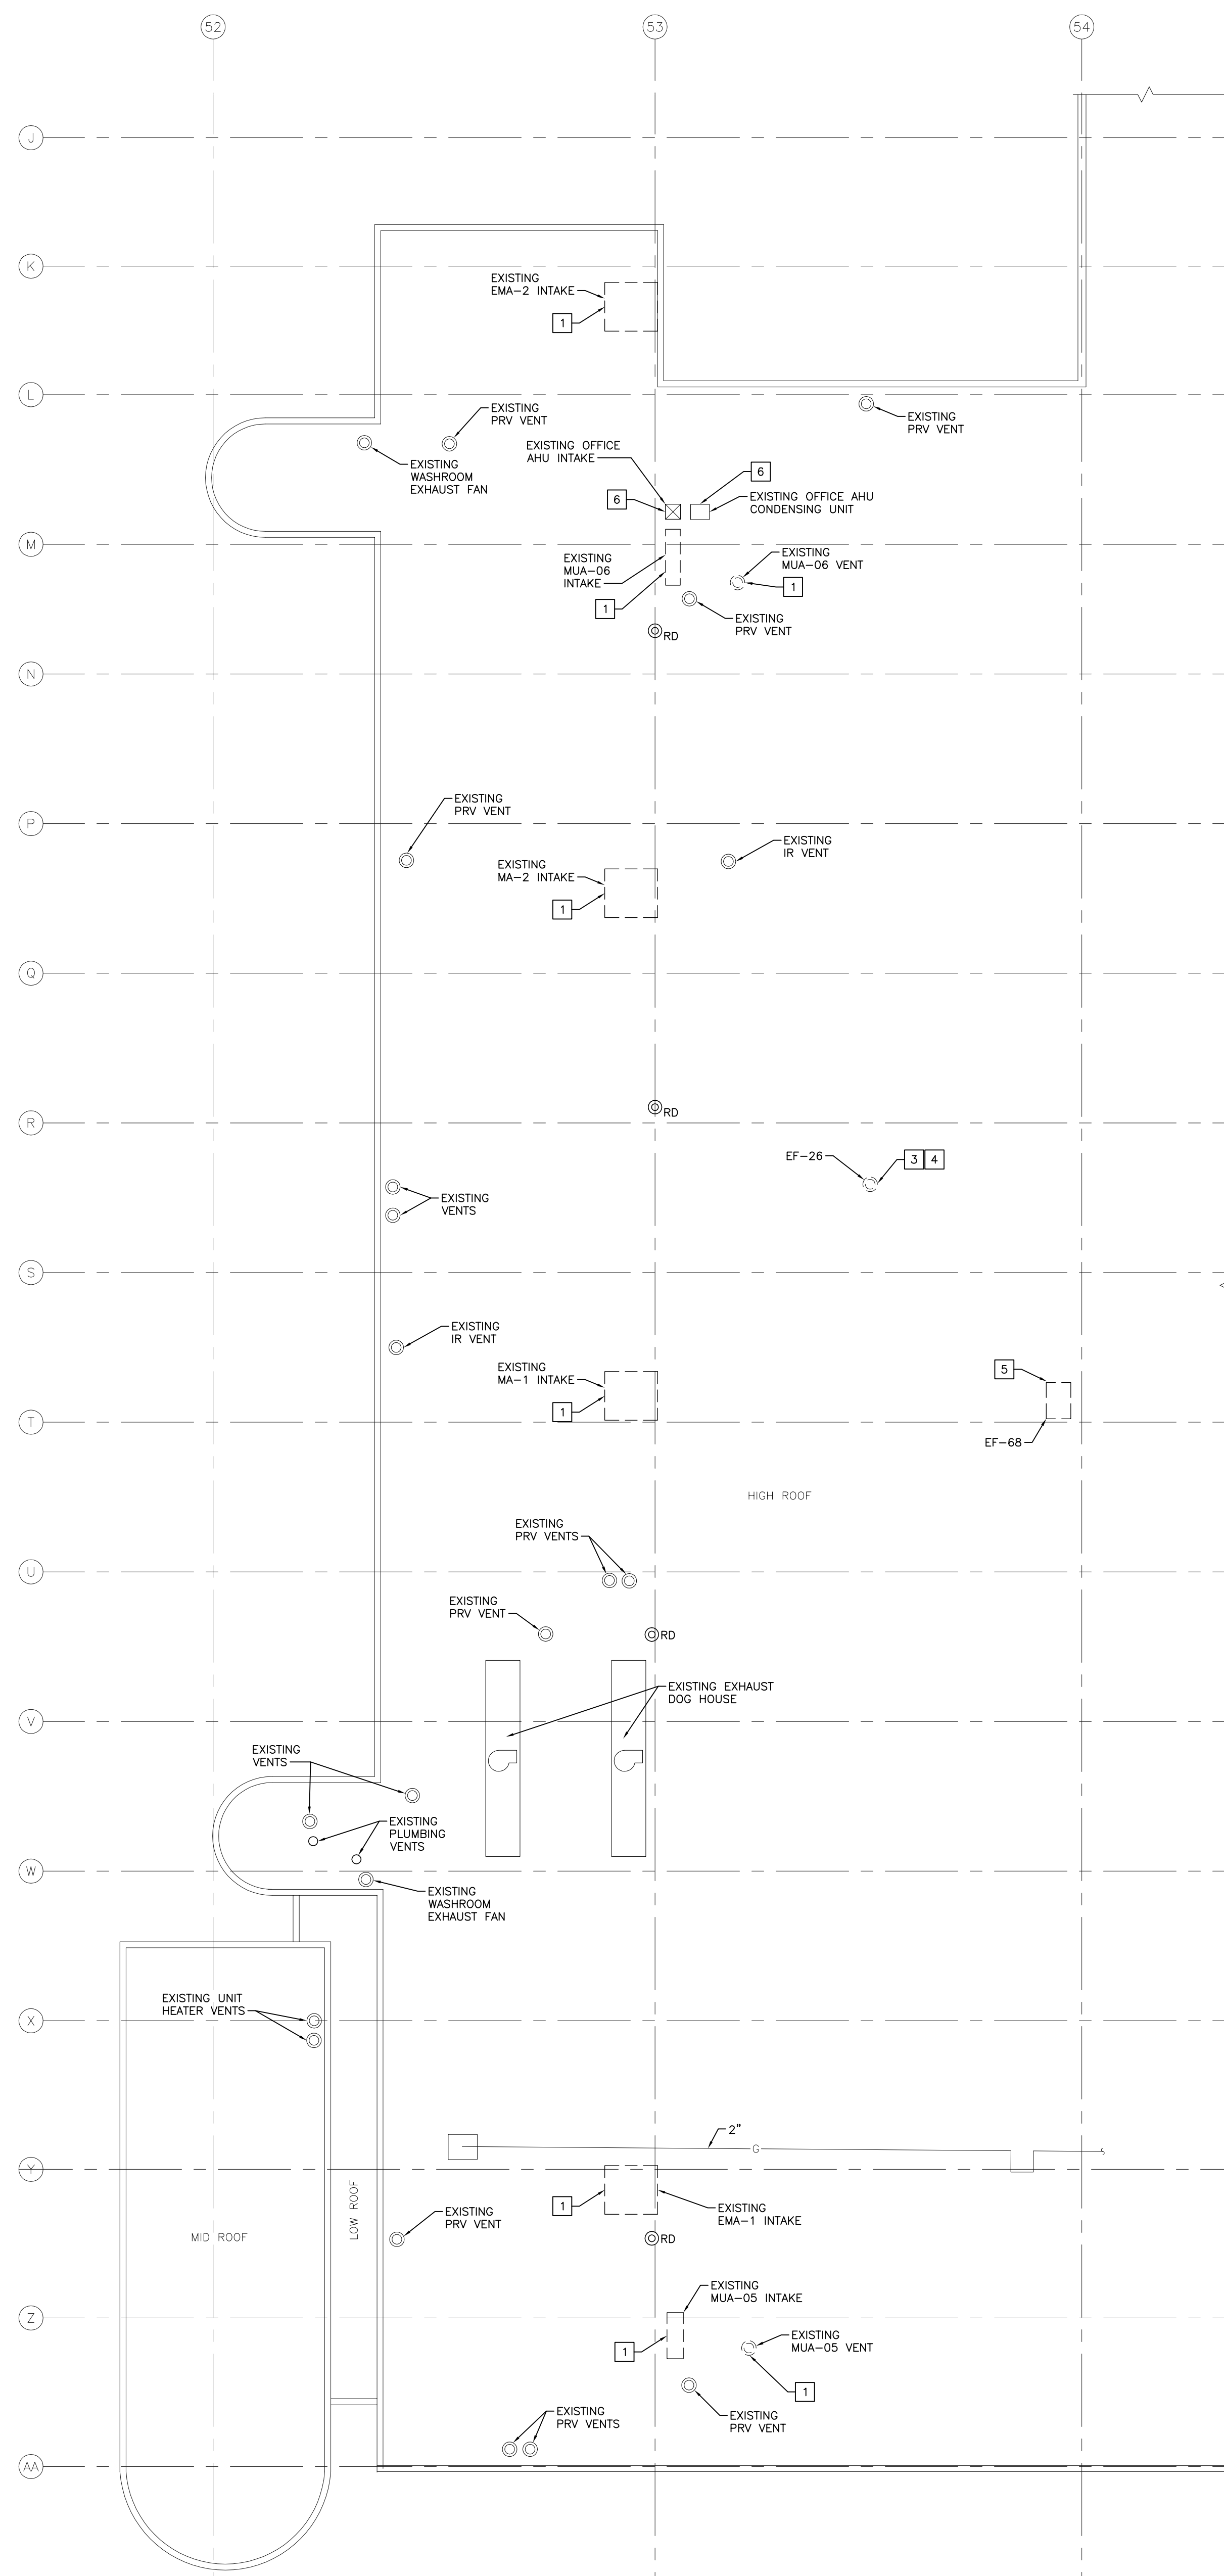


2 ROOF PLAN - DEMOLITION - VENTILATION  
SCALE: 1/16" = 1'-0"

**GENERAL NOTES**

- A. REFER TO SCOPE OF WORK DESCRIPTION IN FRONT END SPECIFICATIONS FOR SEQUENCING.
- B. ALL ABANDONED EQUIPMENT AND SERVICES WITHIN AREA OF WORK SHALL BE REMOVED.
- C. THIS BUILDING MAY CONTAIN ASBESTOS. REFER TO FRONT END SPECIFICATIONS FOR FURTHER INFORMATION.

**DEMOLITION KEYNOTES**

- 1. DEMOLISH AND REMOVE EXISTING MUA'S AND ASSOCIATED DUCTWORK VENTING AND INTAKES. REPAIR AND SEAL ROOF OPENING (REFER TO STRUCTURAL). REMOVED EXISTING CONTROLLERS AND RETURN TO OWNER FOR SPARES. REMOVE DEMOLISHED UNITS FROM BAS.
- 2. DEMOLISH AND REMOVE EXISTING TRANSFER FAN, F-1 SILENCER AND DUCTWORK TO GRIDLINE 54. PATCH BLOCK WALL TO MATCH EXISTING. REMOVE DEMOLISHED FAN FROM BAS.
- 3. DEMOLISH AND REMOVE EXISTING EXHAUST FAN. REPAIR AND SEAL ROOF OPENING (REFER TO STRUCTURAL). REMOVE DEMOLISHED FAN FROM BAS.
- 4. EMA-1, MA-1, MA-2, EMA-2, MUA-05, MUA-06, EF-26 AND ASSOCIATED SYSTEMS SHALL BE DEMOLISHED AFTER SUBSTANTIAL PERFORMANCE OF NEW SYSTEMS HAS BEEN GRANTED.
- 5. DEMOLISH AND REMOVE EXISTING DUCTWORK AND ABANDONED FAN. REPAIR AND SEAL ROOF OPENING (REFER TO STRUCTURAL). REMOVE DEMOLISHED FAN FROM BAS.
- 6. EXISTING OFFICE AHU INTAKE AND CONDENSING UNIT TO REMAIN.
- 7. DEMOLISH AND REMOVE EXISTING CO AND NOX STAND ALONE SENSORS.
- 8. FILL IN EXISTING OPENING WITH CONCRETE BLOCK TO MATCH EXISTING.
- 9. MAINTAIN EXISTING TRANSFER FAN, F-2.
- 10. MAINTAIN EXISTING 100% EXHAUST BUS INTERIOR CLEANER CYCLONE, CY-1 IS 17,980 CFM AND CY-2 IS 18,780 CFM BASED ON AIR MEASUREMENT TESTING CONDUCTED ON OCTOBER 1, 2014.

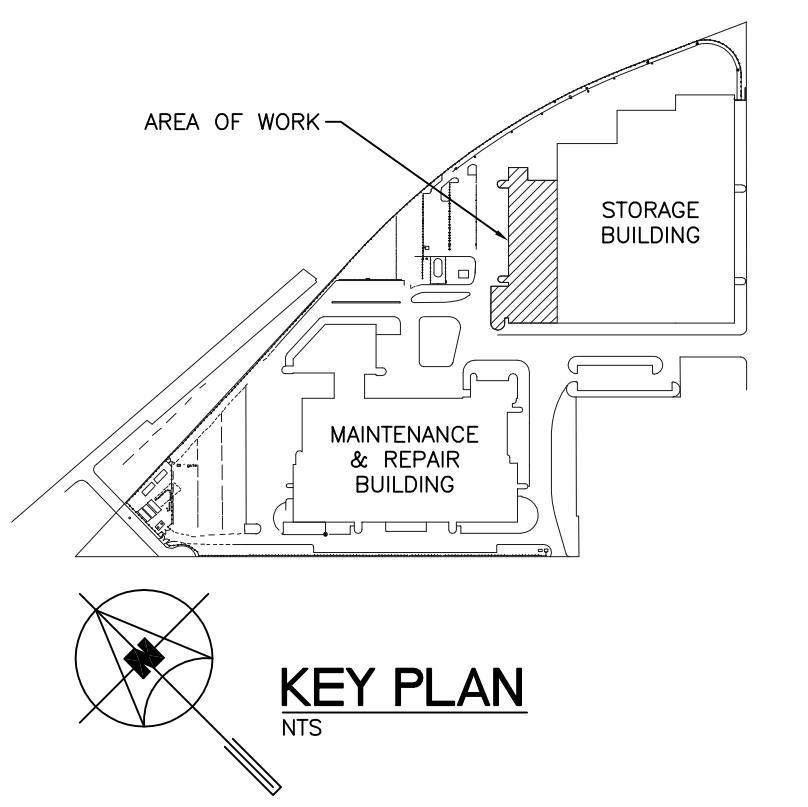

6			
5			
4			
3			
2			
1			
0	ISSUED FOR CONSTRUCTION	JH	27/10/15
NO.	Description	BY	DD/MM/YY

**APEN**  
Certificate of Authorization  
SMB Engineering Ltd.  
No. 166 Expiry: April 30, 2016

**HORROCKS**  
Member  
24767  
2/10/15  
REGISTERED PROFESSIONAL ENGINEER

770 Bradford Street  
Winnipeg, Canada  
T 204 775 0291  
SMSeng.com

**SMS ENGINEERING**

**Winnipeg Transit**

Project Title  
**CITY OF WINNIPEG FORT ROUGE  
TRANSIT BASE - SERVICE BAY AND  
B-SECTION VENTILATION UPGRADE**

WINNIPEG MANITOBA

Drawing Title  
**MAIN FLOOR AND ROOF PLAN -  
DEMOLITION - VENTILATION**

Drawn By GB/IE	Checked By JH	Approved By JH
Scale AS SHOWN	Date JULY 2014	Project No 14-194-01
Revision Number 0	Drawing Number M1.2	Sheet Order 2 OF 11

14196\_M1.2\_RFC\_L1.DWG - OCTOBER 27, 2015 - 9:22AM CST - 08AUL