


**GENERAL NOTES**

- A. REFER TO SCOPE OF WORK DESCRIPTION IN FRONT END SPECIFICATIONS FOR SEQUENCING.
- B. ALL ABANDONED EQUIPMENT AND SERVICES WITHIN AREA OF WORK SHALL BE REMOVED.
- C. THIS BUILDING MAY CONTAIN ASBESTOS. REFER TO FRONT END SPECIFICATIONS FOR FURTHER INFORMATION.
- D. THE SPRINKLER SYSTEM SHALL BE DESIGNED AND INSTALLED IN ACCORDANCE WITH NFPA 13, MANITOBA BUILDING CODE, MANITOBA FIRE CODE, LOCAL BUILDING BY-LAWS, THE AUTHORITY HAVING JURISDICTION, AND THE SPECIFICATIONS.

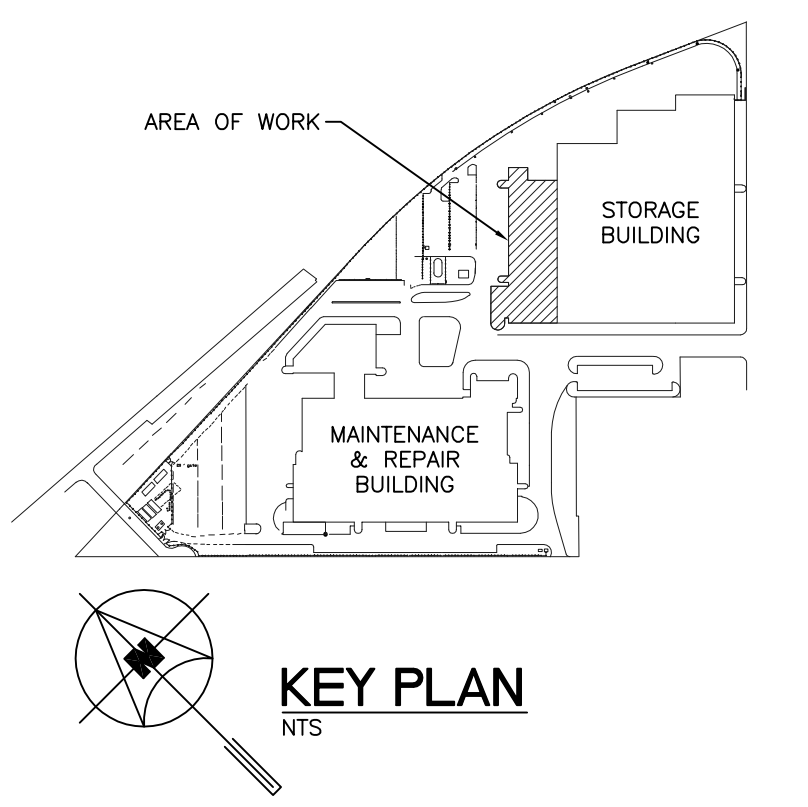

**KEYNOTES**

- 1. SPRINKLER SYSTEM AT HIGH LEVEL NOT SHOWN. PROVIDE NEW SPRINKLER HEADS UNDER NEW DUCTWORK AS REQUIRED.

6			
5			
4			
3			
2			
1			
0	ISSUED FOR CONSTRUCTION	JH	27/10/15
NO.	Description	BY	DD/MM/YY

**Certificate of Authorization**  
SMB Engineering Ltd.  
No. 166 Expiry: April 30, 2016


770 Bradford Street  
Winnipeg, Canada  
T 204 775-0291  
SMSeng.com

Project Title  
**CITY OF WINNIPEG FORT ROUGE  
TRANSIT BASE - SERVICE BAY AND  
B-SECTION VENTILATION UPGRADE**

WINNIPEG MANITOBA

Drawing Title  
**MAIN FLOOR PLAN - NEW  
CONSTRUCTION - FIRE  
PROTECTION**

Drawn By GB/IE	Checked By JH	Approved By JH
Scale AS SHOWN	Date JULY 2014	Project No 14-194-01
Revision Number <b>0</b>	Drawing Number <b>M3.1</b>	Sheet Order 6 OF 11

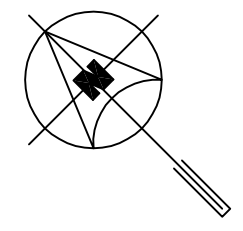

**1 MAIN FLOOR PLAN - NEW CONSTRUCTION - FIRE PROTECTION**  
SCALE: 1/16" = 1'-0"