


1 GLAZING SCHEDULE
1:50

2 CONCRETE PANEL SCHEDULE
1:50

Issue / rev.

Issue / rev.	date	issue notes
1	2016.12.19	ISSUED FOR ADDENDUM 02
0	2016.12.08	ISSUED FOR CONSTRUCTION

professional seals

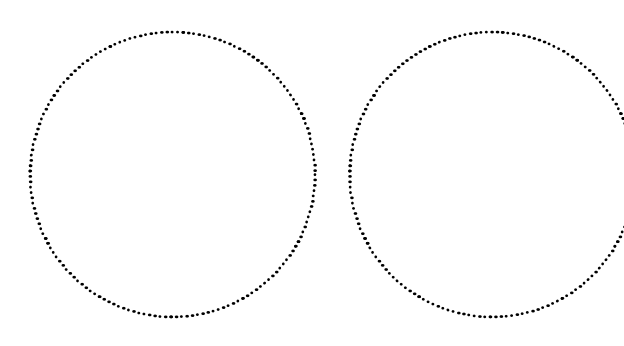

project information

SEVEN OAKS POOL RENOVATION & ADDITION
444 ADSUM DRIVE
WINNIPEG, MB
CANADA

client

CITY OF WINNIPEG
4TH FLOOR - 85 KING ST.
WINNIPEG, MB

drawing information

GLAZING SCHEDULE

drawn by: LW
approved by: DF

scale: 1:50
date issued: 2016.12.08
proj. #: 2014.66
rev. #: R-1

This drawing must not be used for construction or other legal or financial purposes without the written permission of the architect. The copyright in this drawing is reserved by the architect. All dimensions and other data on this plan to be used for construction or other legal or financial purposes must be verified by the contractor. No reproduction may be made without the permission of the architect, and when made, must bear the name of the architect on request.