


1 GLAZING SCHEDULE
1:50

2 CONCRETE PANEL SCHEDULE
1:50

Issue / rev.

0	2016.12.08	ISSUED FOR CONSTRUCTION
#	date	issue notes

professional seals

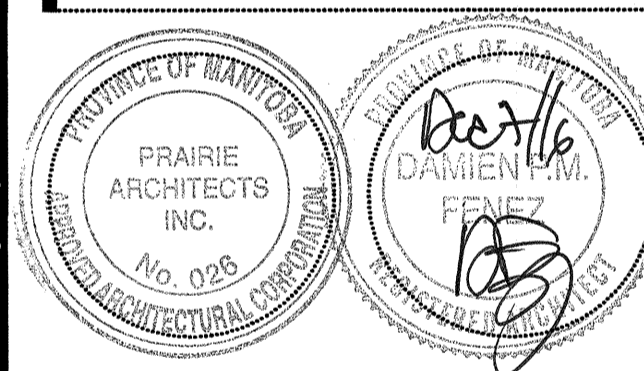

project information

SEVEN OAKS POOL RENOVATION & ADDITION
444 ADSUM DRIVE
WINNIPEG, MB
CANADA

client

CITY OF WINNIPEG
4TH FLOOR - 85 KING ST.
WINNIPEG, MB

drawing information

GLAZING SCHEDULE

drawn by: LW
approved by: DF
scale: 1:50
date issued: 2016.12.08
proj. #: 2014.66
rev. #: R-0

A3
02

This drawing must not be scaled. The contractor shall verify all dimensions and clear data on site prior to commencement of work. All discrepancies, errors, and omissions are to be reported to the architect. Drawing and specifications, as instruments of service, are the property of the architect. The copyright in the same being reserved to him. No reproduction may be made without the permission of the architect, and when made, must bear his name. All prints to be returned to the architect on request.