


Issue / rev.

0	2016/12/08	ISSUED FOR CONSTRUCTION
#	date	issue notes

professional seals

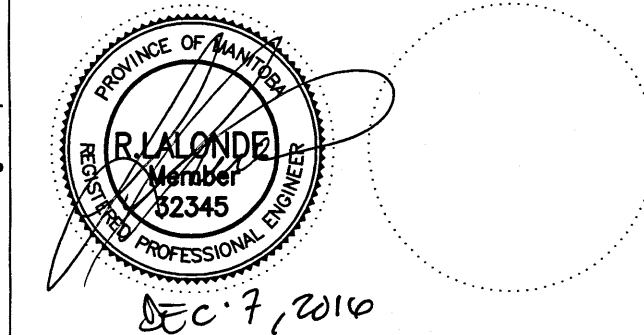

project information

SEVEN OAKS POOL

444 Adsum Drive
Winnipeg, MB
Canada

client

City of Winnipeg
4th Floor - 86 King Street
Winnipeg, MB

drawing information

**ELECTRICAL
CRAWLSPACE
LIGHTING - DEMO**

drawn by: **GCN**

approved by: *[Signature]*

scale: **AS NOTED**

date issued: **2016.11.23**

proj. #: **14-1736-008**

rev. #: **R-0**

**SEVEN OAKS POOL
RENOVATION & ADDITION**
BID OPPORTUNITY NO. 1044-2016


**E2
00**

NOTES:

- FOR AREA INDICATED, EXISTING LIGHTING, LIGHTING CONTROLS, EMERGENCY LIGHTING AND ASSOCIATED WIRING AND CONDUIT TO REMAIN.
- RELOCATE EXISTING STAIRWELL LIGHTING FIXTURE TO SUIT NEW VESTIBULE.

RENOVATION LEGEND:

- X EXISTING ELECTRICAL EQUIPMENT TO BE REMOVED AND TURNED OVER TO THE OWNER OR AS DIRECTED BY THE ENGINEER. REMOVE, BLANK OFF, EXTEND OR RELOCATE ALL ASSOCIATED WIRING AND MAKE SAFE.
- * EXISTING ELECTRICAL EQUIPMENT TO BE REMOVED AND REINSTALLED OR RELOCATED AS SHOWN UPON COMPLETION OF NEW CEILING OR WALL CONSTRUCTION. RE-WIRE OR EXTEND WIRING AS REQUIRED.
- ✓ EXISTING ELECTRICAL EQUIPMENT TO REMAIN IN IT'S PRESENT LOCATION. REWIRE OR EXTEND WIRING AS REQUIRED.

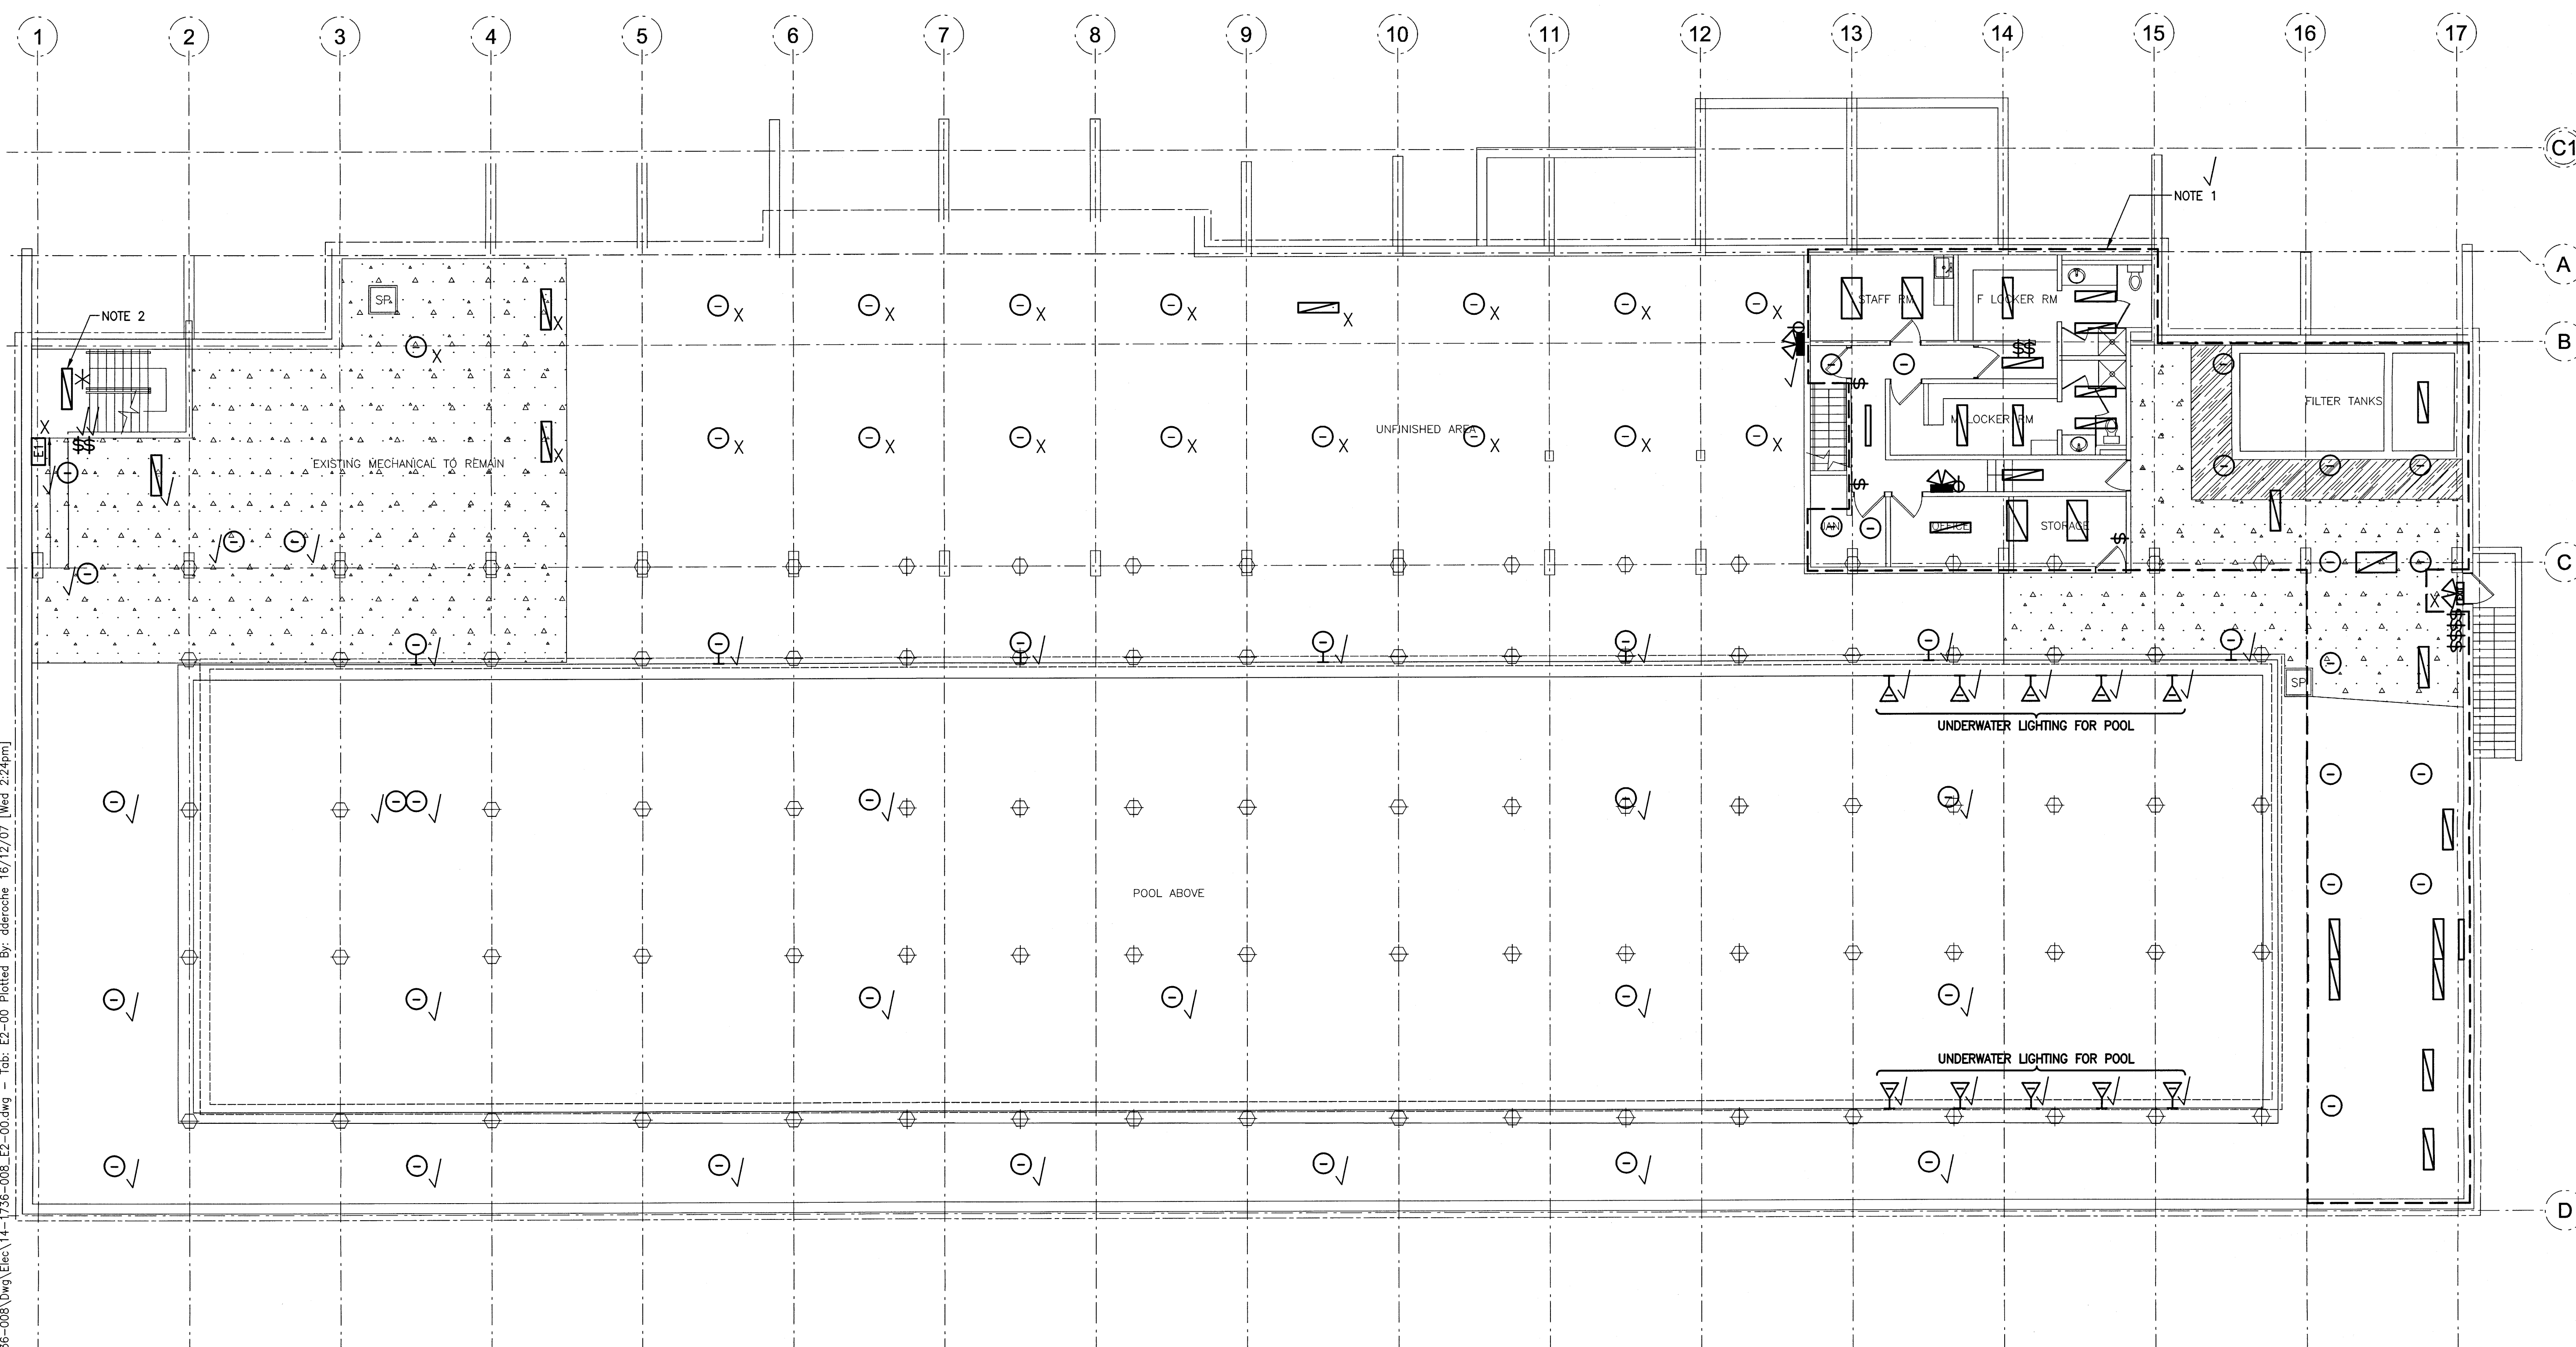

1 CRAWLSPACE LIGHTING PLAN - DEMO
SCALE: 1:100mm (24"x36")

File Name: P:\Projects\2014\14-1736-008 (Dwg) Elec\14-1736-008-E2-00.dwg - Tab: E2-00 Plotted By: dderoché 16/12/07 [Wed 2:24pm]

This drawing must not be scaled. The contractor shall verify all dimensions and other data on site prior to commencement of work. All discrepancies, errors and omissions are to be reported to the architect. Drawing and specifications, as instruments of service, are the property of the architect. The copyright in the same being reserved to him. No reproduction may be made without the permission of the architect, and when made, must bear the name. All printed to be returned to the architect on request.