


#	date	issue notes
0	2016/12/08	ISSUED FOR CONSTRUCTION

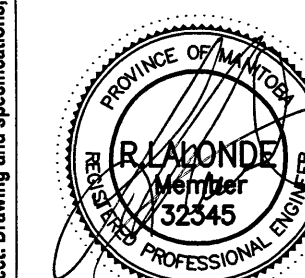

DEC 7, 2016

SEVEN OAKS POOL

444 Adsum Drive
Winnipeg, MB
Canada

**ELECTRICAL
MEZZANINE
LIGHTING - DEMO**
drawn by: GCN
approved by:
scale: AS NOTED
date issued: 2016.11.23
proj. #: 14-1736-008
rev. #: R-0


**SEVEN OAKS POOL
RENOVATION & ADDITION**
BID OPPORTUNITY NO. 1044-2016

NOTES:

- EXISTING BATTERY UNITS SHALL BE RELOCATED TO THE NEW MEZZANINE ELECTRICAL ROOM. EXISTING HEAD SHALL BE REMOVED AND PLUGS PROVIDED TO COVER EXISTING KNOCKOUTS. CONTRACTOR TO WIRE UP THE EXISTING BATTERY UNITS IN THE SAME FASHION TO ENSURE ALL EXISTING REMAINING REMOTE HEADS ARE STILL FULLY OPERATIONAL. CONTRACTOR TO ENSURE THAT THE BATTERY UNIT OPERATES OFF A CIRCUIT IN THE AREA FOR ALL EXISTING REMOTE HEADS.

RENOVATION LEGEND:

- X EXISTING ELECTRICAL EQUIPMENT TO BE REMOVED AND TURNED OVER TO THE OWNER OR AS DIRECTED BY THE ENGINEER. REMOVE, BLANK OFF, EXTEND OR RELOCATE ALL ASSOCIATED WIRING AND MAKE SAFE.
- * EXISTING ELECTRICAL EQUIPMENT TO BE REMOVED AND REINSTALLED OR RELOCATED AS SHOWN UPON COMPLETION OF NEW CEILING OR WALL CONSTRUCTION. RE-WIRE OR EXTEND WIRING AS REQUIRED.
- ✓ EXISTING ELECTRICAL EQUIPMENT TO REMAIN IN IT'S PRESENT LOCATION. REWIRE OR EXTEND WIRING AS REQUIRED.

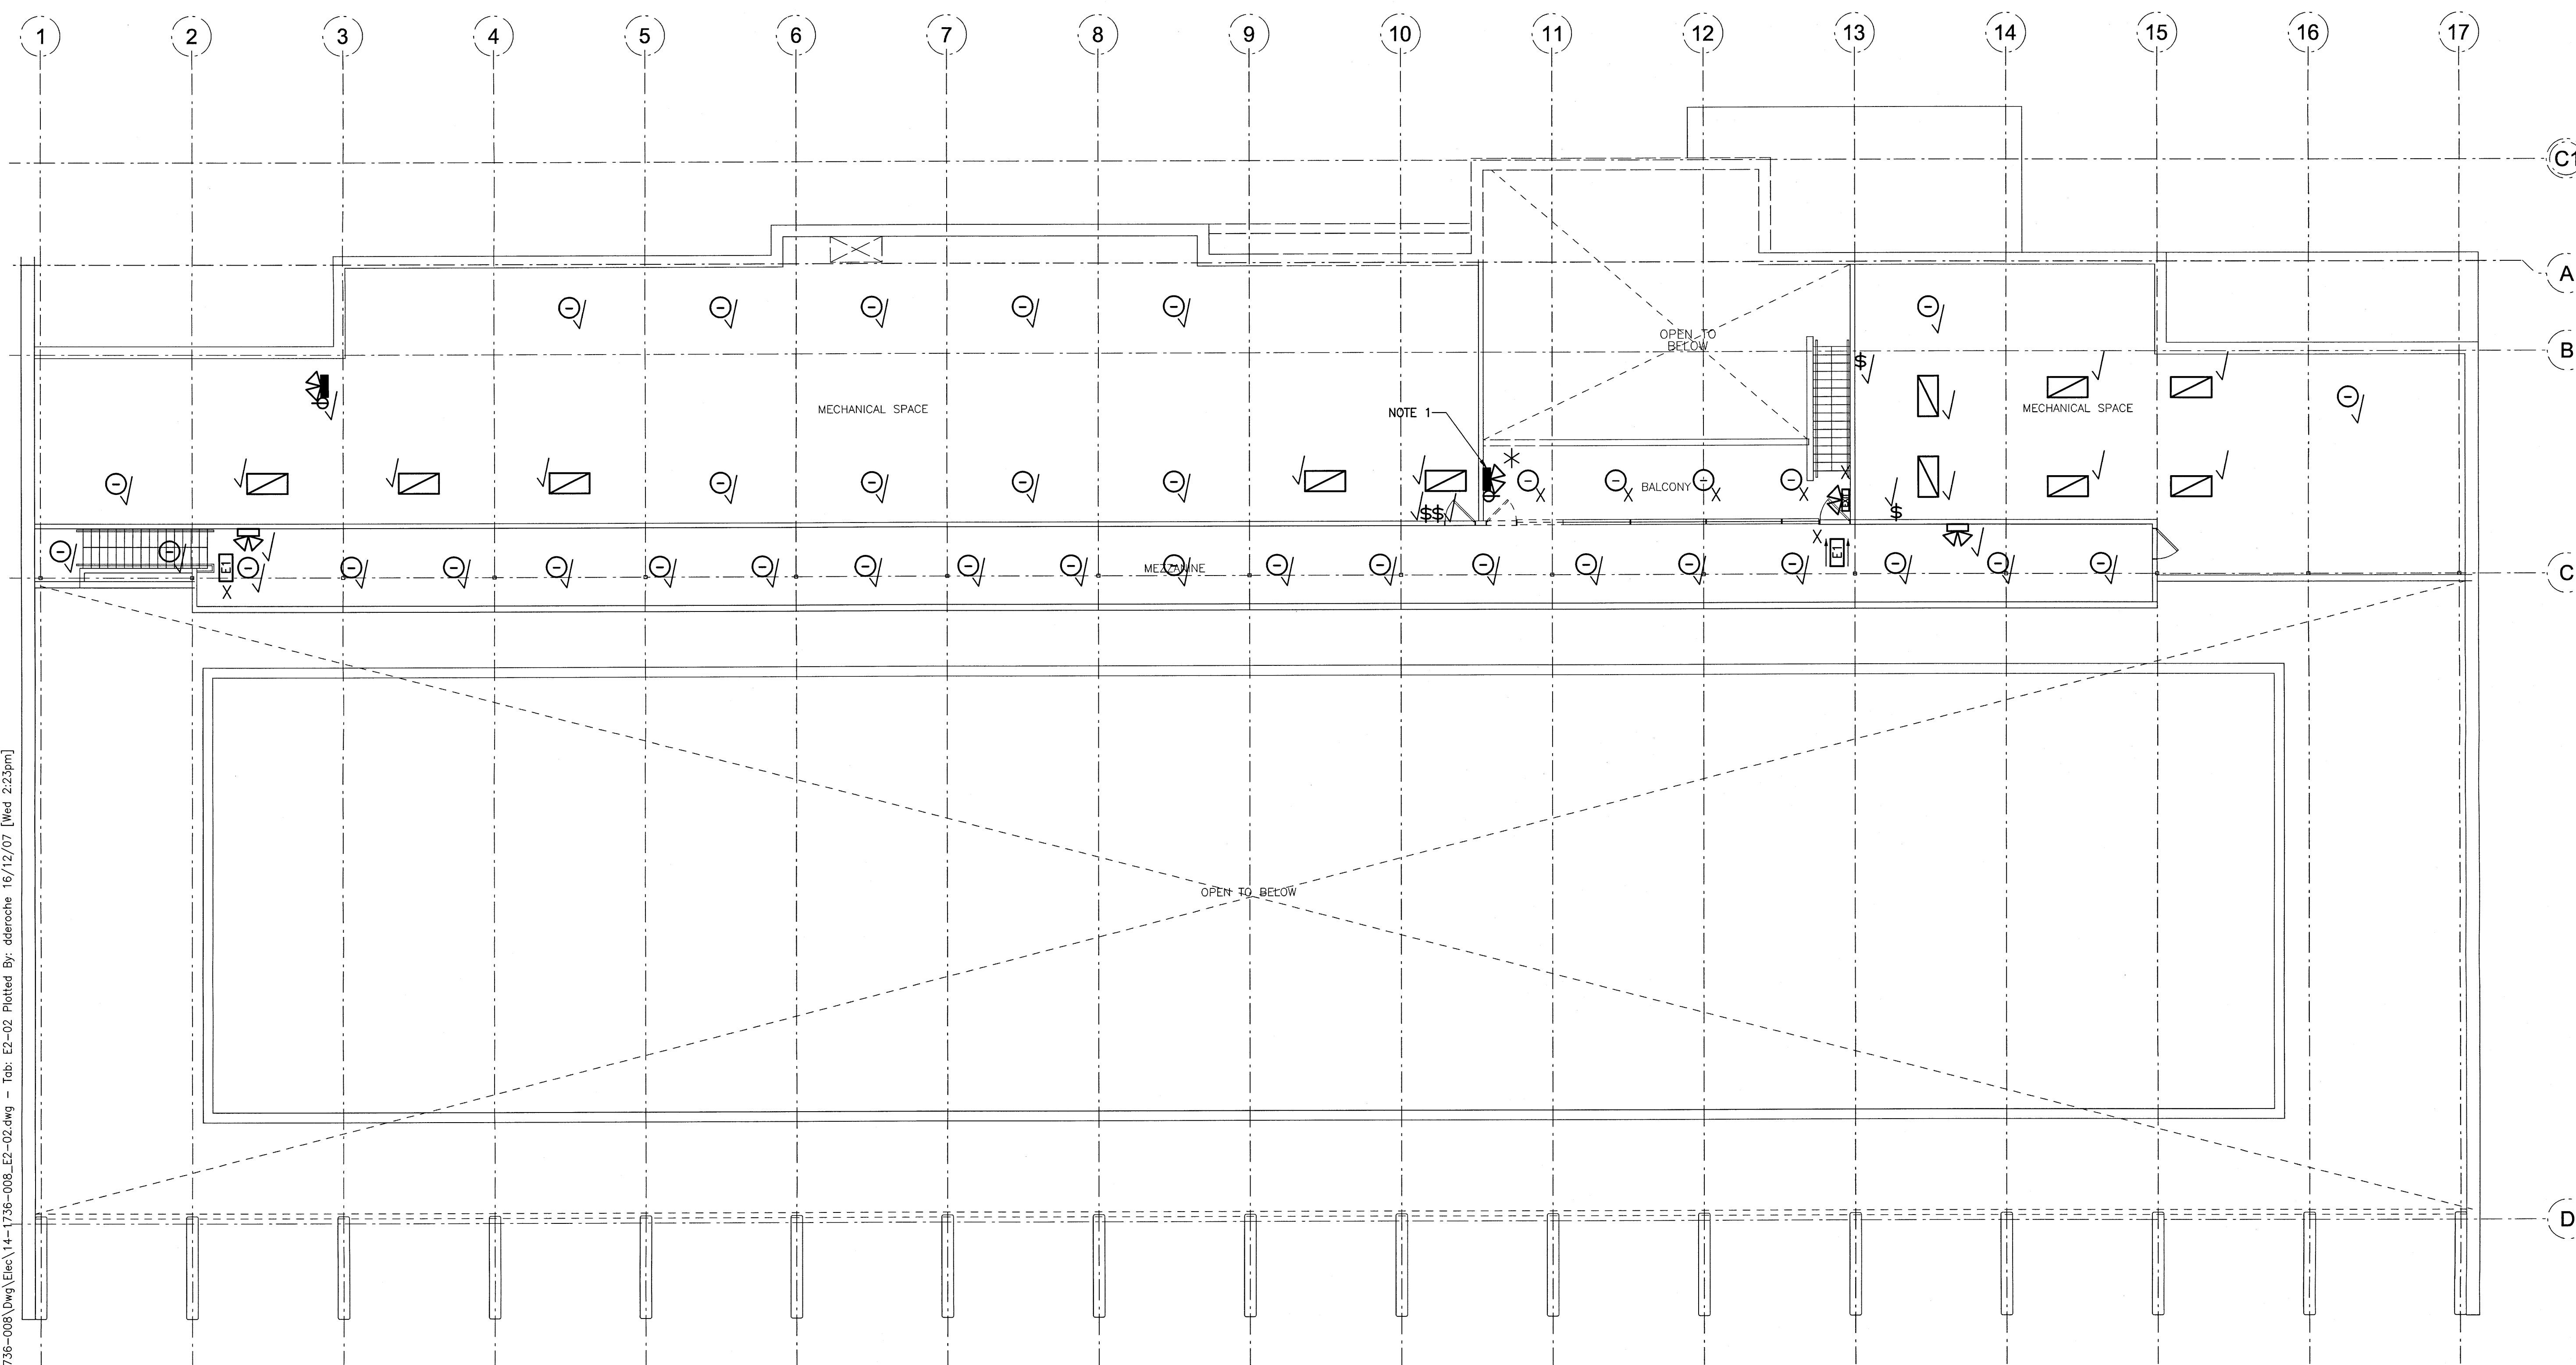

1 MEZZANINE LIGHTING PLAN - DEMO
SCALE: 1:100mm (24"x36")

File Name: P:\Projects\2014\14-1736-008\Elec\14-1736-008-E2-02.dwg - Tab: E2-02 Plotted By: dderoché 16/12/07 (Wed 2:23pm)

This drawing must not be scaled. The contractor shall verify all dimensions and other data on site prior to commencement of work. All discrepancies, errors, and omissions are to be reported to the architect. Drawing and specifications, as instruments of service, are the property of the architect, the copyright in the same being reserved to him. No reproduction may be made without the permission of the architect, and when made, must bear his name. All prints to be returned to the architect on request.