


Issue / rev.

0	2016/12/08	ISSUED FOR CONSTRUCTION
#	date	issue notes

professional seals

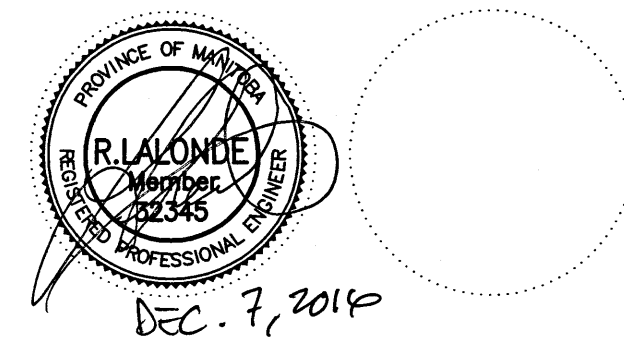

project information

SEVEN OAKS POOL

444 Adsum Drive
Winnipeg, MB
Canada

client

City of Winnipeg
4th Floor - 86 King Street
Winnipeg, MB

drawing information

ELECTRICAL MAIN FLOOR LIGHTING - NEW

drawn by: GCN

approved by:

scale: AS NOTED

date issued: 2016.11.23


proj. #: 14-1736-008

rev. #: R-0

SEVEN OAKS POOL RENOVATION & ADDITION
BID OPPORTUNITY NO. 1044-2016

NOTES:

1. PROVIDE WALL BRACKET.
2. TYPE C1 AND TYPE C2 LUMINAIRES SHALL BE SUSPENDED FROM THE CEILING.
3. PROVIDE AND INSTALL A 12"-0" POLE.
4. ALL FIXTURES SHALL BE COORDINATE WITH ARCHITECTURAL DRAWINGS FOR FINAL MOUNTING HEIGHTS.
5. CONTRACTOR SHALL COORDINATE WITH ALL DUCT WORK AND MECHANICAL EQUIPMENT PRIOR TO INSTALLATION.
6. TYPE 'L' LUMINAIRES SHALL BE CONNECTED FOR A CONTINUOUS RUN. END CAPS REQUIRED ONLY AT THE ENDS OF EACH RUN.
7. PROVIDE AN FLIGHT WALL GRAPHICS POD FOR CONTROL OF ALL RELOCATED EXISTING LIGHTING CONTROLS. REFER TO NOTE 2 ON DRAWING E2-01.
8. LUMINAIRES LOCATED IN EXISTING MALE AND FEMALE CHANGE ROOMS SHALL BE RELOCATED AS SHOWN TO SUIT THE NEW WALL LAYOUT.
9. ALL CONDUIT WIRING TO TYPE 'B' LUMINAIRES AND DAYLIGHT SENSORS MOUNTED IN THE SPLASH PAD CEILING SHALL BE CONCEALED IN THE FLUTES. COORDINATE CONDUIT RUNS WITH THE CEILING SHOP DRAWINGS SUCH THAT ALL WIRING IS CONCEALED. ALL JUNCTION BOXES AND DEVICE BACK BOXES SHALL BE RECESSED. COORDINATE WITH MANUFACTURERS RECOMMENDATIONS.

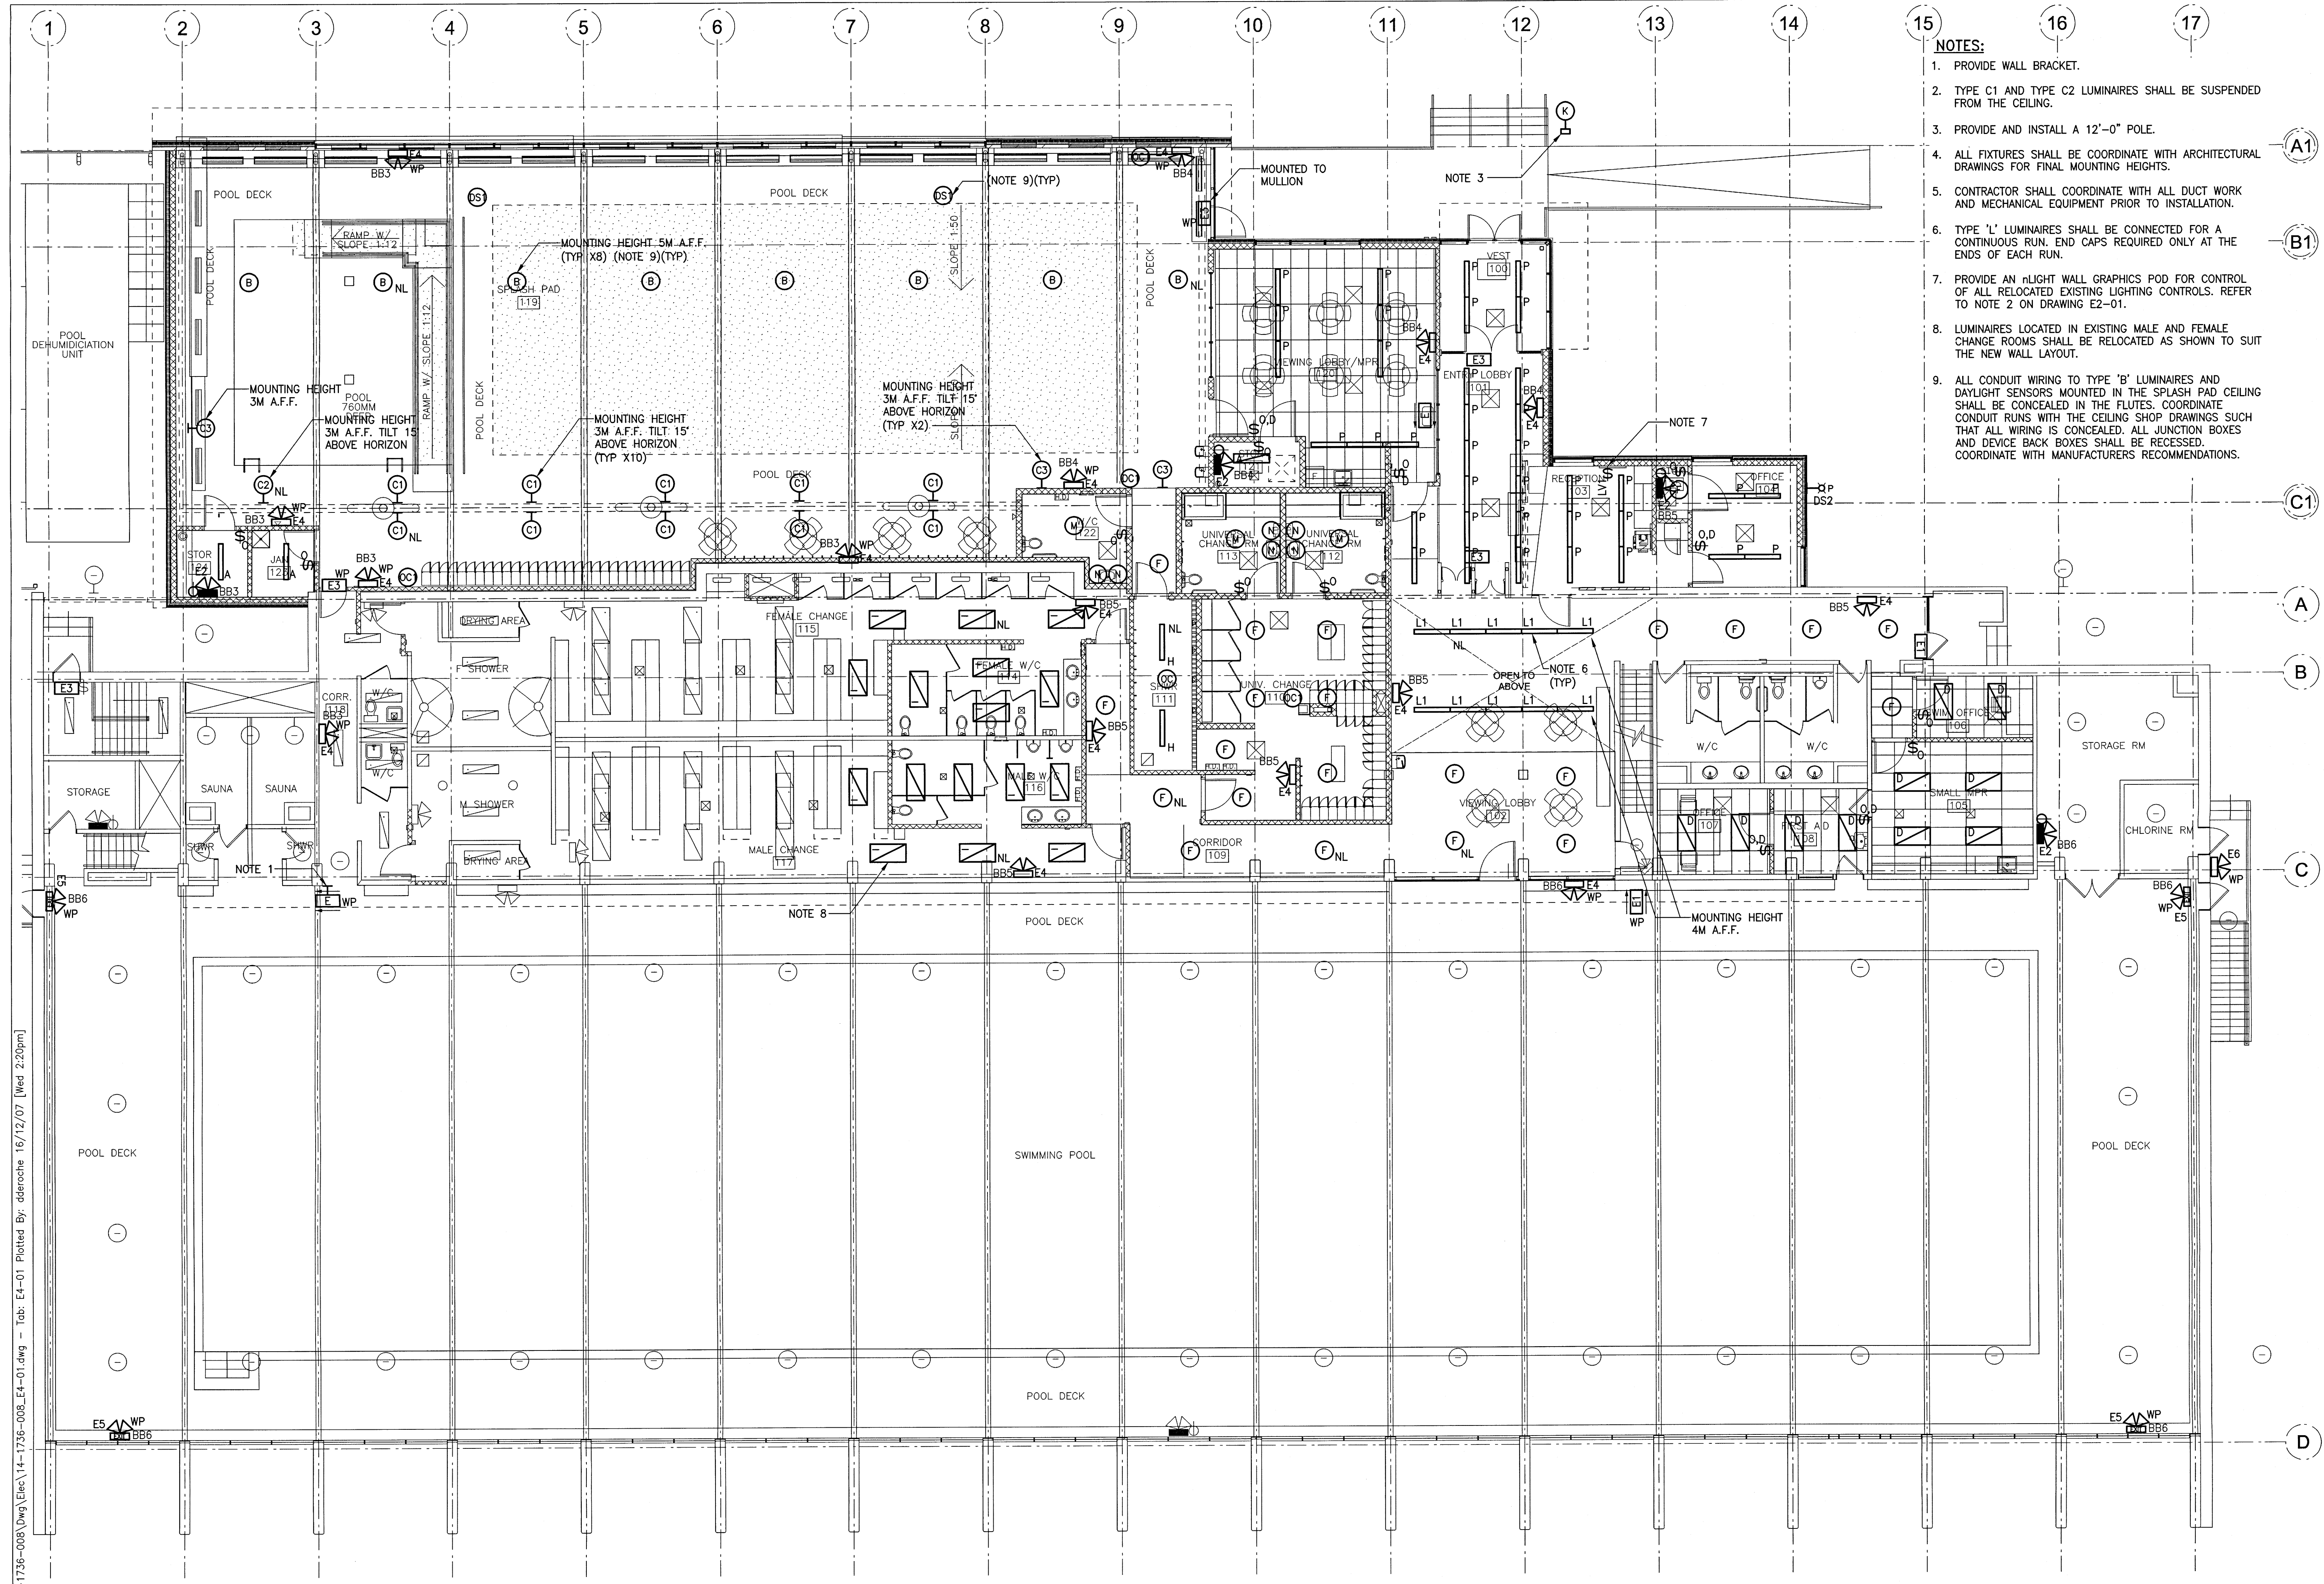

1 MAIN FLOOR LIGHTING PLAN - NEW
SCALE: 1:100mm (24"x36")

File Name: P:\Projects\2014\14-1736-008\Drawings\Elec\14-1736-008_E4-01.dwg - Tab: E4-01 Plotted By: dderoché 16/12/07 [Wed 2:20pm]

This drawing must not be scaled. The contractor shall verify all dimensions and other data on site prior to commencement of work. All discrepancies, errors, and omissions are to be reported to the architect. Drawing and specifications, in instruments of service, are the property of the architect. No reproduction may be made without the permission of the architect, and when made, must bear the name. All profits to be returned to the architect on request.