


Issue / rev.

Issue / rev.	date	Issue notes
0	2016/12/08	ISSUED FOR CONSTRUCTION
#		

professional seals

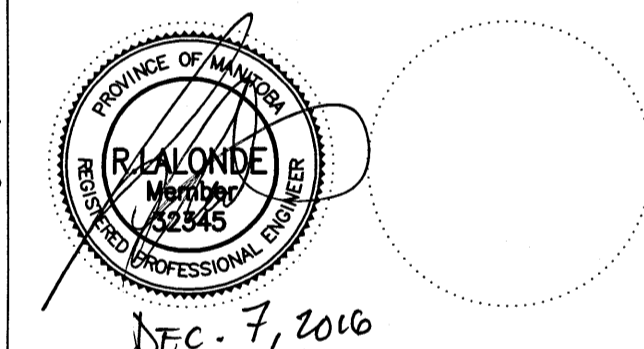

project information

SEVEN OAKS POOL

444 Adsum Drive
Winnipeg, MB
Canada

client

City of Winnipeg
4th Floor - 86 King Street
Winnipeg, MB

drawing information

ELECTRICAL MEZZANINE LIGHTING - NEW

drawn by: **GCN**

approved by:


scale: **AS NOTED**

date issued: **2016.11.23**

proj. #: **14-1736-008**

rev. #: **R-0**

E4 02

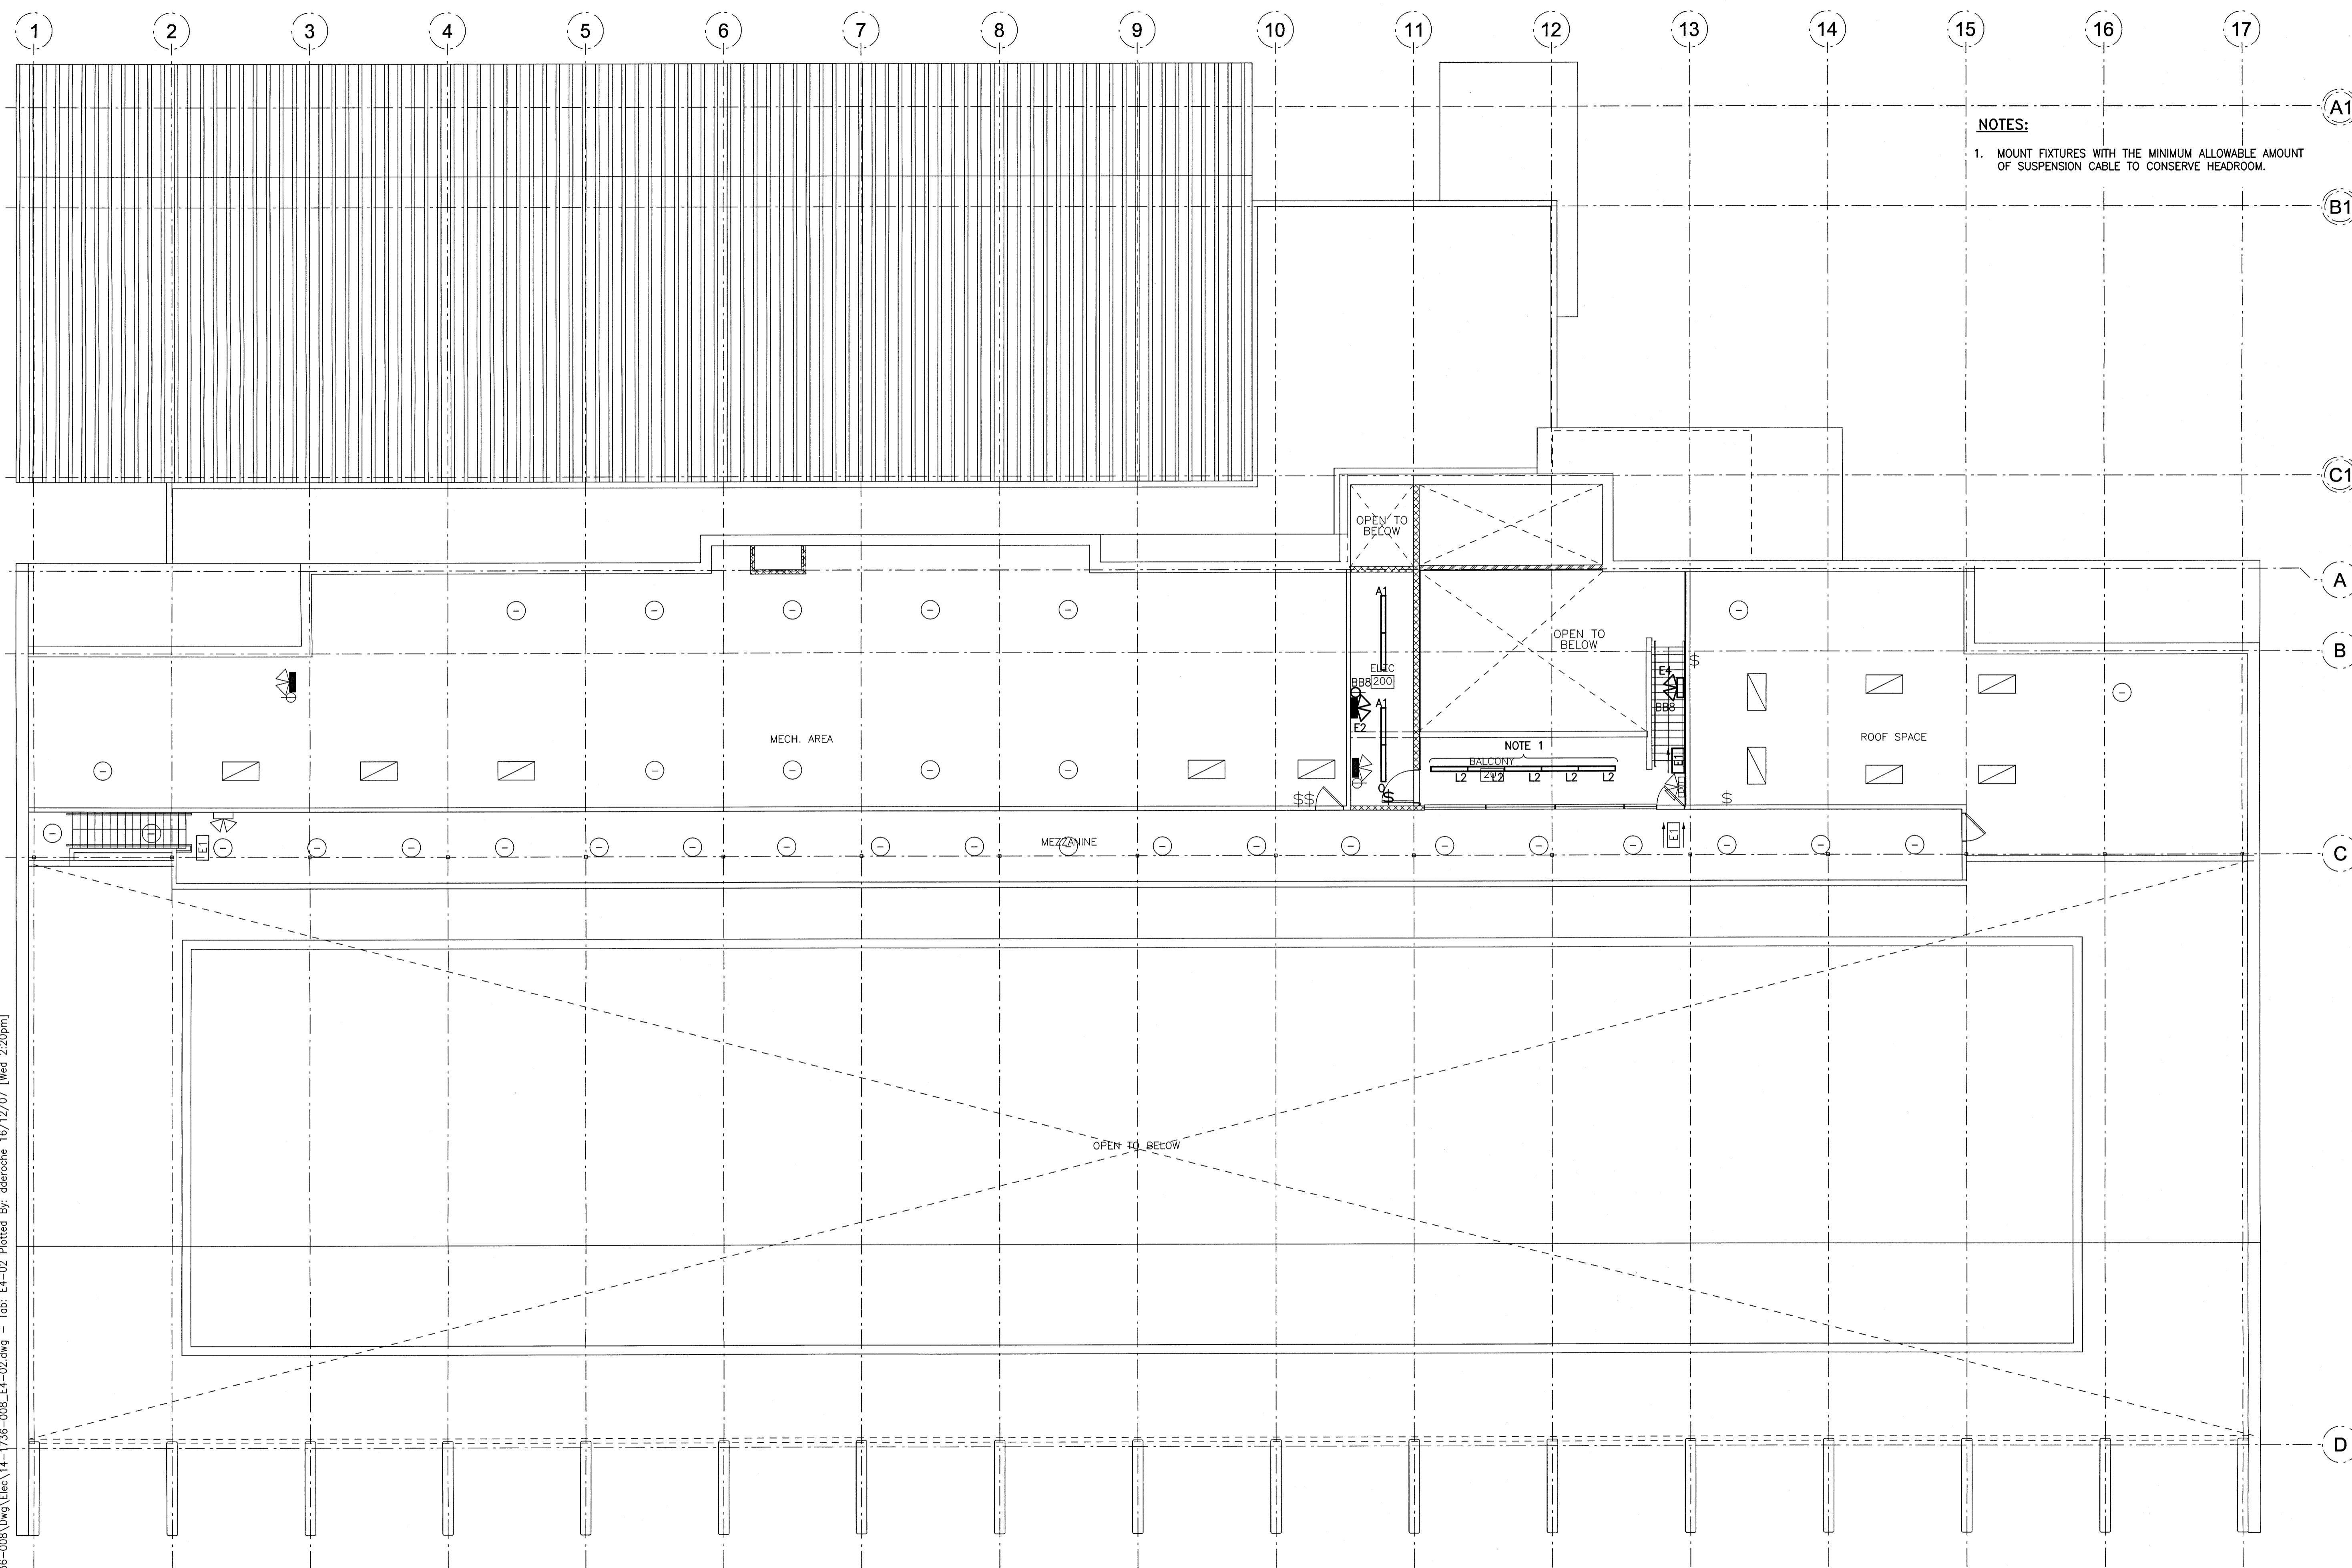

NOTES:

1. MOUNT FIXTURES WITH THE MINIMUM ALLOWABLE AMOUNT OF SUSPENSION CABLE TO CONSERVE HEADROOM.

OPEN TO BELOW

OPEN TO BELOW

NOTE 1

OPEN TO BELOW

1 MEZZANINE LIGHTING PLAN - NEW

SCALE: 1:100mm (24"x36")

File Name: P:\Projects\2014\14-1736-008\Drawings\Elec\14-1736-008_E4-02.dwg - Tab: E4-02 Plotted By: dderoché 16/12/07 [Wed 2:20pm]

This drawing must not be scaled. The contractor shall verify all dimensions and other data on site prior to commencement of work. All discrepancies, errors, and omissions are to be reported to the architect. Drawing and specifications, as instruments of service, are the property of the architect. The copyright in the same being reserved to him. No reproduction may be made without the permission of the architect, and when made, must bear his name. All prints to be returned to the architect on request.