


File Name: P:\Projects\2014\14-1736-008\DWG\Mech\14-1736-008_M2-02.dwg - Tab: M2-02 Plotted By: dderoché 16/12/07 [Wed 3:07pm]

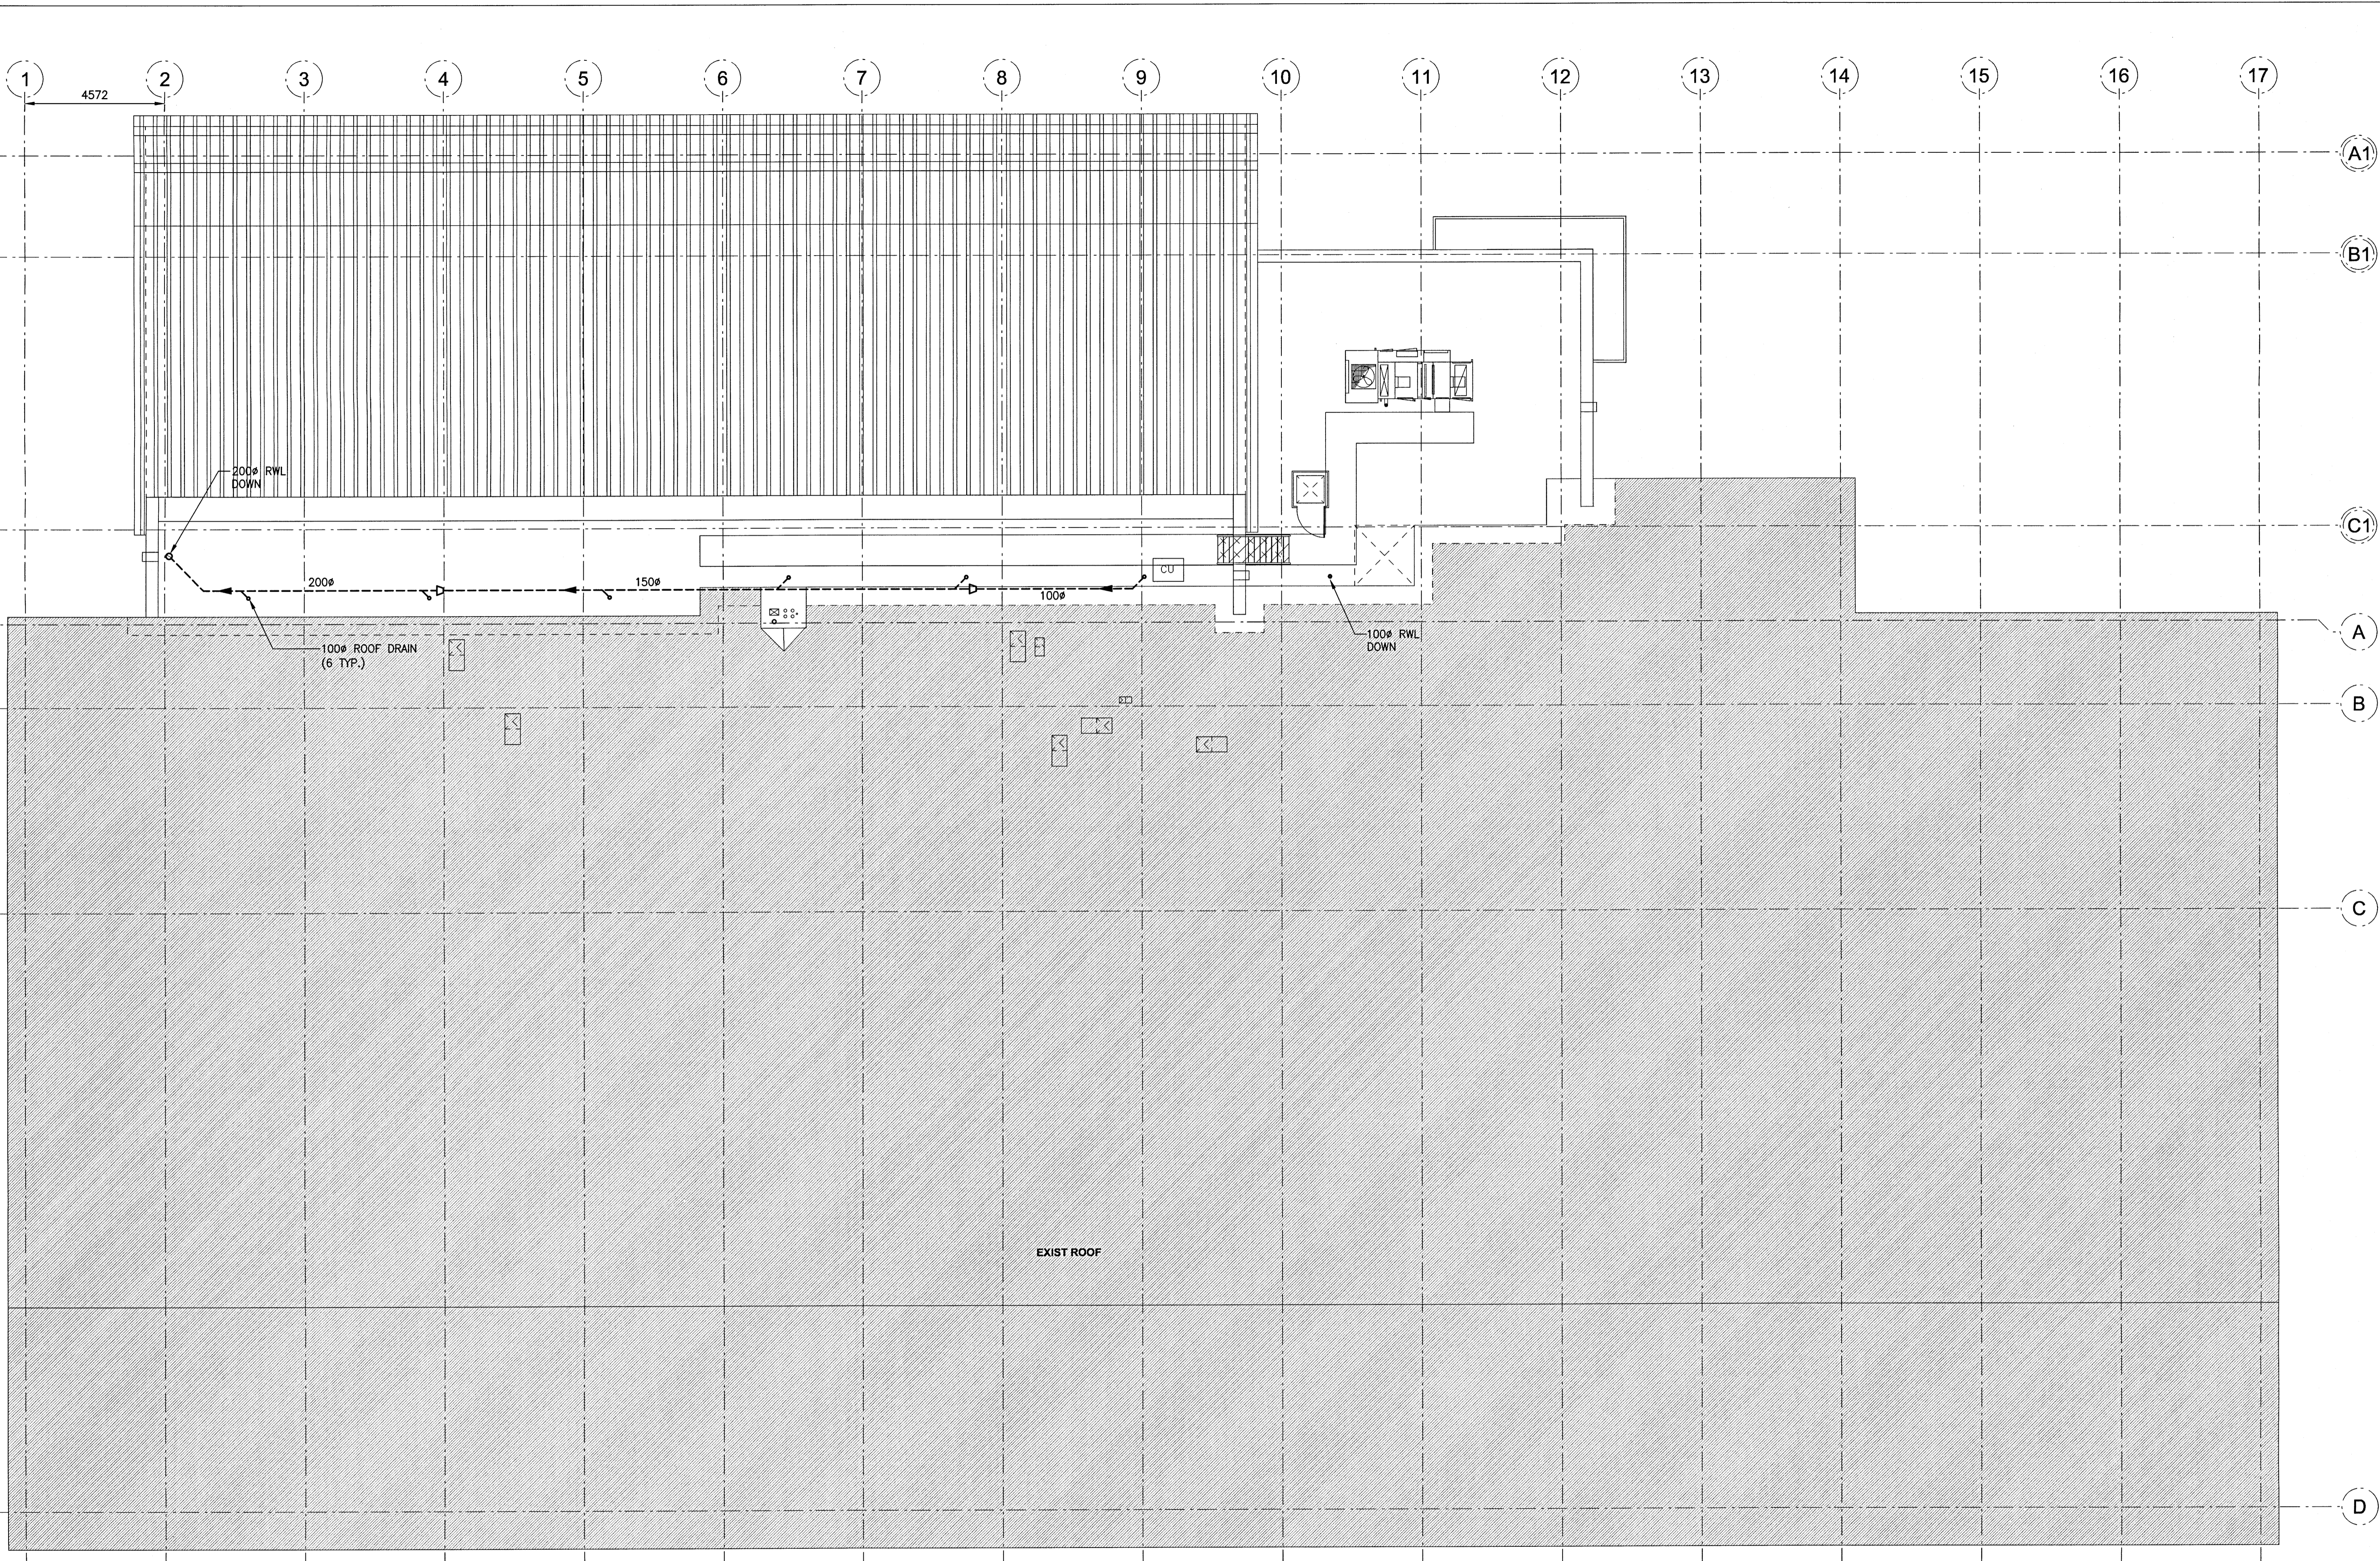

1 ROOF PLAN - NEW ROOF DRAINS
SCALE: 1:100mm (24"x36")

KEYNOTES:

- 1 PROVIDE NEW ROOF DRAINS. LOCATION TO BE CONFIRMED.
- 2 PROVIDE NEW INSULATED RAIN WATER LEADER FROM ROOF DRAINS HUNG FROM UNDERSIDE OF ROOF. PROVIDE PAINTED PVC JACKET TO MATCH WALL COLOUR.


300 - 141 Barnatyne Ave., Winnipeg, MB, R3B 0R3
telephone 204.958.0938 fax 204.943.5597
web www.prairiearchitects.ca



Issue / rev.

#	date	issue notes
0	2016/12/08	ISSUED FOR CONSTRUCTION

professional seals

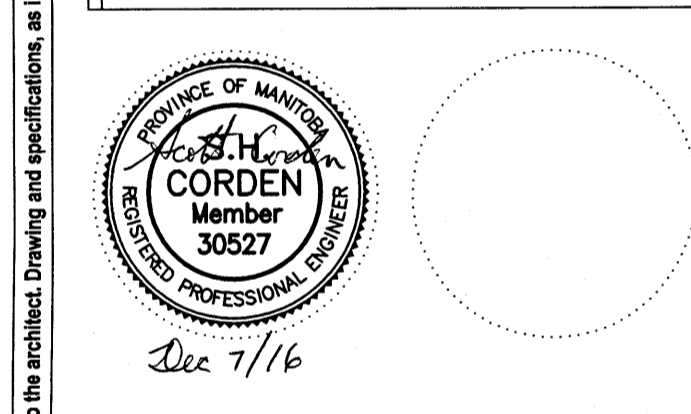

project information

SEVEN OAKS POOL
444 Adsum Drive
Winnipeg, MB
Canada

client


City of Winnipeg
4th Floor - 86 King Street
Winnipeg, MB

drawing information

MECHANICAL ROOF PLAN NEW PLUMBING
 drawn by: RLR
 approved by: [Signature]
 scale: AS NOTED
 date issued: 2016.12.08
 proj. #: 14-1736-008
 rev. #: R-0

SEVEN OAKS POOL RENOVATION & ADDITION
BID OPPORTUNITY NO. 1044-2016

SCALE VERIFIED BY: *Alc*

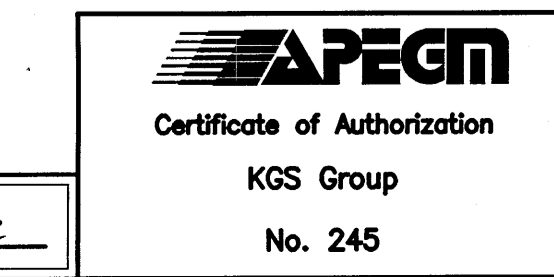

This drawing must not be scaled. The contractor shall verify all dimensions and other data on site prior to commencement of work. All discrepancies, errors, and omissions are to be reported to the architect. Drawing and specifications, as instruments of service, are the property of the architect. The copyright in this architect, the copyright in the same being reserved to him. No reproduction may be made without the permission of the architect, and when made, must bear his name. All prints to be returned to the architect on request.