


Issue / rev.

0	2016/12/08	ISSUED FOR CONSTRUCTION
#	date	issue notes

professional seals

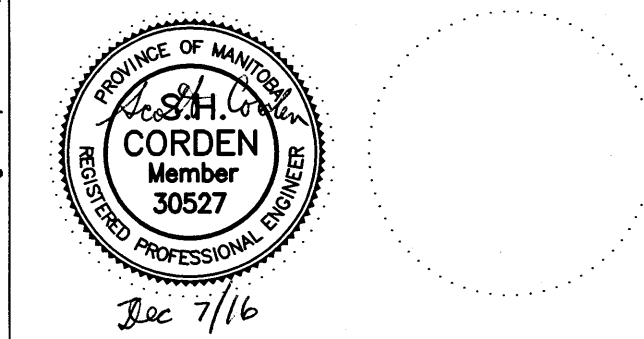

project information

**SEVEN OAKS POOL**

444 Adsum Drive  
Winnipeg, MB  
Canada


client

City of Winnipeg  
4th Floor - 86 King Street  
Winnipeg, MB

drawing information


**MECHANICAL**  
SECTIONS AND DETAILS

drawn by: RLR  
approved by:   
scale: AS NOTED  
date issued: 2016.12.08  
proj #: 14-1736-008  
rev #: R-0

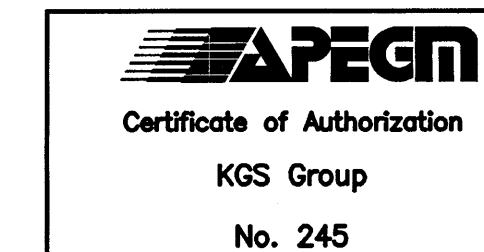


**M5**  
**01**


This drawing must not be scaled. The contractor shall verify all dimensions and other data on site prior to commencement of work. All discrepancies, errors, and omissions are to be reported to the architect. Drawing and specifications, as instruments of service, are the property of the architect. The copyright in the same being reserved to him. No reproduction may be made without the permission of the architect, and when made, must bear his name. All prints to be returned to the architect on request.

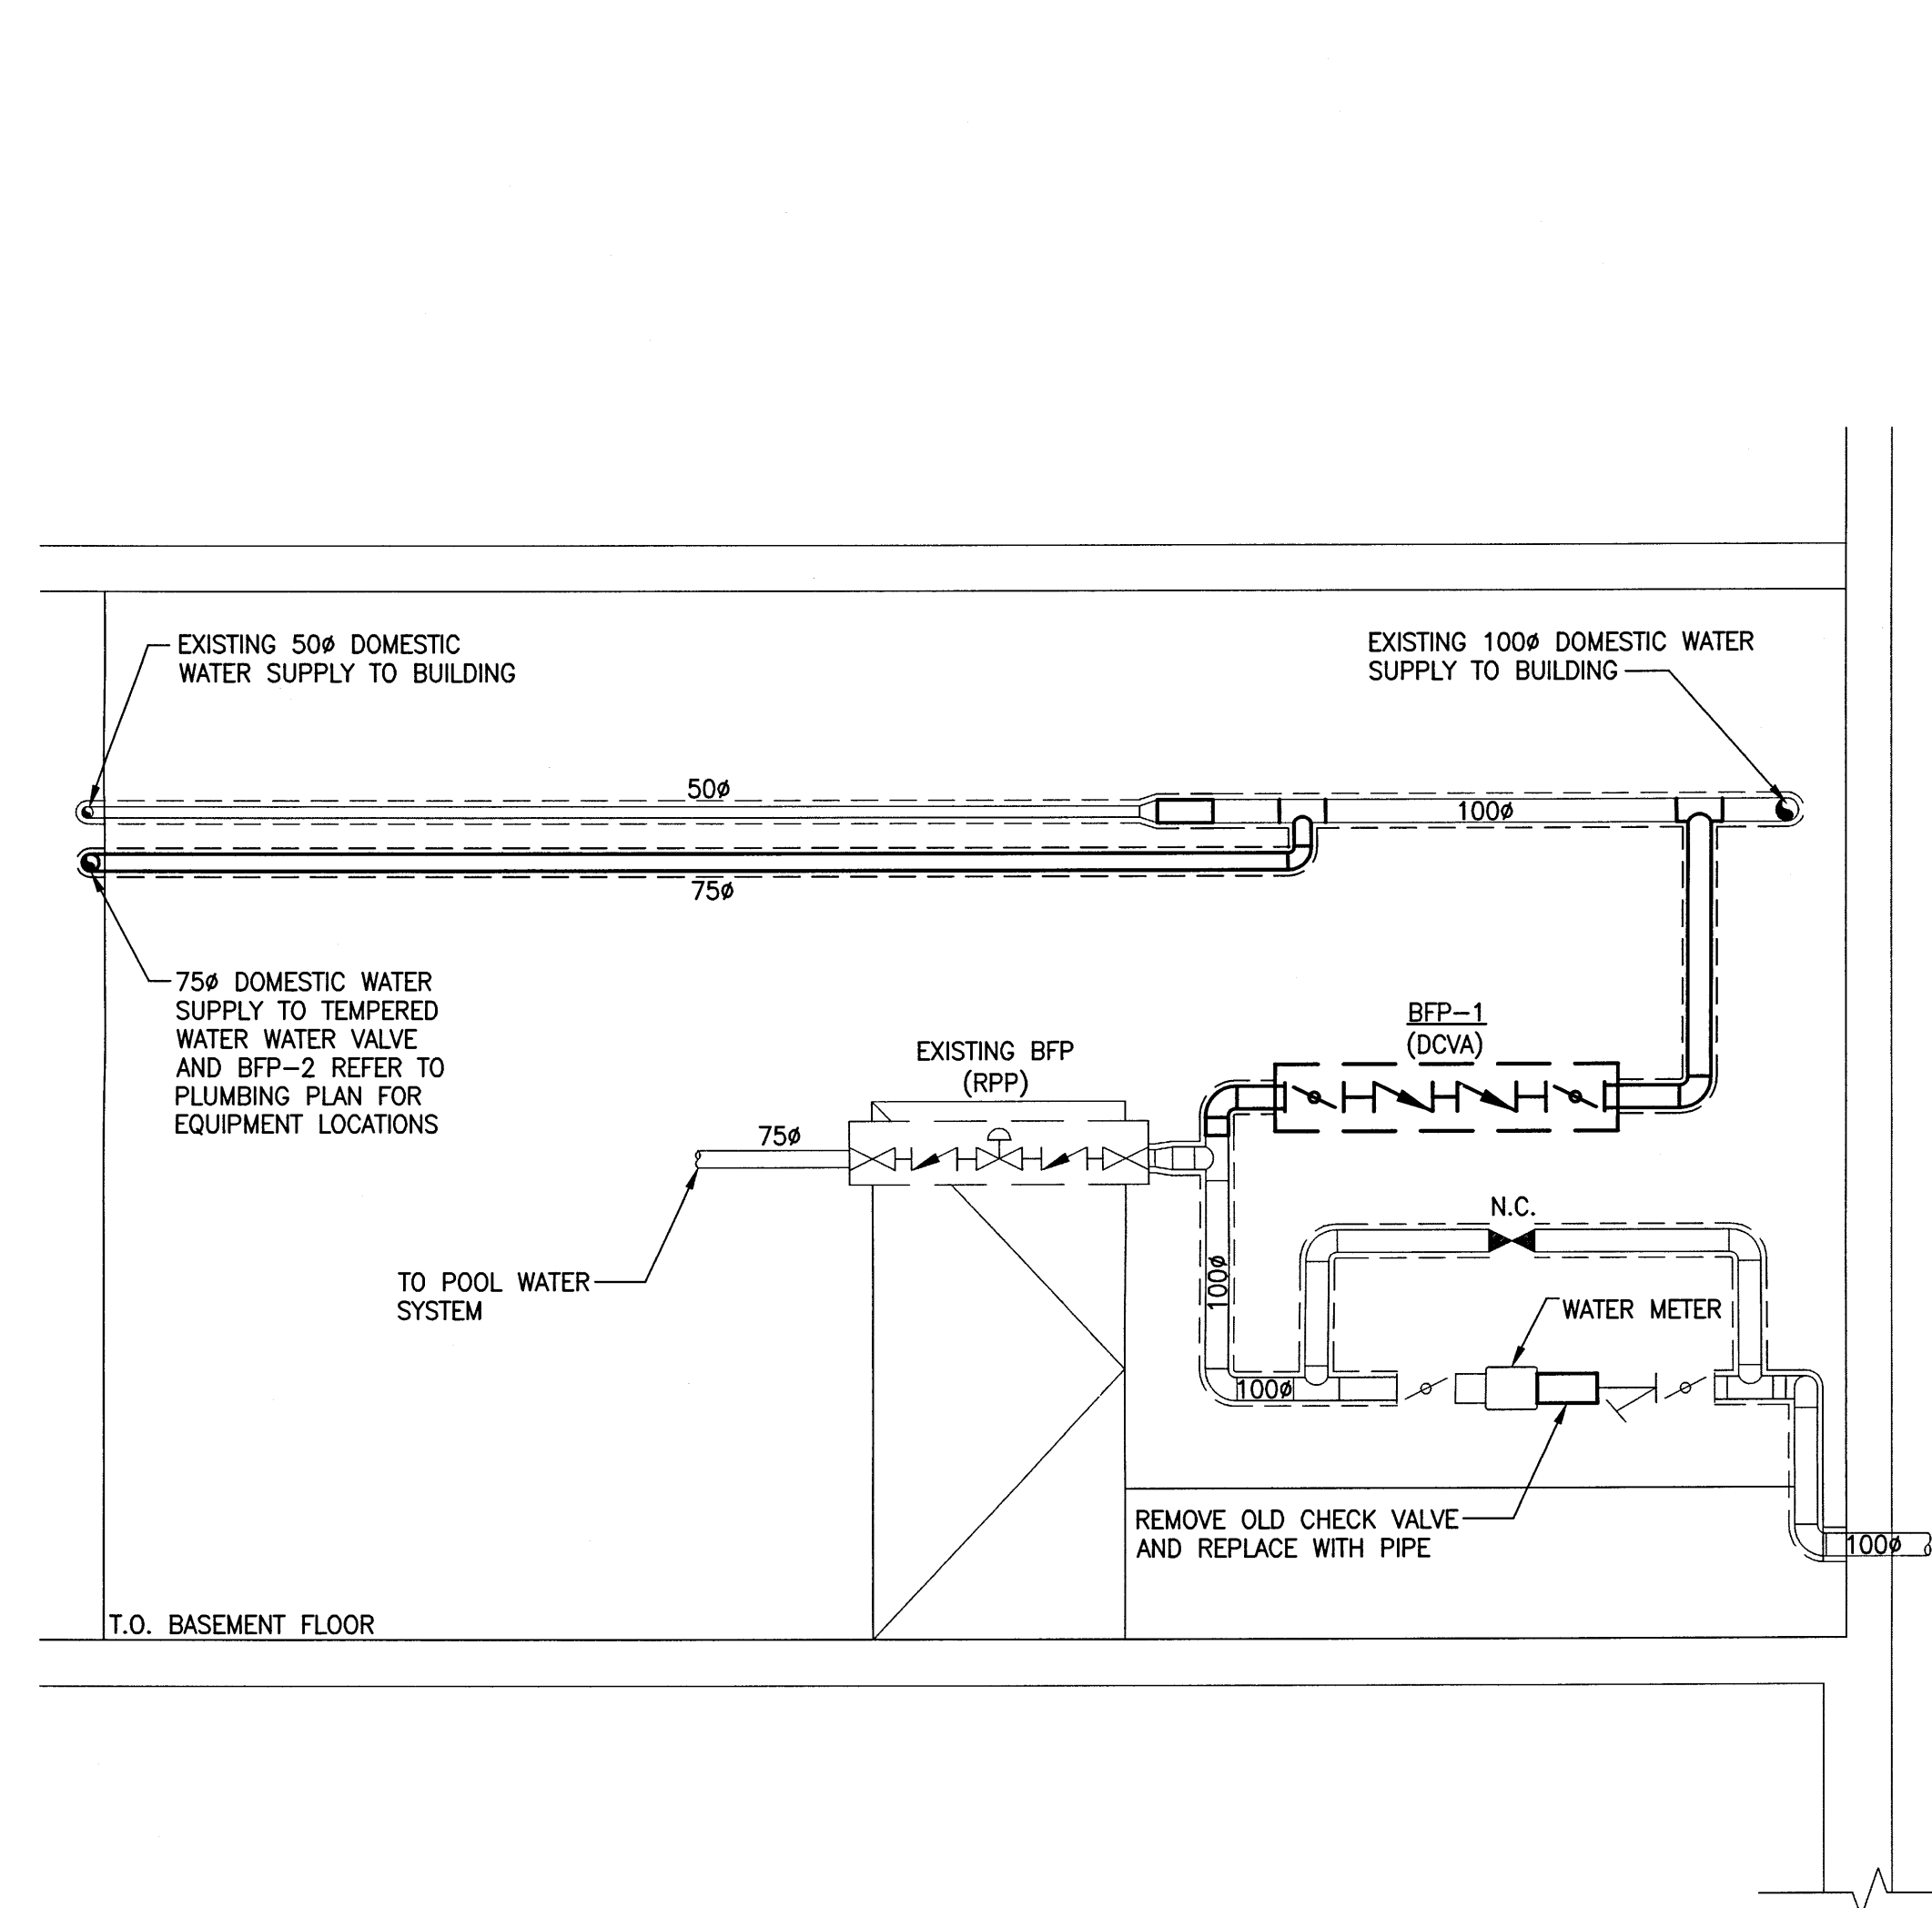

**1** DOMESTIC WATER SERVICE ENTRANCE DETAIL  
M2-00 SCALE: N.T.S.

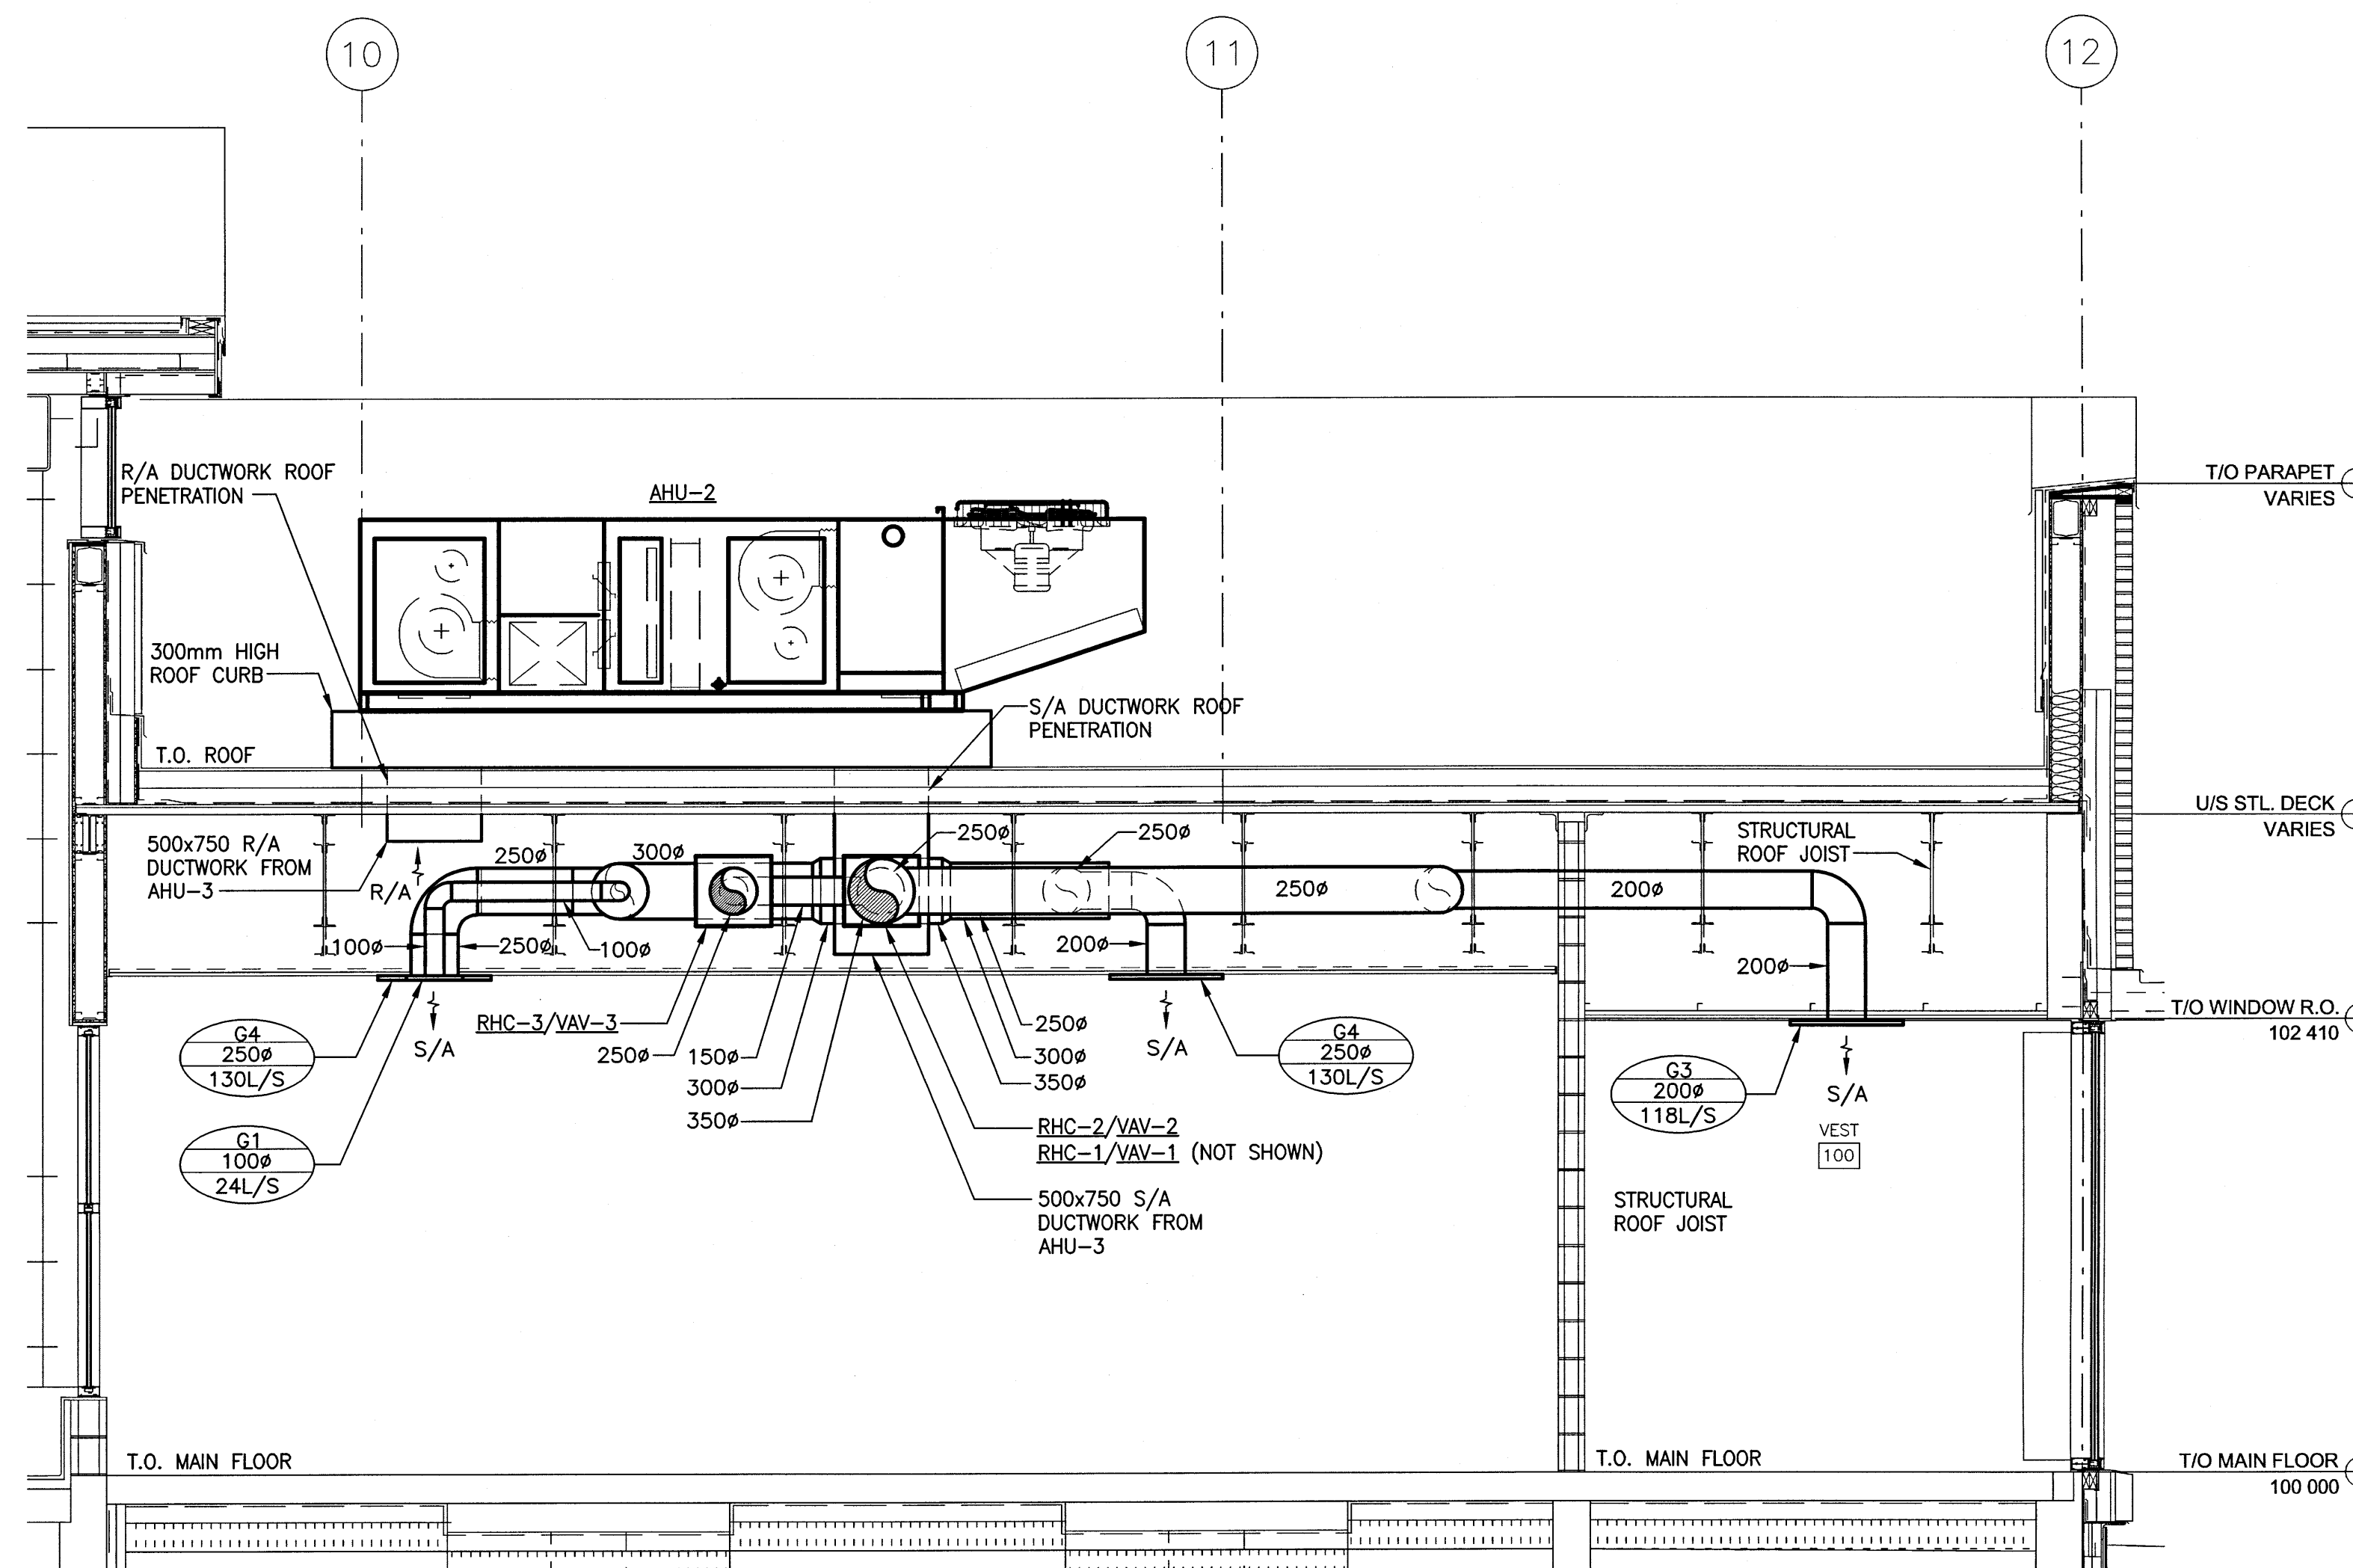

**2** AHU-2 AND DUCTWORK DETAILS  
M3-01 SCALE: N.T.S.

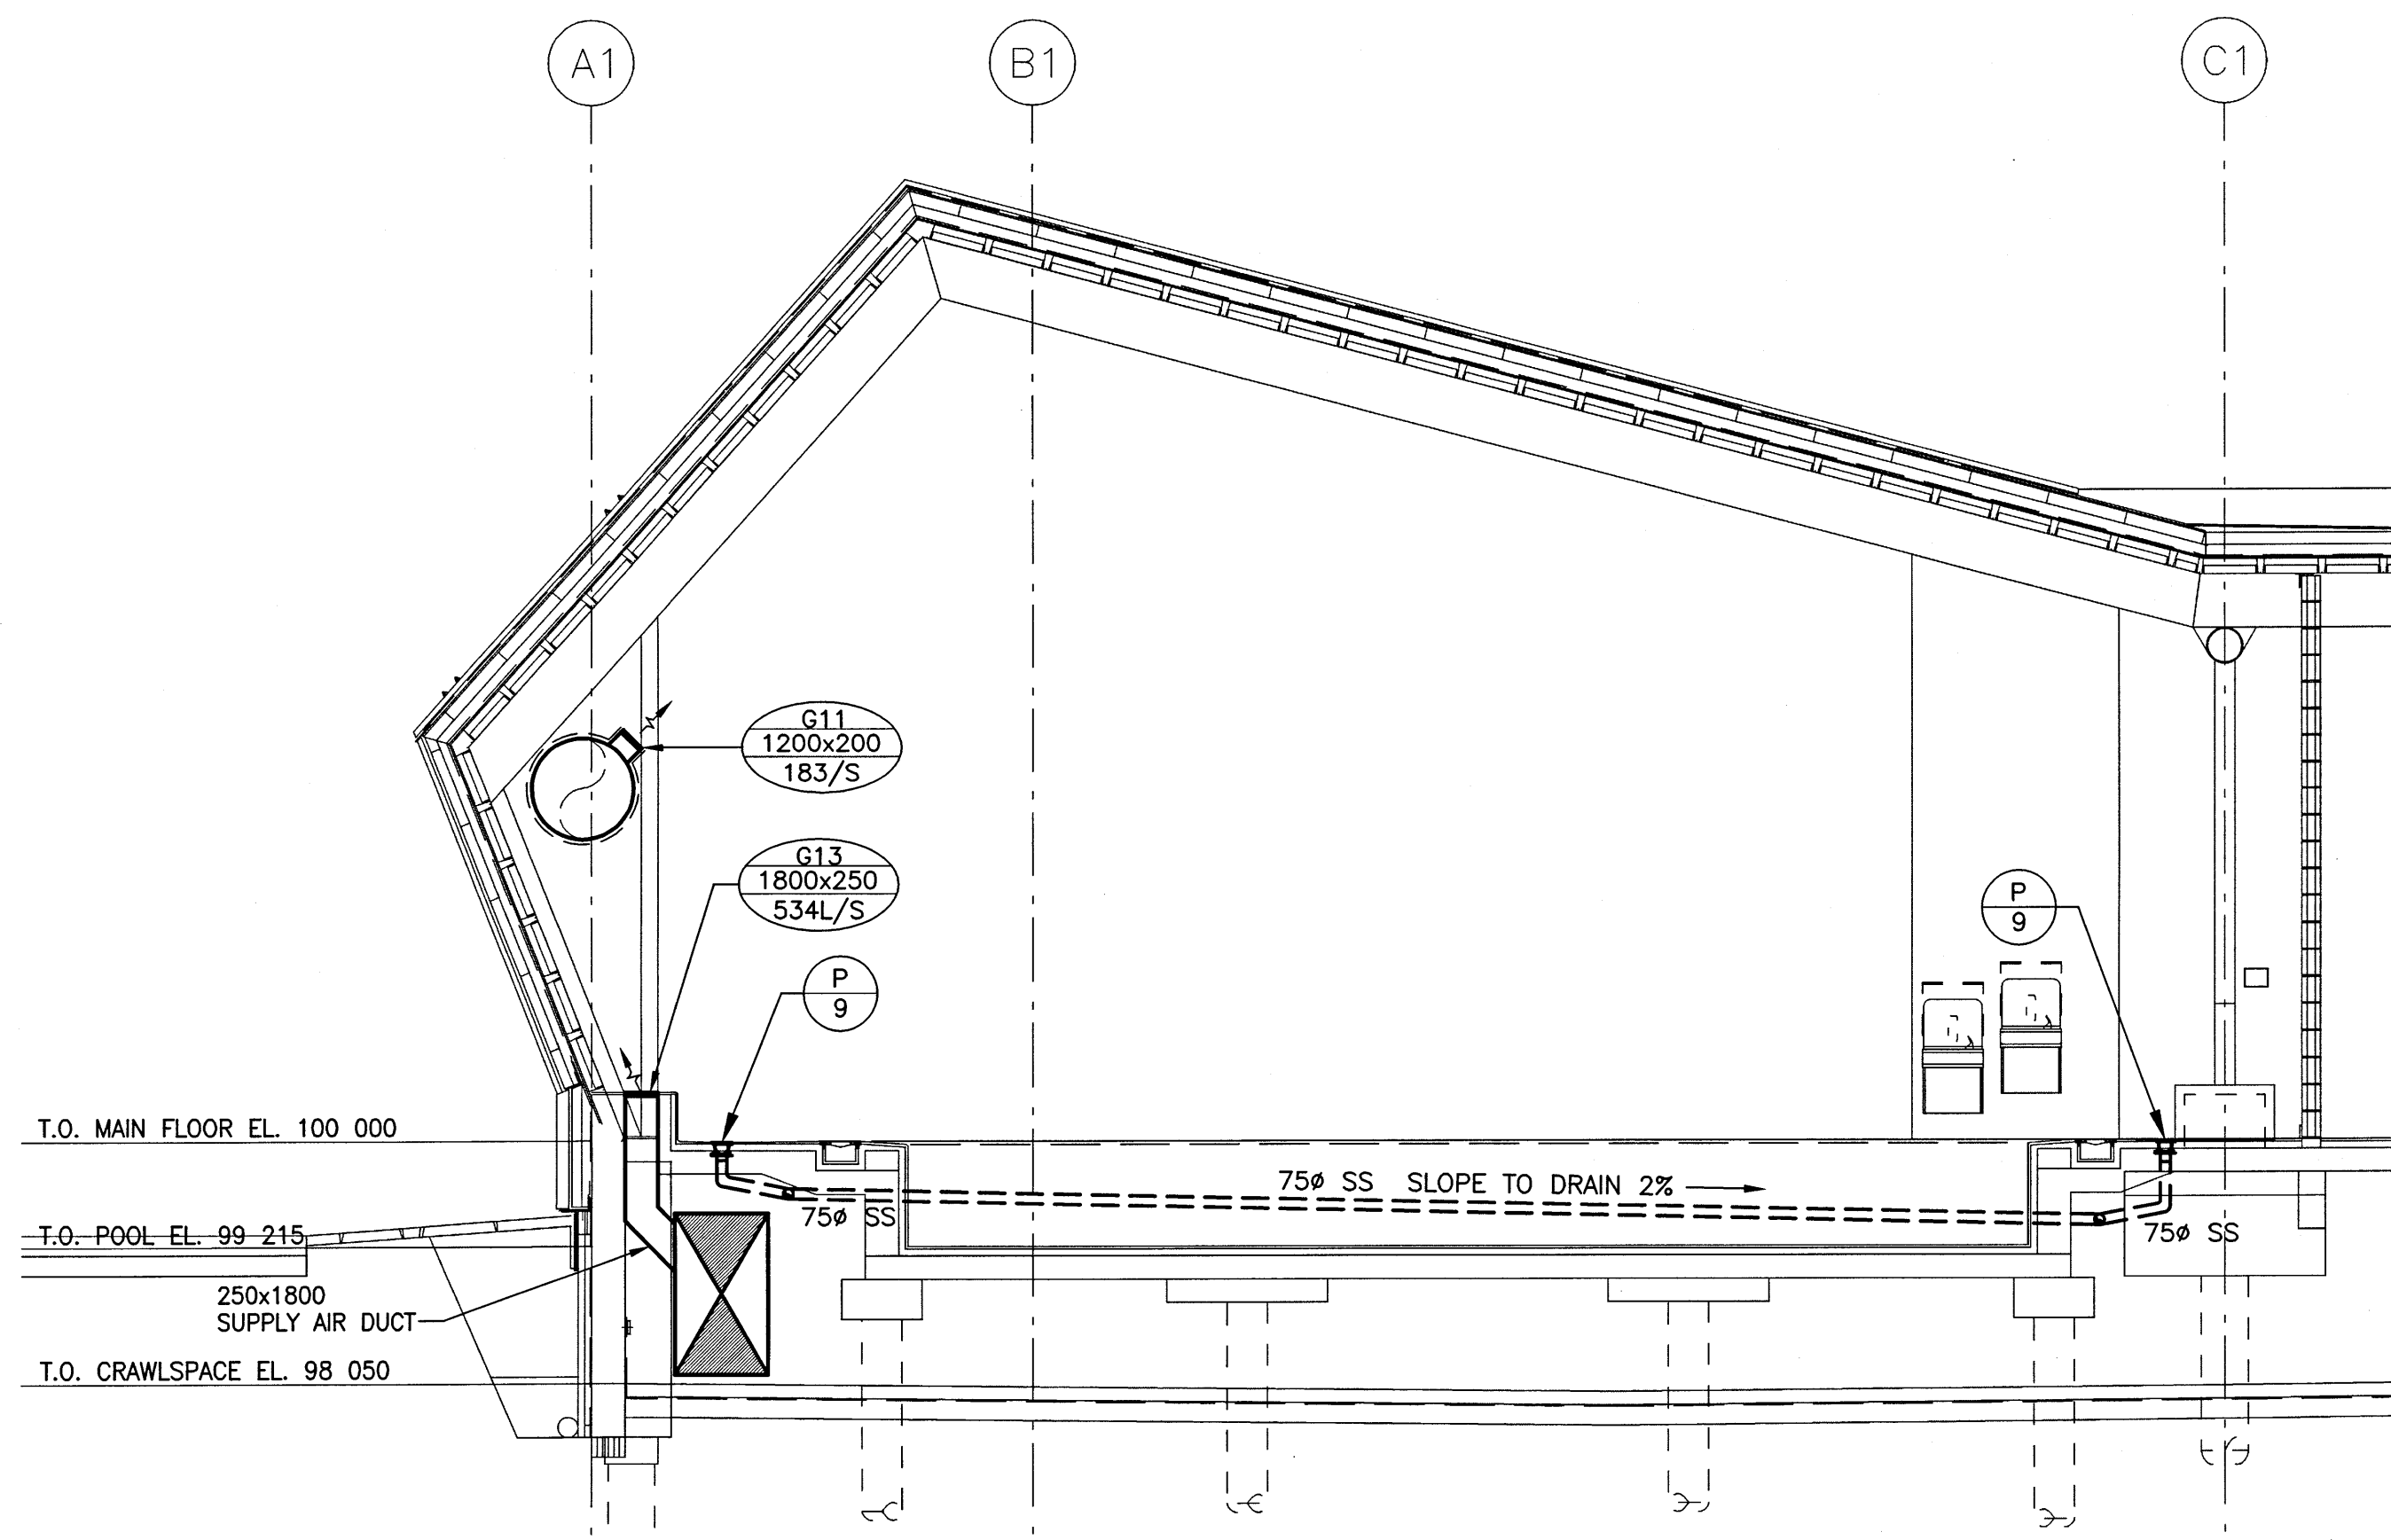

**3** POOL DRAINS SANITARY PIPING DETAIL  
M2-01 SCALE: N.T.S.

File Name: P:\Projects\2014\14-1736-008\DWG\Mech\14-1736-008\_M5-01.dwg - Tab: M5-01 Plotted By: ederoche 16/12/07 [Wed 3:41pm]



Printed on post-consumer recycled content paper.