

C:\9-1561-1
 File Name: P:\Projects\2016\16-0107-025\Draw\West\16-0107-025_M00.dwg - Tab: Rev: 00 Plotted By: adrosche_01/20/2017 [Fri: 11:15am]




THE CITY OF WINNIPEG

WATER AND WASTE DEPARTMENT

BID OPPORTUNITY NO. 1165-2016

Larchdale Flood Pumping Station Generator Replacement Project

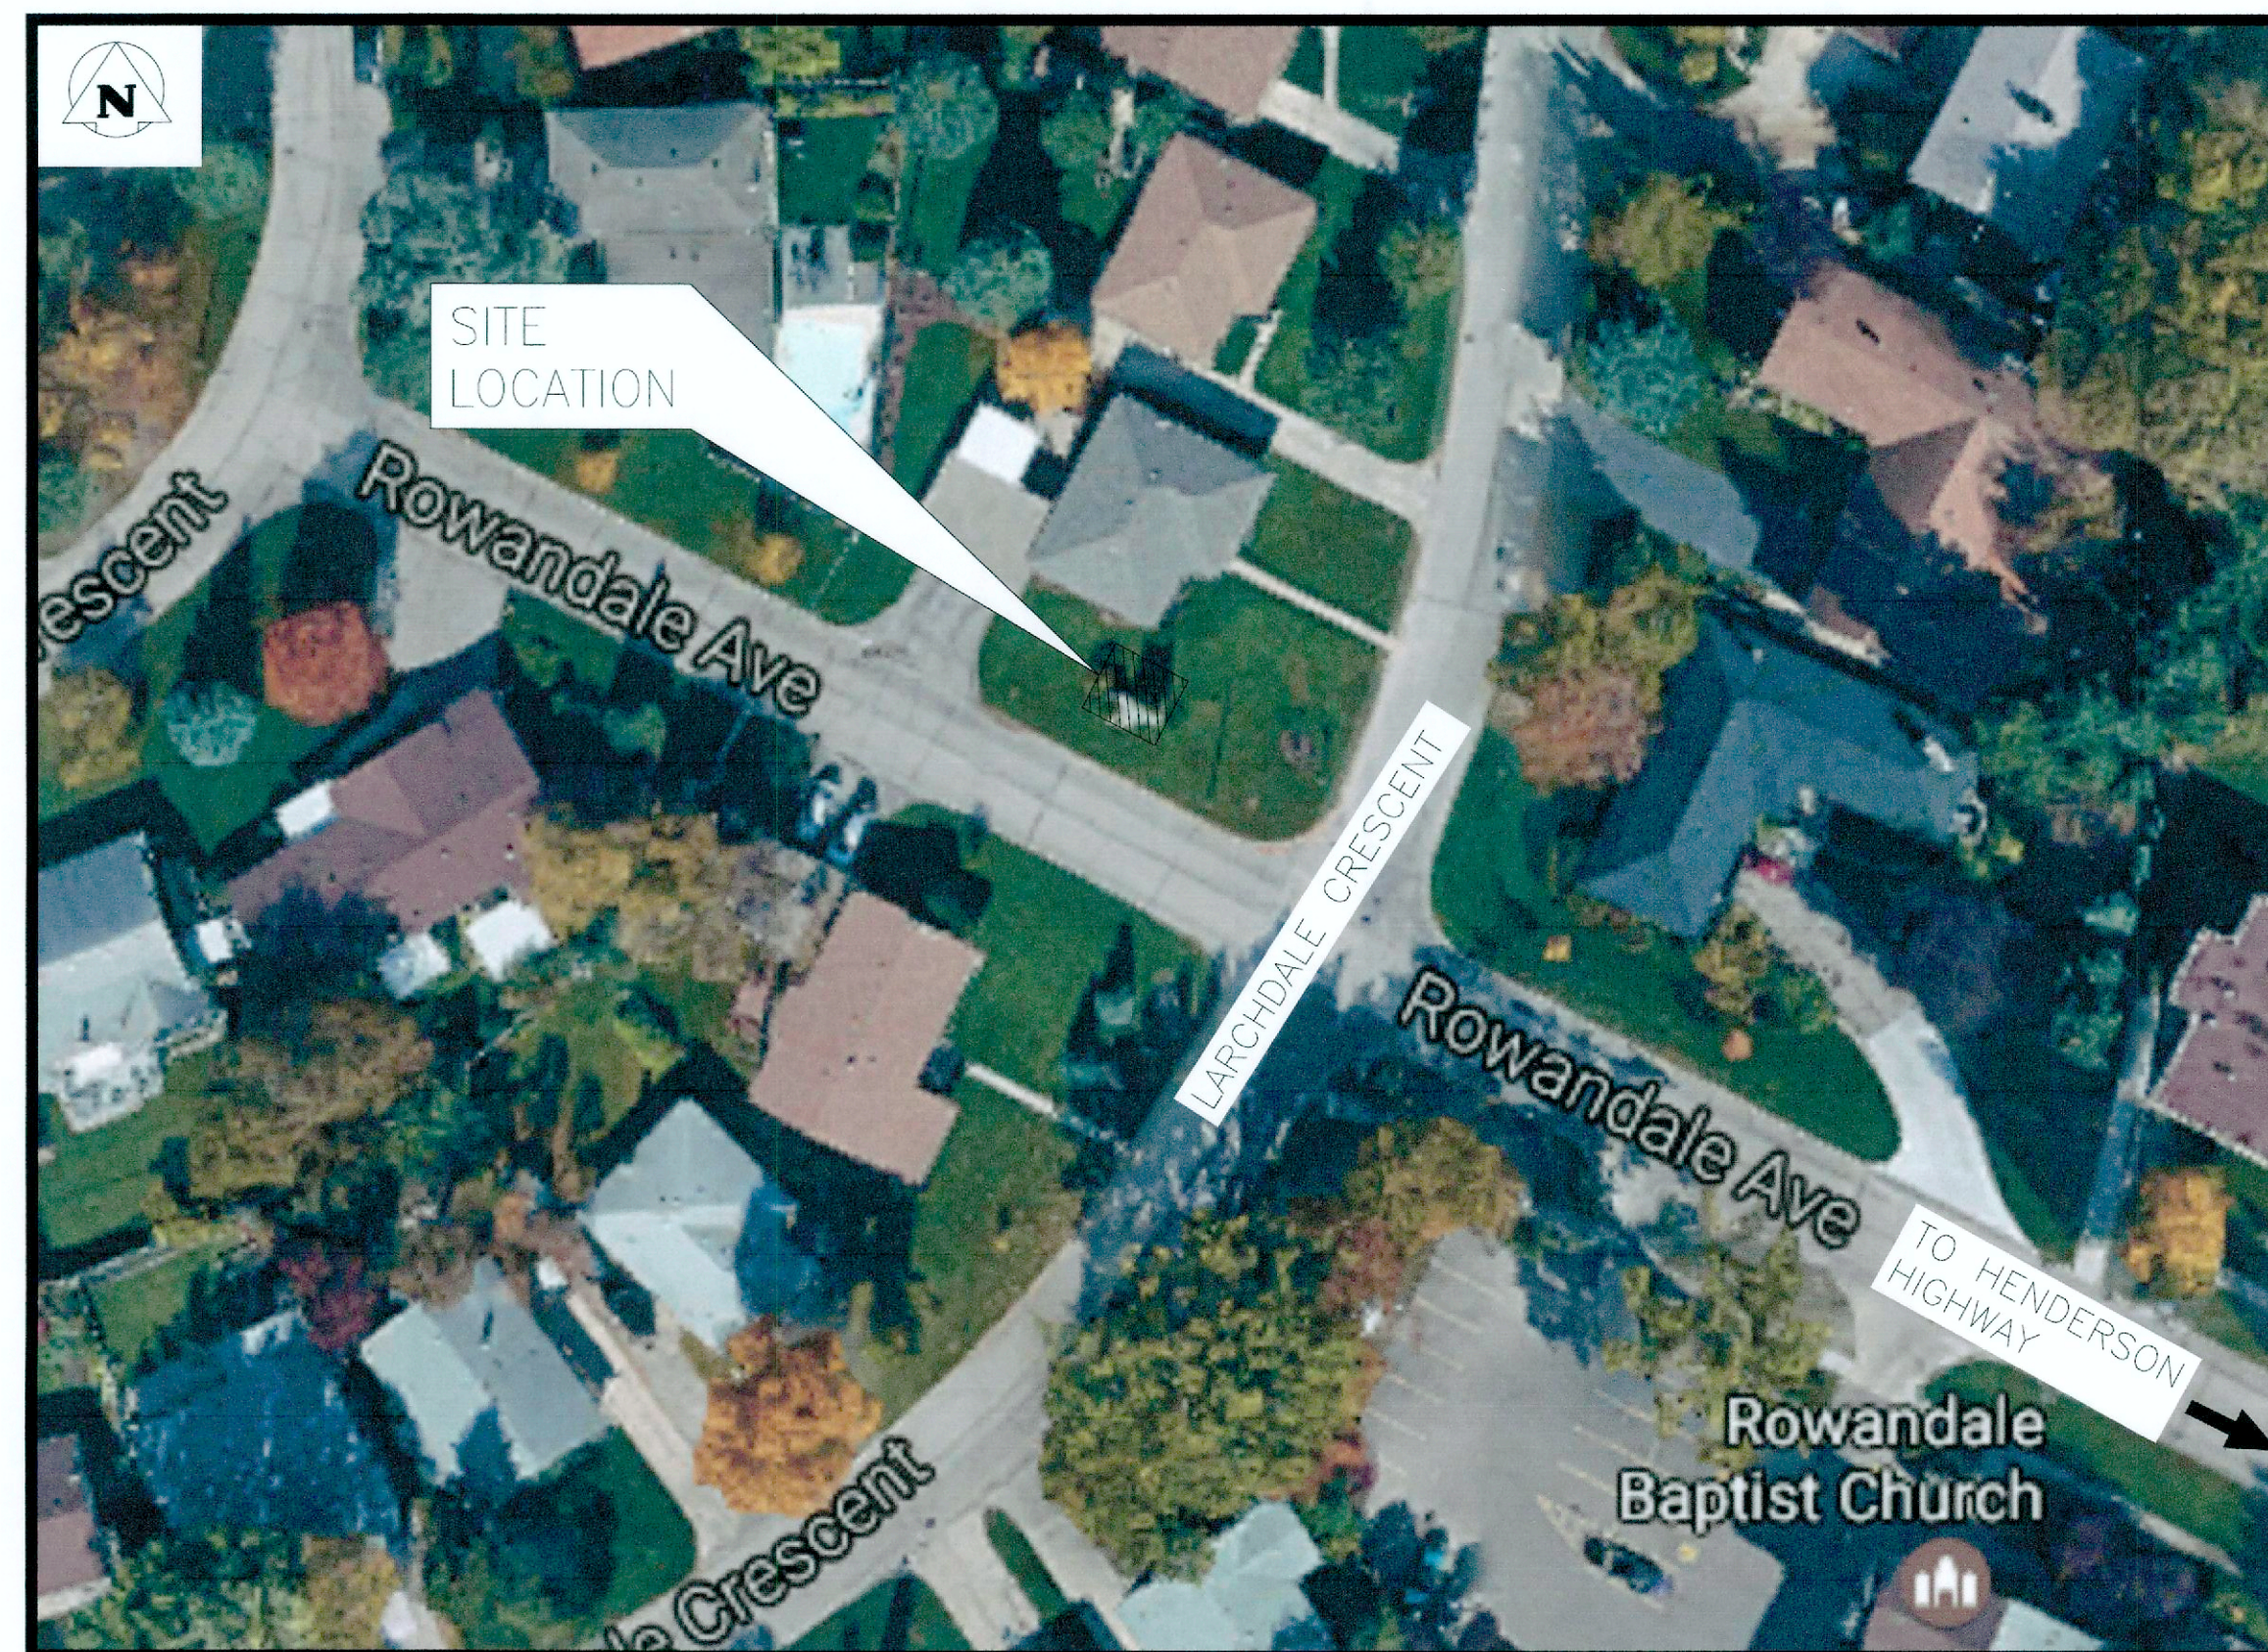

MECHANICAL

City of Winnipeg DWG No.	KGS Group DWG No.	DESCRIPTION	REV.
1-0153F-D0001-001		TITLE SHEET AND DRAWING LIST	
1-0153F-M0001-001	M01	MECHANICAL DEMOLITION DETAILS	00
1-0153F-M0002-001	M02	MECHANICAL EQUIPMENT LAYOUT	00

ELECTRICAL

City of Winnipeg DWG No.	KGS Group DWG No.	DESCRIPTION	REV.
1-0153F-E0001-001	E01	EQUIPMENT DEMOLITION PLAN	00
1-0153F-E0002-001	E02	NEW EQUIPMENT PLAN	00
1-0153F-E0003-001	E03	MOTOR CONTROL EXHAUST FAN MOTOR SCHEMATIC	00
1-0153F-E0004-001	E04	GAS DETECTION CONTROL PANEL SCHEMATIC	00
1-0153F-E0005-001	E05	MISCELLANEOUS WIRING SCHEMATICS	00
1-0153F-E0006-001	E06	ELECTRICAL PANEL SCHEDULES	00

CITY DRAWING NUMBER
 1-0153F-D0001-001

