



THE CITY OF WINNIPEG


PUBLIC WORKS DEPARTMENT

ENGINEERING DIVISION

2016 LOCAL STREETS PACKAGE

JESSIE AVENUE, MATHERS AVENUE & VARIOUS OTHER LOCATIONS

BID OPPORTUNITY No. 180-2016

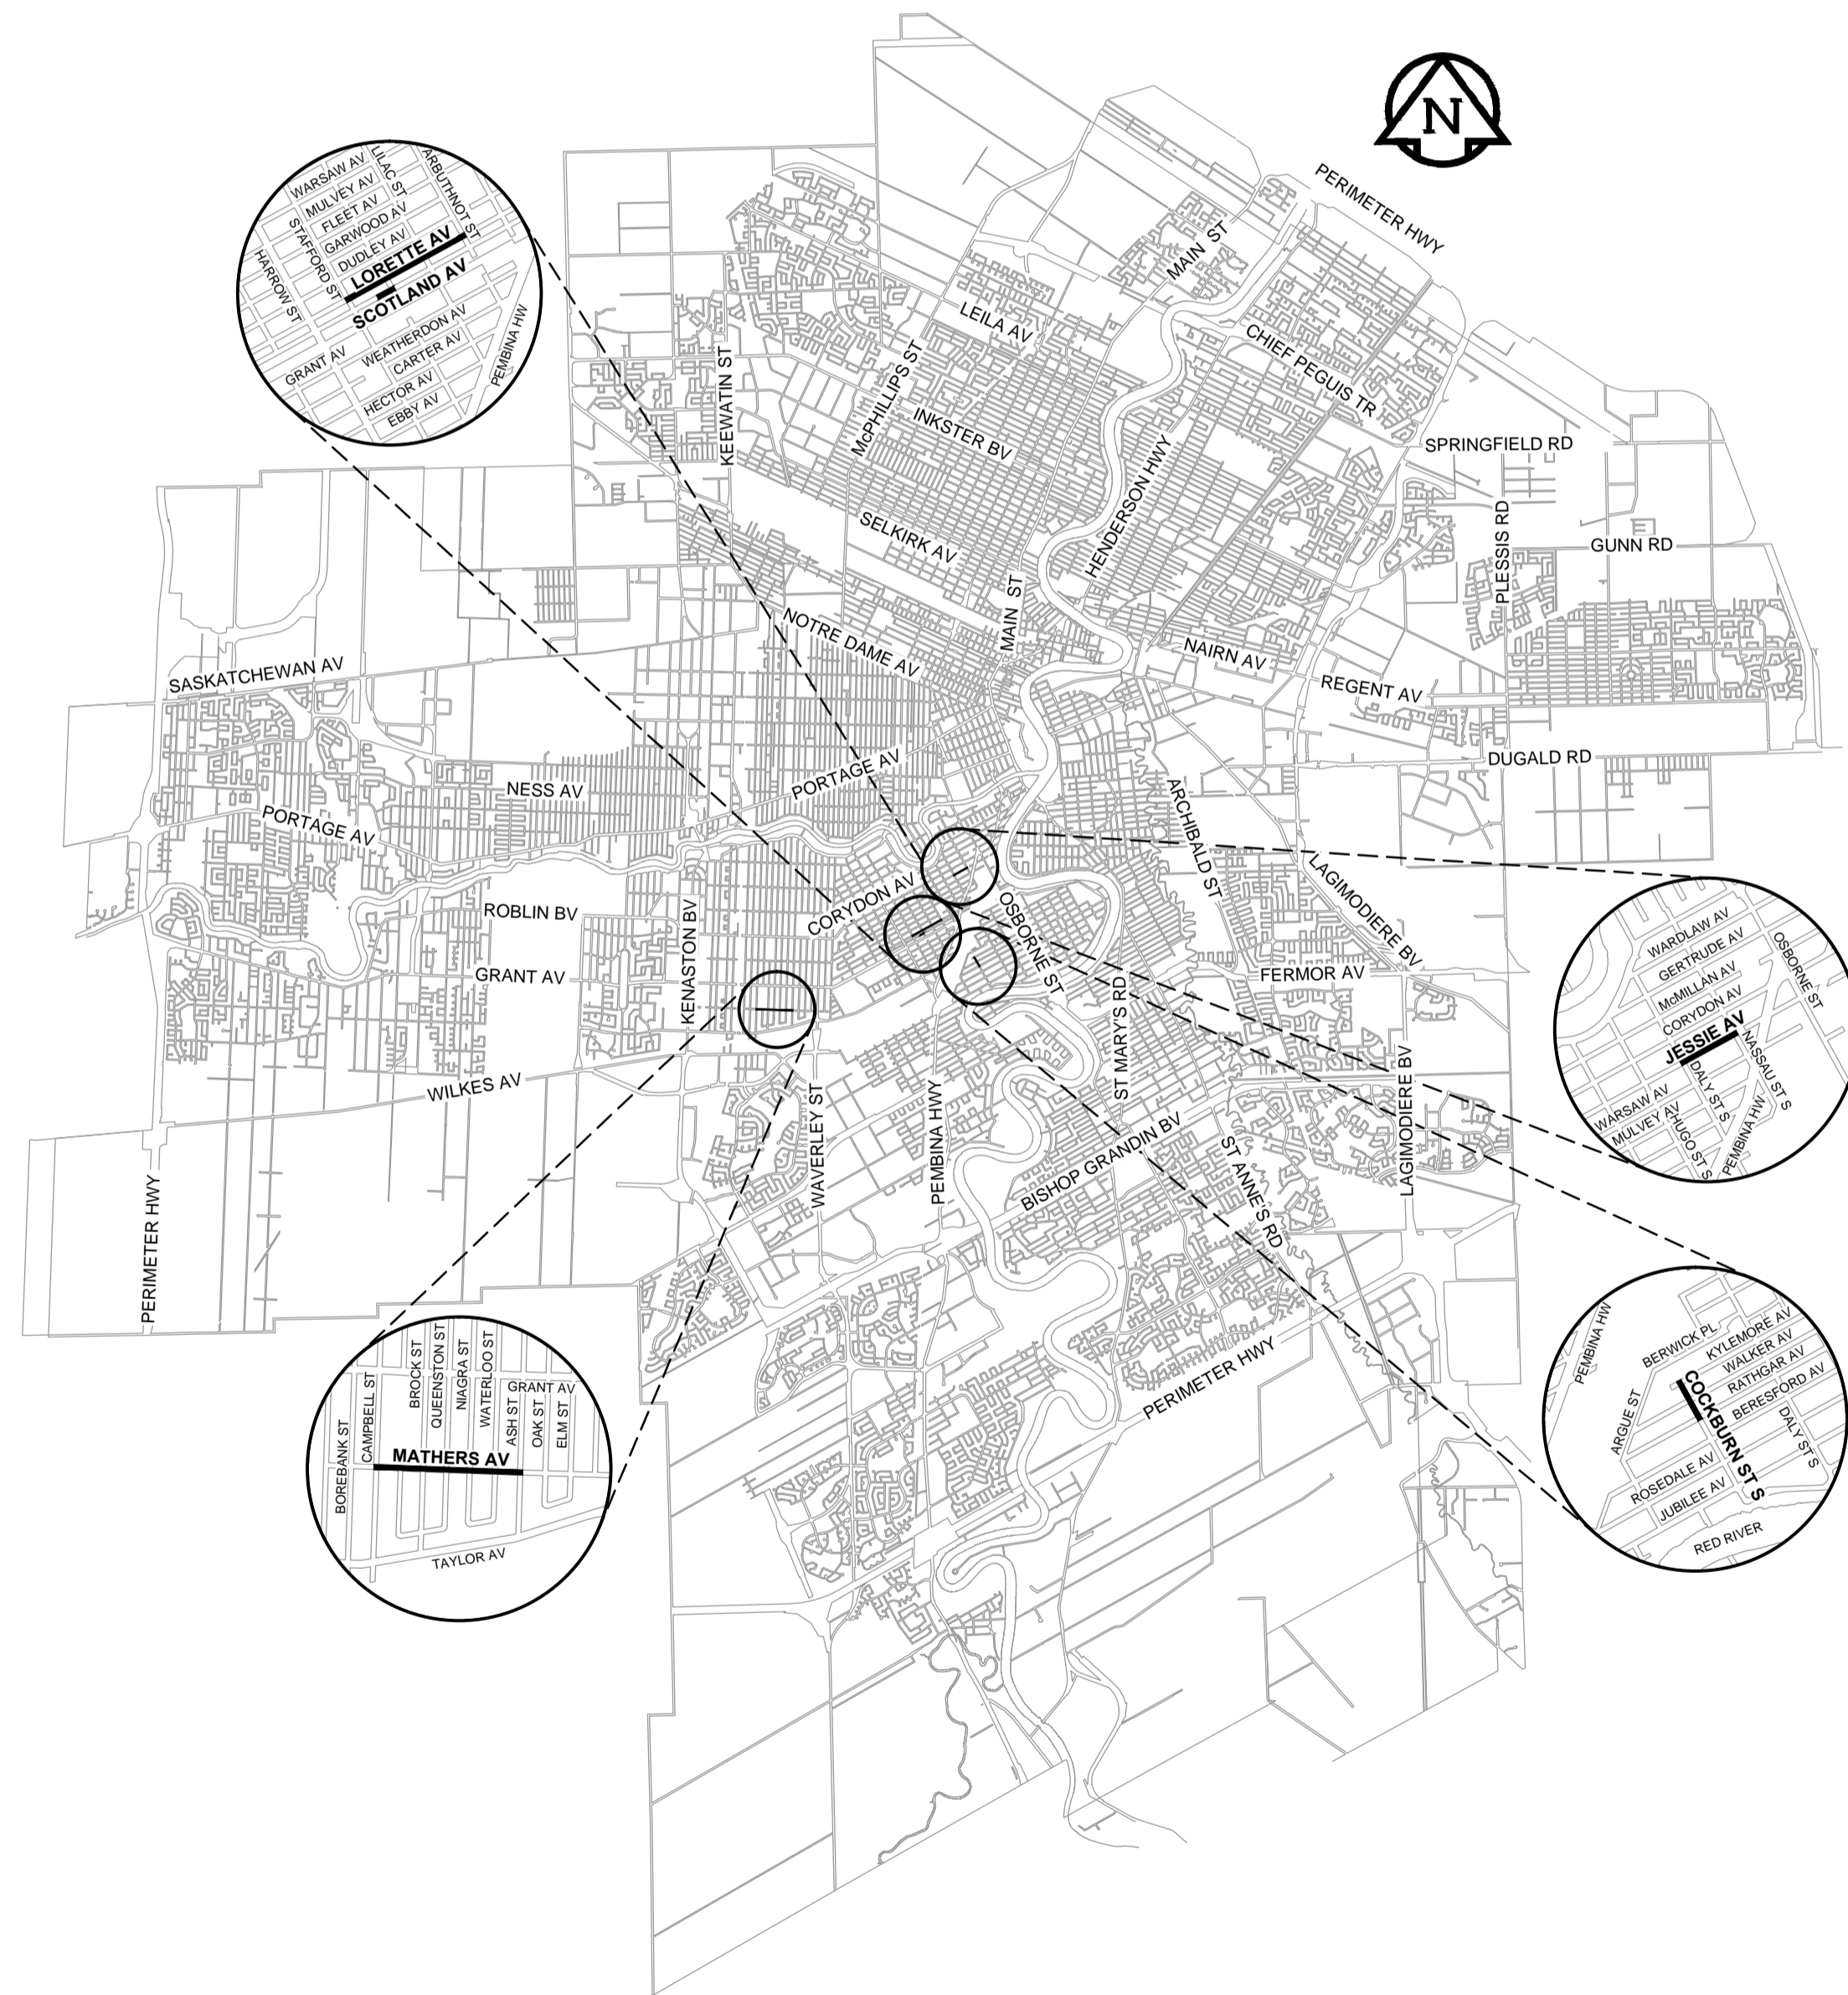

LOCATION PLAN
SCALE: 1:100,000
0 2500 5000m

DRAWING LIST

DRAWING NUMBER	DESCRIPTION
0	COVER SHEET AND LOCATION PLAN

**MATHERS AVENUE - CAMPBELL ST TO ASH ST
CONCRETE RECONSTRUCTION**

HORIZONTAL AND VERTICAL ALIGNMENT

1	CAMPBELL ST TO STA 0+190
2	STA 0+190 TO STA 0+310
3	STA 0+310 TO STA 0+410
4	STA 0+410 TO STA 0+520
5	STA 0+520 TO STA 0+610
6	STA 0+610 TO ASH ST

**LORETTE AVENUE - STAFFORD ST TO ARBUTHNOT ST
ASPHALT REHABILITATION**

HORIZONTAL AND VERTICAL ALIGNMENT

7	STAFFORD ST TO STA 0+200
8	STA 0+200 TO STA 0+310
9	STA 0+310 TO STA 0+420
10	STA 0+420 TO STA 0+540
11	STA 0+540 TO ARBUTHNOT ST

**SCOTLAND AVENUE - 50 m WEST OF WENTWORTH ST TO WENTWORTH ST
CONCRETE RECONSTRUCTION**

HORIZONTAL AND VERTICAL ALIGNMENT

12	STA 0+030 TO WENTWORTH ST
----	---------------------------

**JESSIE AVENUE - DALY ST N TO NASSAU ST N
CONCRETE RECONSTRUCTION**

HORIZONTAL AND VERTICAL ALIGNMENT

13	DALY ST N TO STA 0+180
14	STA 0+180 TO STA 0+280
15	STA 0+280 TO NASSAU ST N

**COCKBURN STREET SOUTH - RATHGAR AV TO KYLEMORE AV
ASPHALT RECONSTRUCTION**

HORIZONTAL AND VERTICAL ALIGNMENT

16	RATHGAR AV TO STA 0+170
17	STA 0+170 TO KYLEMORE AV

LORETTE AVENUE - SEWER REPAIRS

11292	375 CLAY CS POINT REPAIR MH AT STAFFORD ST TO 1st MH W OF WENTWORTH ST
11293	450 CLAY CS POINT REPAIR MH AT WENTWORTH ST TO 1st MH W OF LILAC ST

SCOTLAND AVENUE - SEWER REPAIRS

11294	375 CLAY CS POINT REPAIR 1st MH W OF WENTWORTH ST TO MH AT WENTWORTH ST
-------	--


STREET LIGHTING PROJECT

1-04707-DE-50000-0283 0001	JESSIE AVENUE - DALY ST N TO NASSAU ST N (CONTRACTOR TO REPLACE EXISTING UNDERGROUND STREET LIGHTING PLANT)
----------------------------	--

RELEASED FOR CONSTRUCTION BY:

STREETS PROJECT ENGINEER

DATE

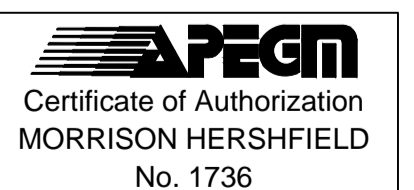

COVER SHEET AND LOCATION PLAN

CITY DRAWING No. N/A REV C

CONSULTANT NO. W160015-Cover Sheet.dwg