



THE CITY OF WINNIPEG


PUBLIC WORKS DEPARTMENT

ENGINEERING DIVISION


2016 LOCAL STREETS PACKAGE

JESSIE AVENUE, MATHERS AVENUE & VARIOUS OTHER LOCATIONS

BID OPPORTUNITY No. 180-2016

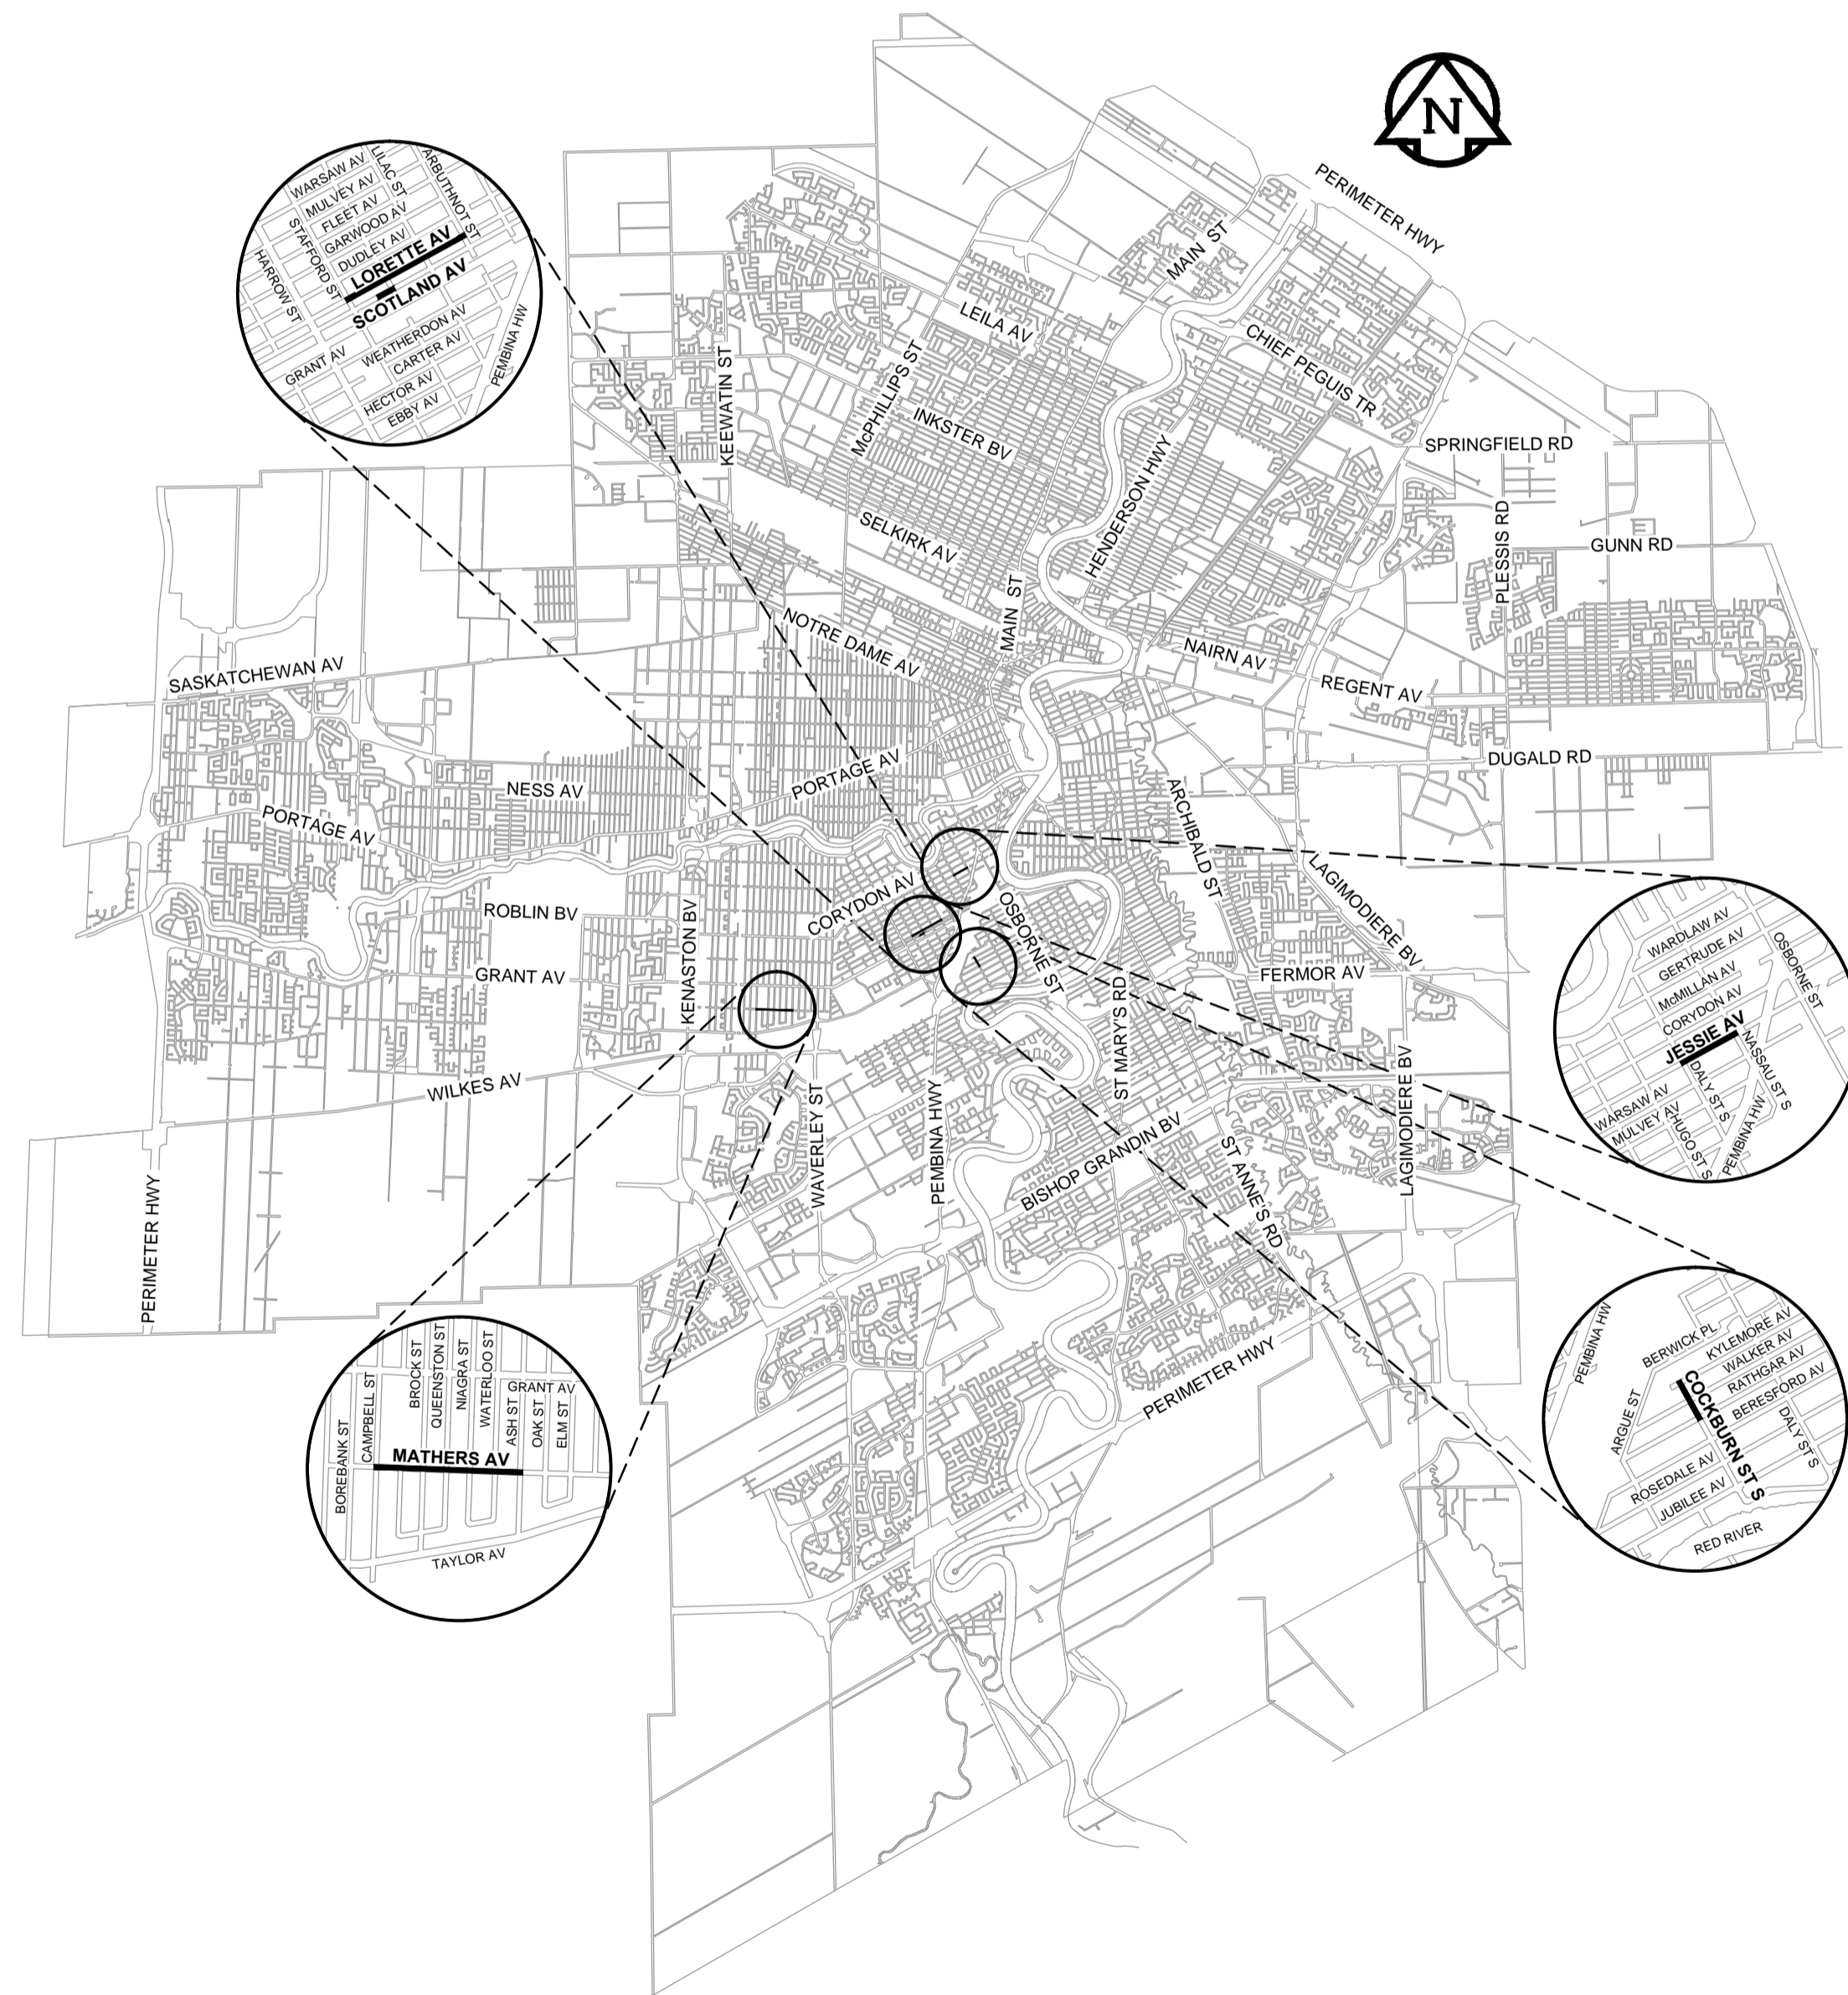

LOCATION PLAN

 

DRAWING LIST

DRAWING NUMBER DESCRIPTION

0 COVER SHEET AND LOCATION PLAN

**MATHERS AVENUE - CAMPBELL ST TO ASH ST
CONCRETE RECONSTRUCTION**

HORIZONTAL AND VERTICAL ALIGNMENT

- 1 CAMPBELL ST TO STA 0+190
- 2 STA 0+190 TO STA 0+310
- 3 STA 0+310 TO STA 0+410
- 4 STA 0+410 TO STA 0+520
- 5 STA 0+520 TO STA 0+610
- 6 STA 0+610 TO ASH ST

**LORETTE AVENUE - STAFFORD ST TO ARBUTHNOT ST
ASPHALT REHABILITATION**

HORIZONTAL AND VERTICAL ALIGNMENT

- 7 STAFFORD ST TO STA 0+200
- 8 STA 0+200 TO STA 0+310
- 9 STA 0+310 TO STA 0+420
- 10 STA 0+420 TO STA 0+540
- 11 STA 0+540 TO ARBUTHNOT ST

**SCOTLAND AVENUE - 50 m WEST OF WENTWORTH ST TO WENTWORTH ST
CONCRETE RECONSTRUCTION**

HORIZONTAL AND VERTICAL ALIGNMENT

- 12 STA 0+030 TO WENTWORTH ST

**JESSIE AVENUE - DALY ST N TO NASSAU ST N
CONCRETE RECONSTRUCTION**

HORIZONTAL AND VERTICAL ALIGNMENT

- 13 DALY ST N TO STA 0+180
- 14 STA 0+180 TO STA 0+280
- 15 STA 0+280 TO NASSAU ST N

**COCKBURN STREET SOUTH - RATHGAR AV TO KYLEMORE AV
ASPHALT RECONSTRUCTION**

HORIZONTAL AND VERTICAL ALIGNMENT

- 16 RATHGAR AV TO STA 0+170
- 17 STA 0+170 TO KYLEMORE AV

STREET LIGHTING PROJECT

1-04707-DE-50000-0283 0001 JESSIE AVENUE - DALY ST N TO NASSAU ST N
(CONTRACTOR TO REPLACE EXISTING UNDERGROUND STREET LIGHTING PLANT)

RELEASED FOR CONSTRUCTION BY:

STREETS PROJECT ENGINEER

DATE



COVER SHEET AND LOCATION PLAN

CITY DRAWING No.	REV
N/A	B

CONSULTANT NO. W160015-Cover Sheet.dwg