




1 SITE PLAN
SCALE -- 1 : 300

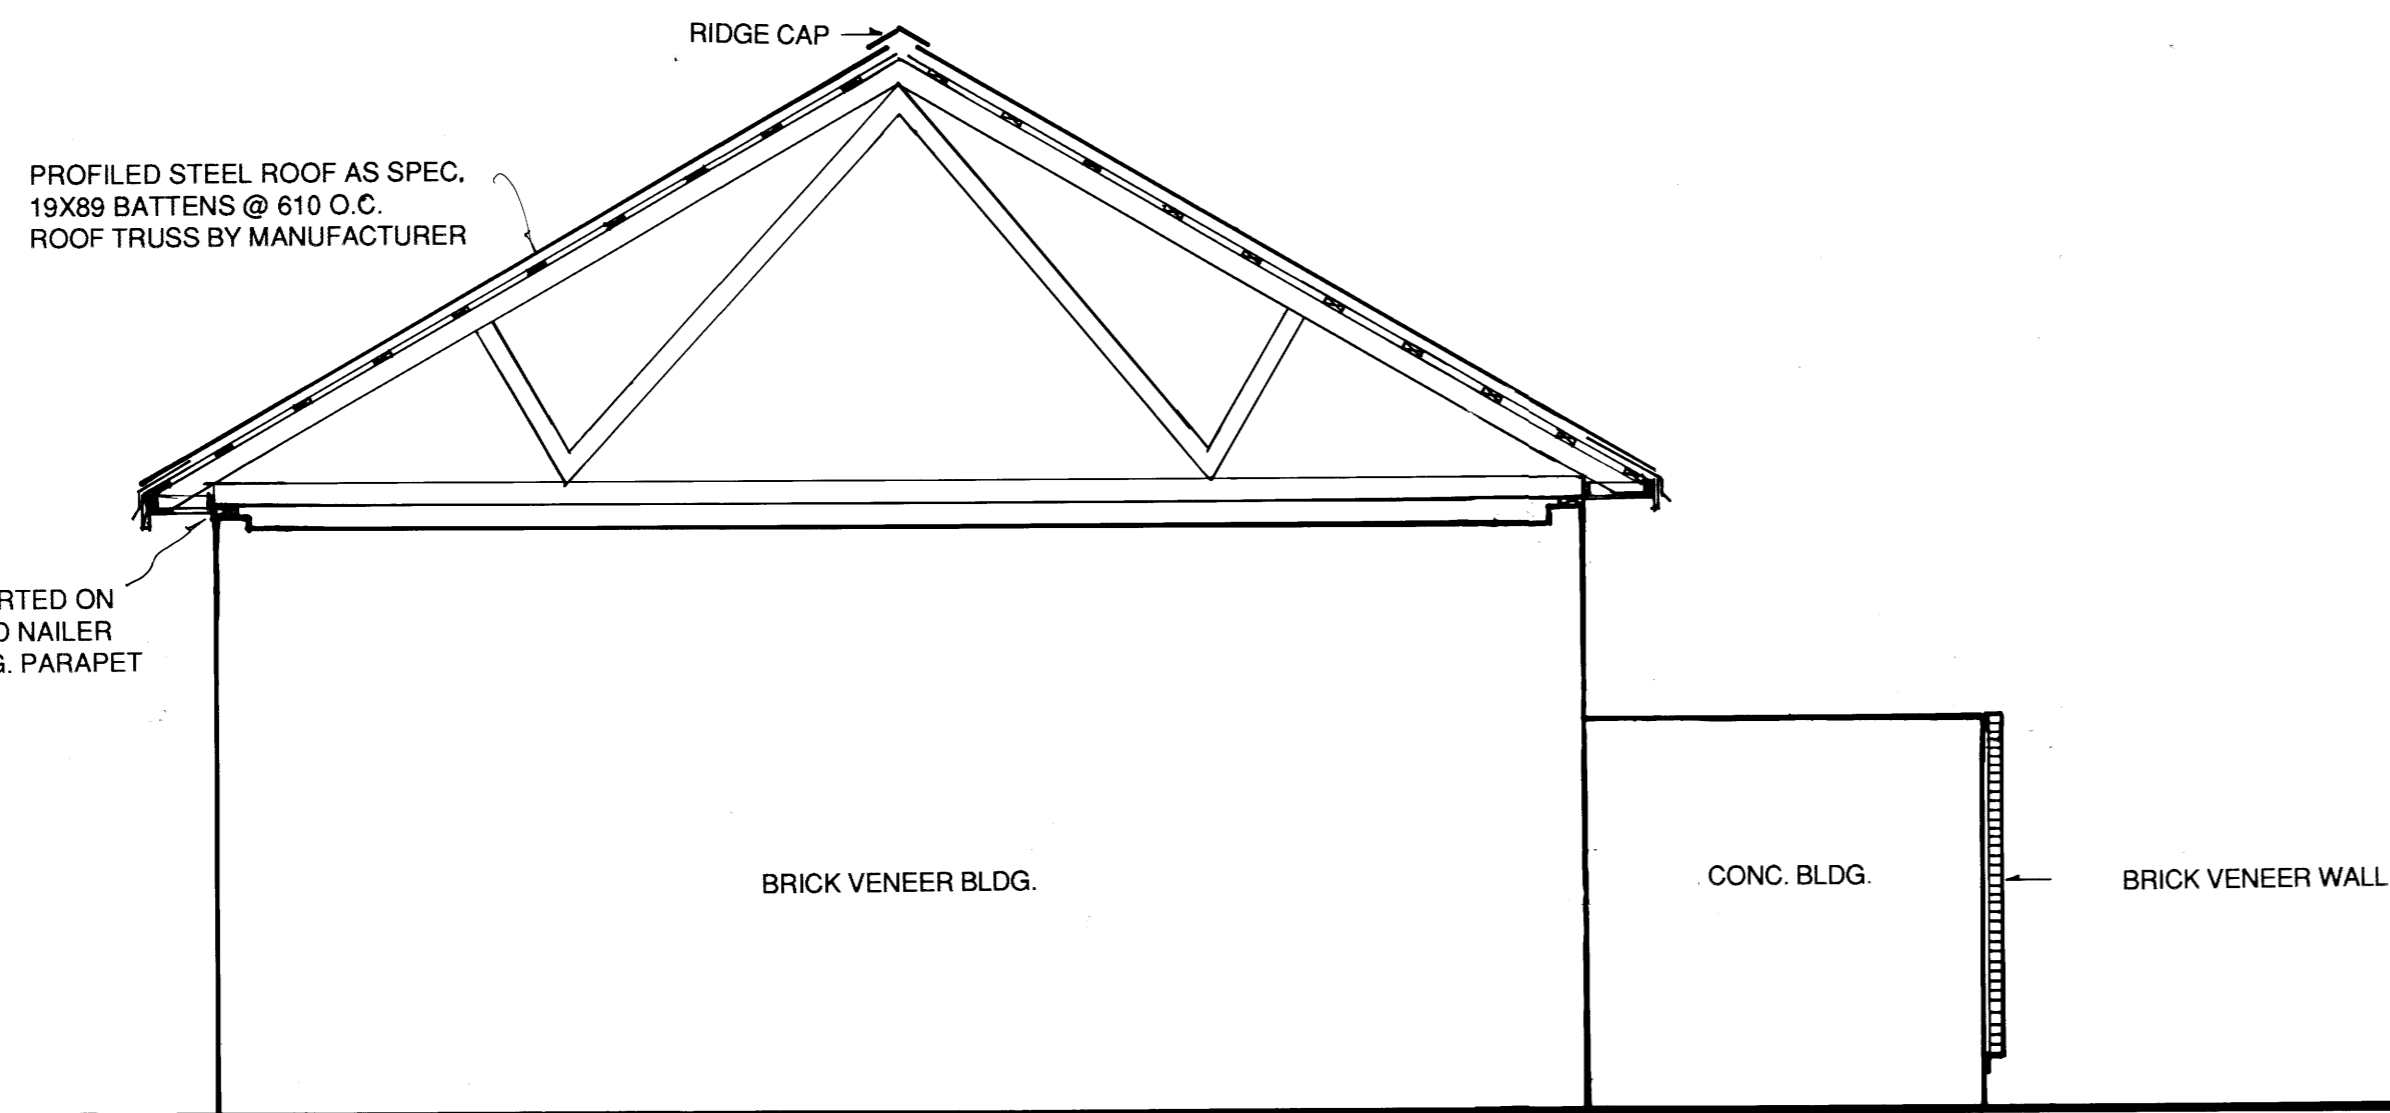

2 BUILDING SECTION
SCALE -- 1 : 50

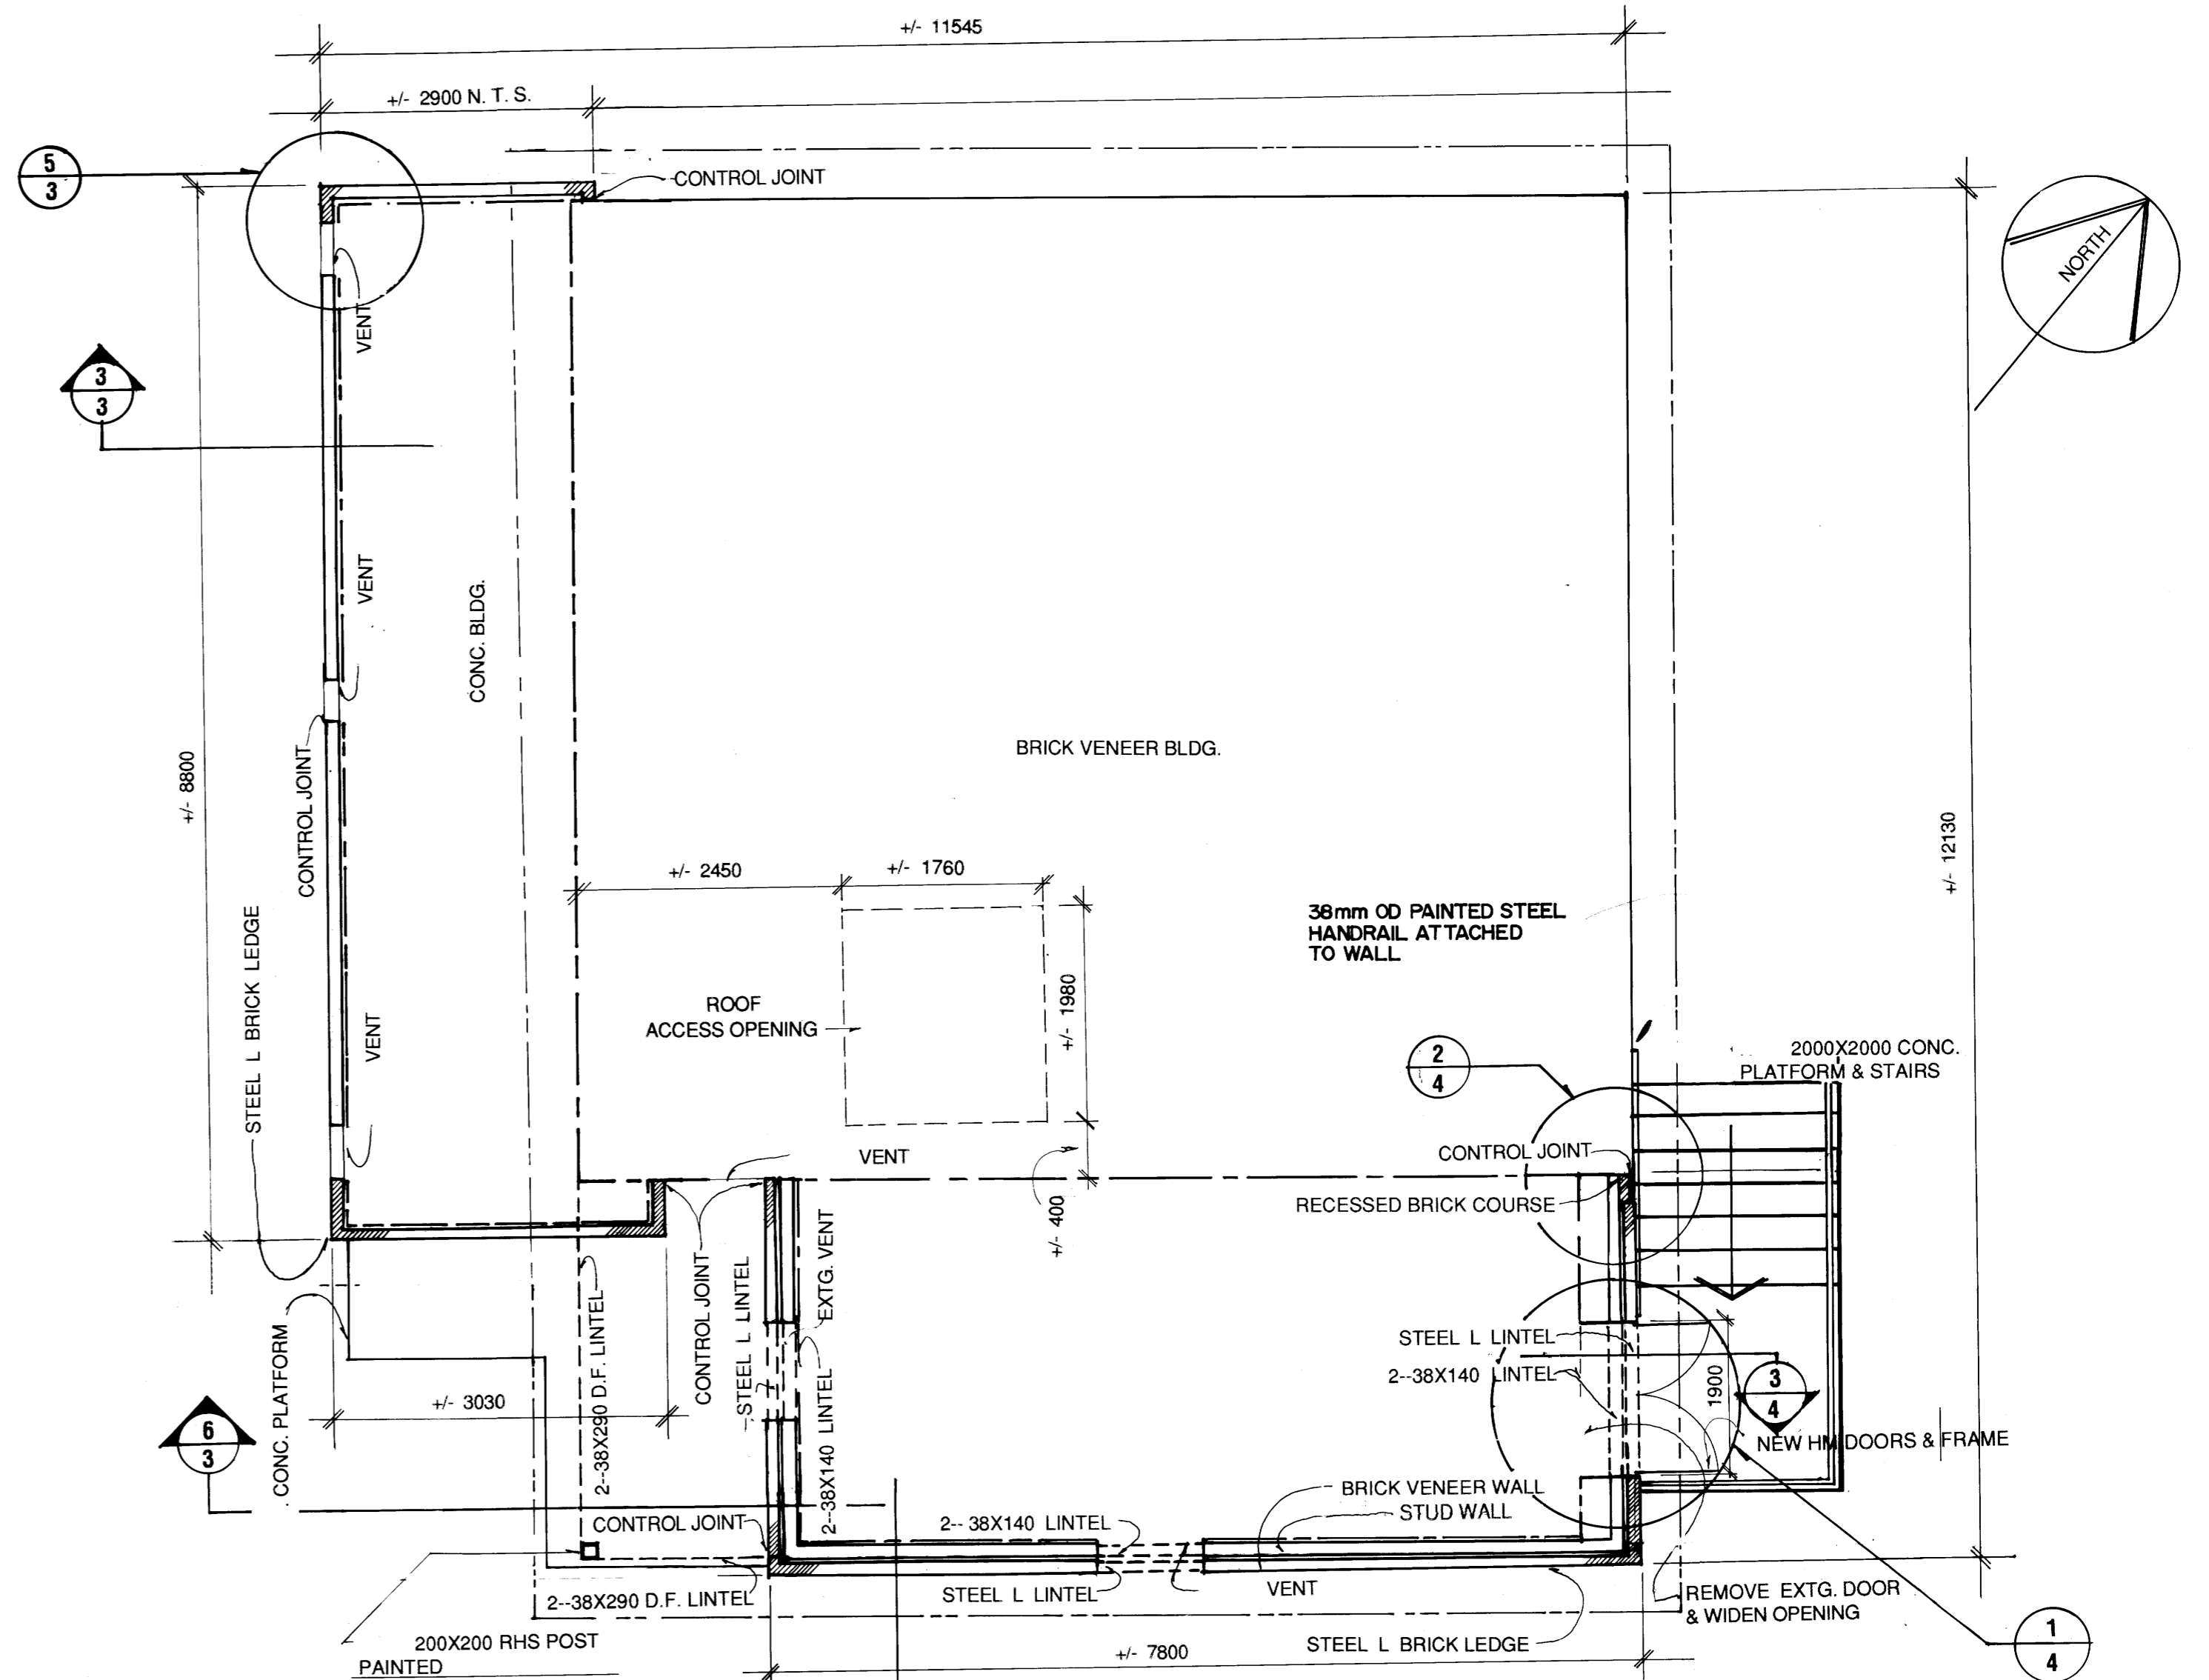

3 PLAN
SCALE -- 1 : 50

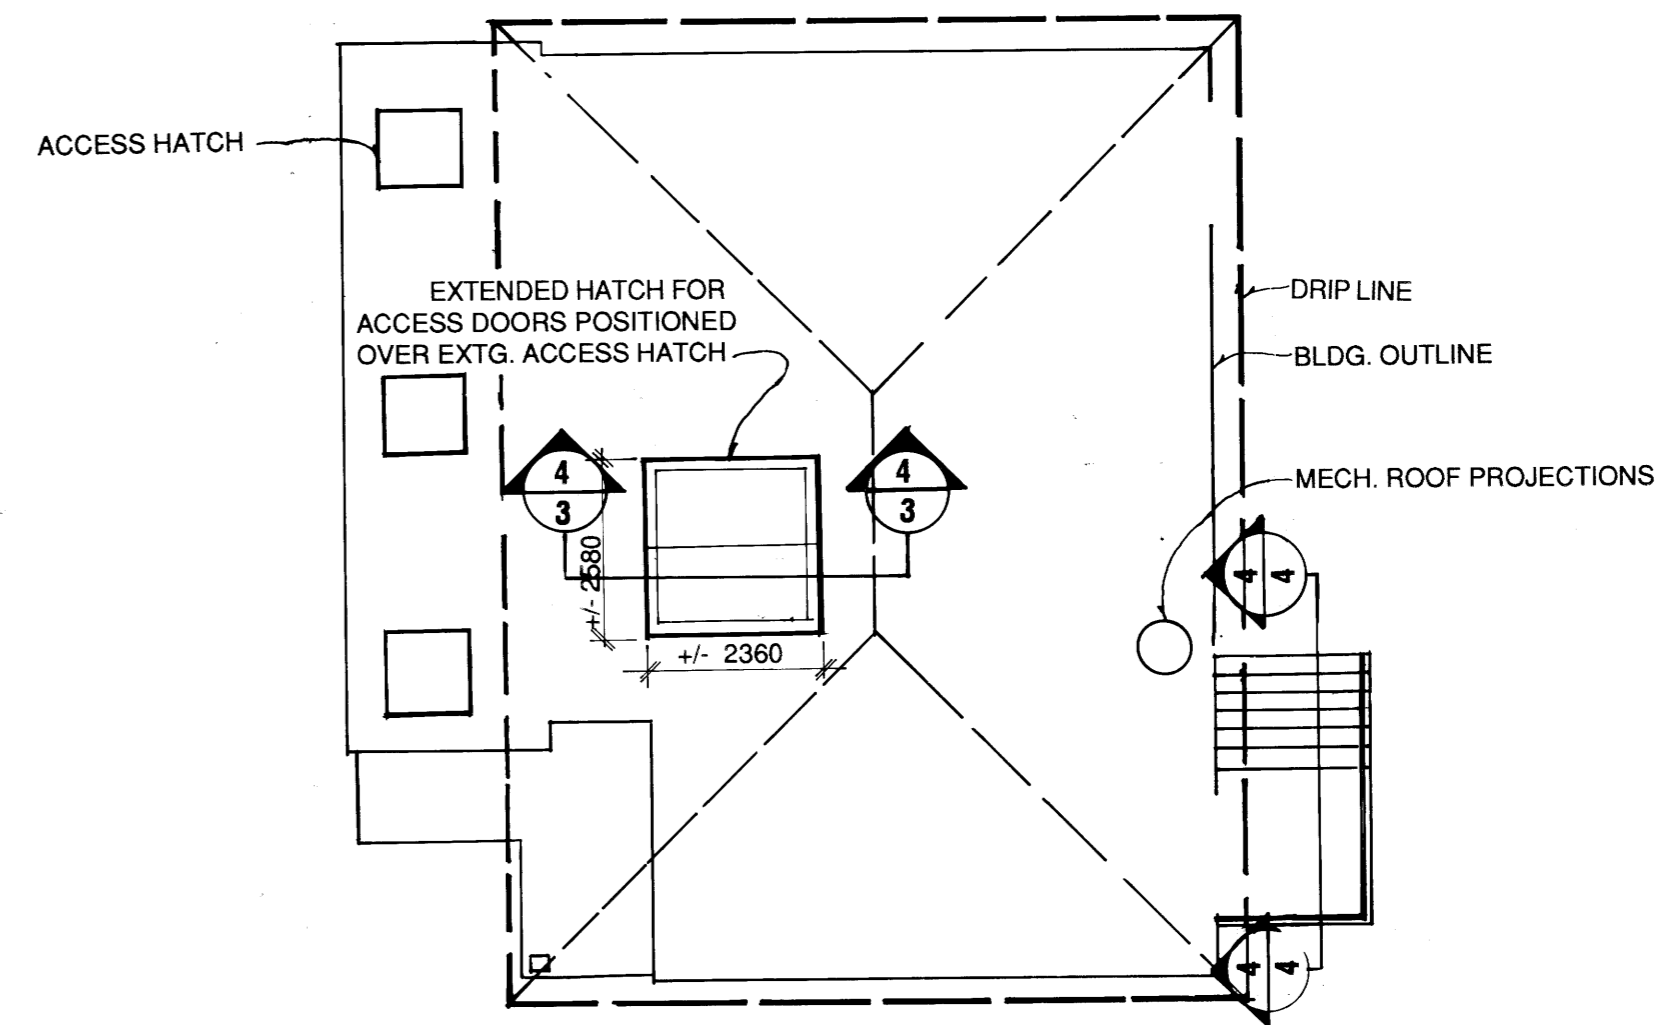

4 ROOF PLAN
SCALE -- 1 : 100

REF. or DRAWING No. **LD 959**

FILE # **LD 10311**


DETAILS

NO.	REVISIONS	DATE	BY
A	AS CONSTRUCTED	10 22 90	OP

LLEWELIN SIMON ASSOCIATES
403-63 Albert St. Winnipeg, MB R3B 1G4 (204) 947-9301
LANDSCAPE ARCHITECTURE • URBAN DESIGN • ARCHITECTURE

DESIGNED BY: **TPLL**
DRAWN BY: **KR**
HOR SCALE: **AS SHOWN**
VERTICAL: **AS SHOWN**
DATE: **FEB. 1989**

CHECKED BY: *[Signature]*
APPROVED BY: *[Signature]*
RELEASED FOR CONSTRUCTION: *[Signature]*
DATE: **FEB 16/89**

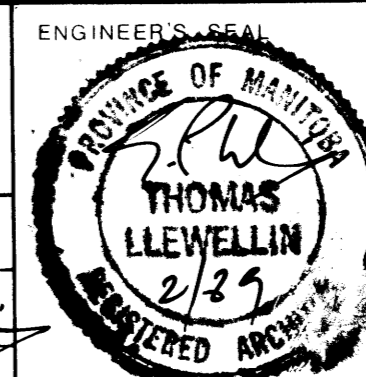

CONSULTANT, DRAWING NO. **8709 - A1**

THE CITY OF WINNIPEG
WORKS AND OPERATIONS DIVISION
WATERWORKS, WASTE & DISPOSAL

COCKBURN ST. PUMPING STATION
ARCHITECTURAL IMPROVEMENTS &
SITE LANDSCAPING

SITE PLAN, BUILDING PLAN & SECTION

CITY DRAWING NUMBER
LD - 959
SHEET **2** OF **8**