




1 ROOF FRAMING PLAN
SCALE -- 1:100

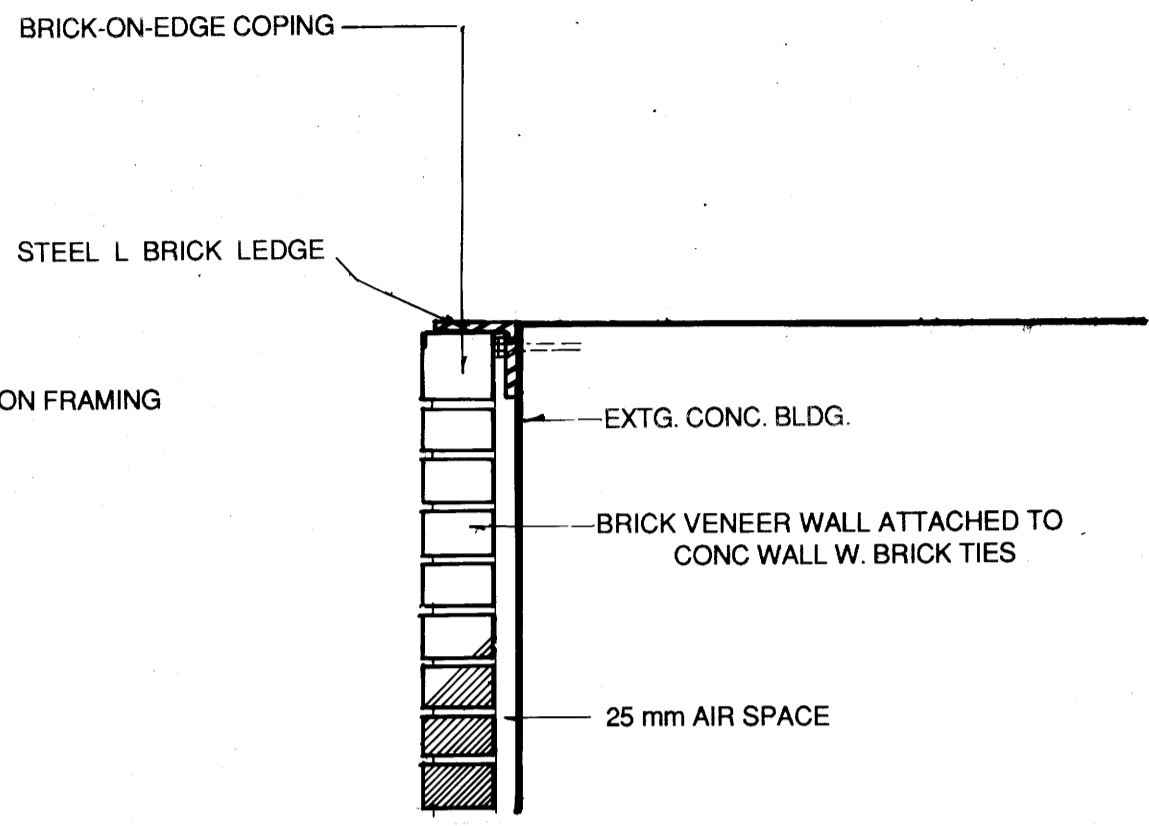


3 SECTION DETAIL : BRICK COPING
SCALE -- 1:10

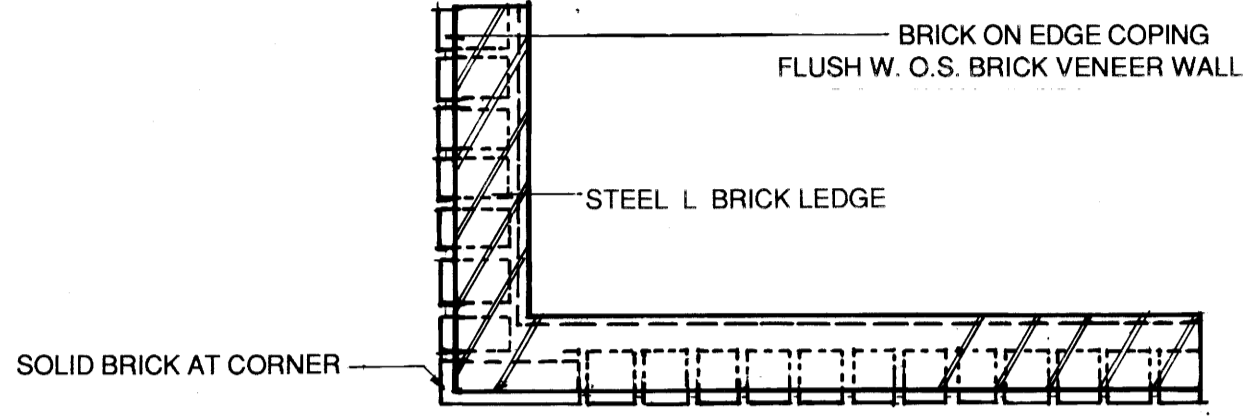


5 PLAN DETAIL : BRICK COPING
SCALE -- 1:10

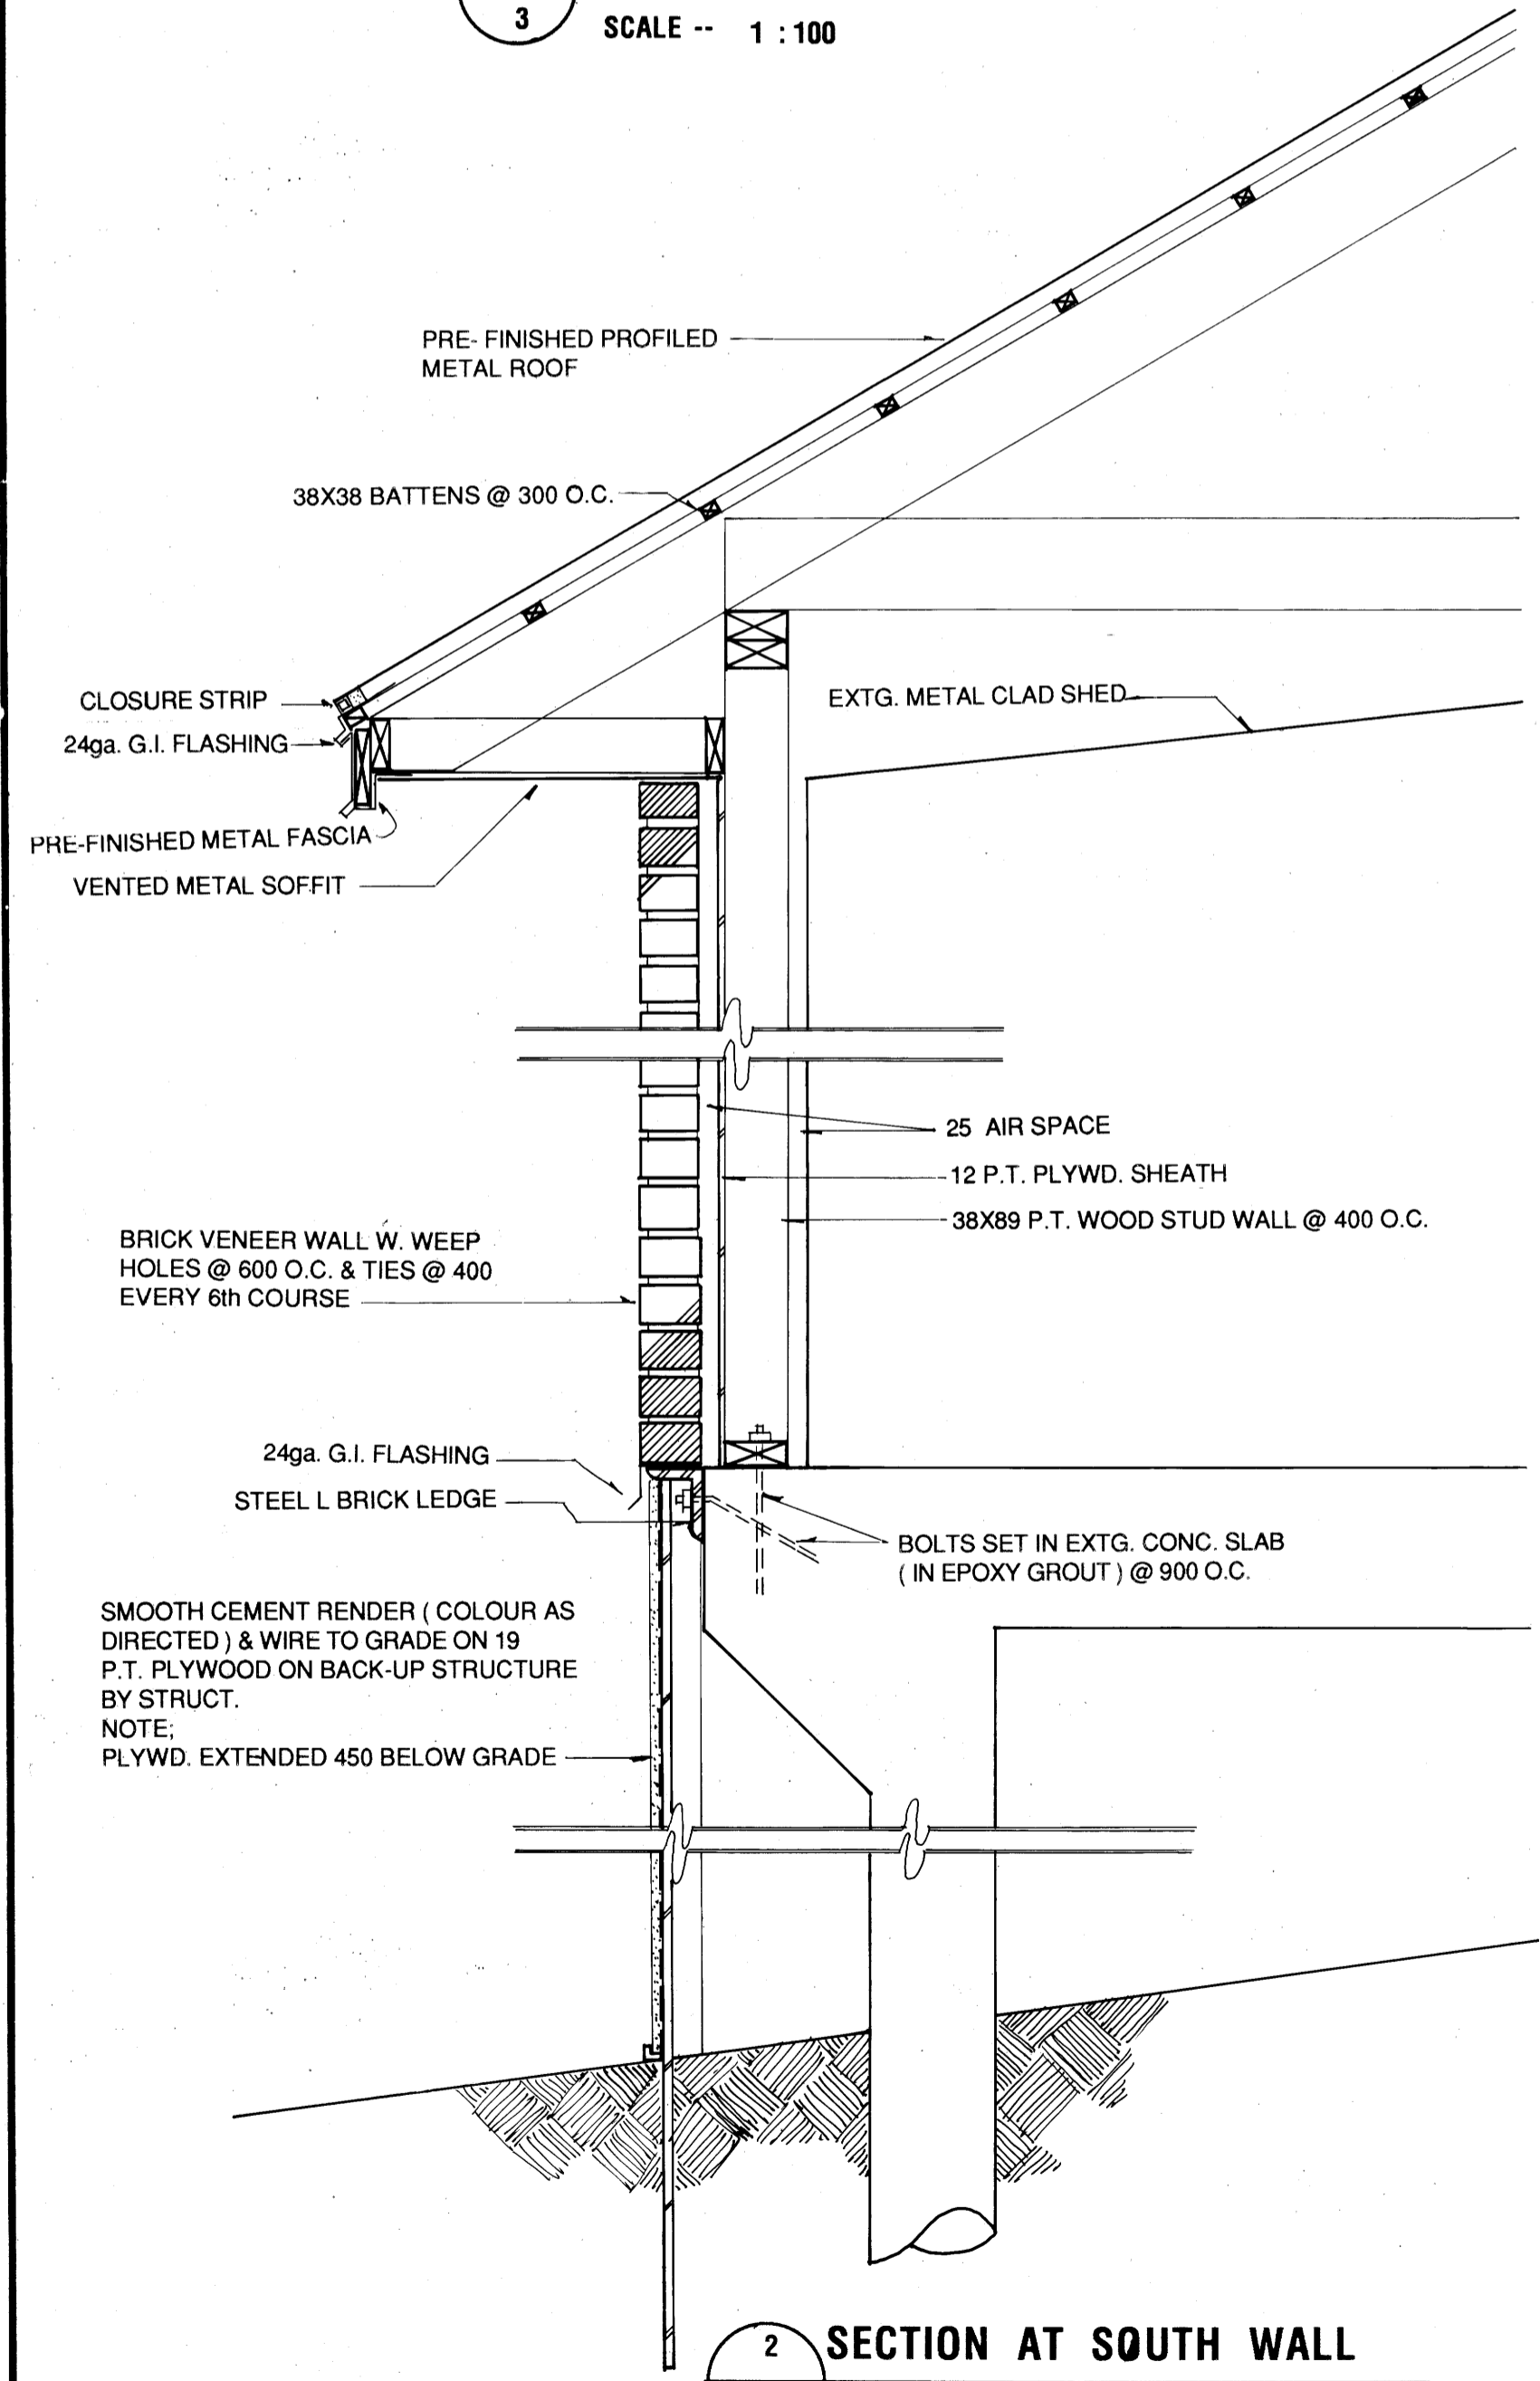

2 SECTION AT SOUTH WALL
SCALE -- 1:10

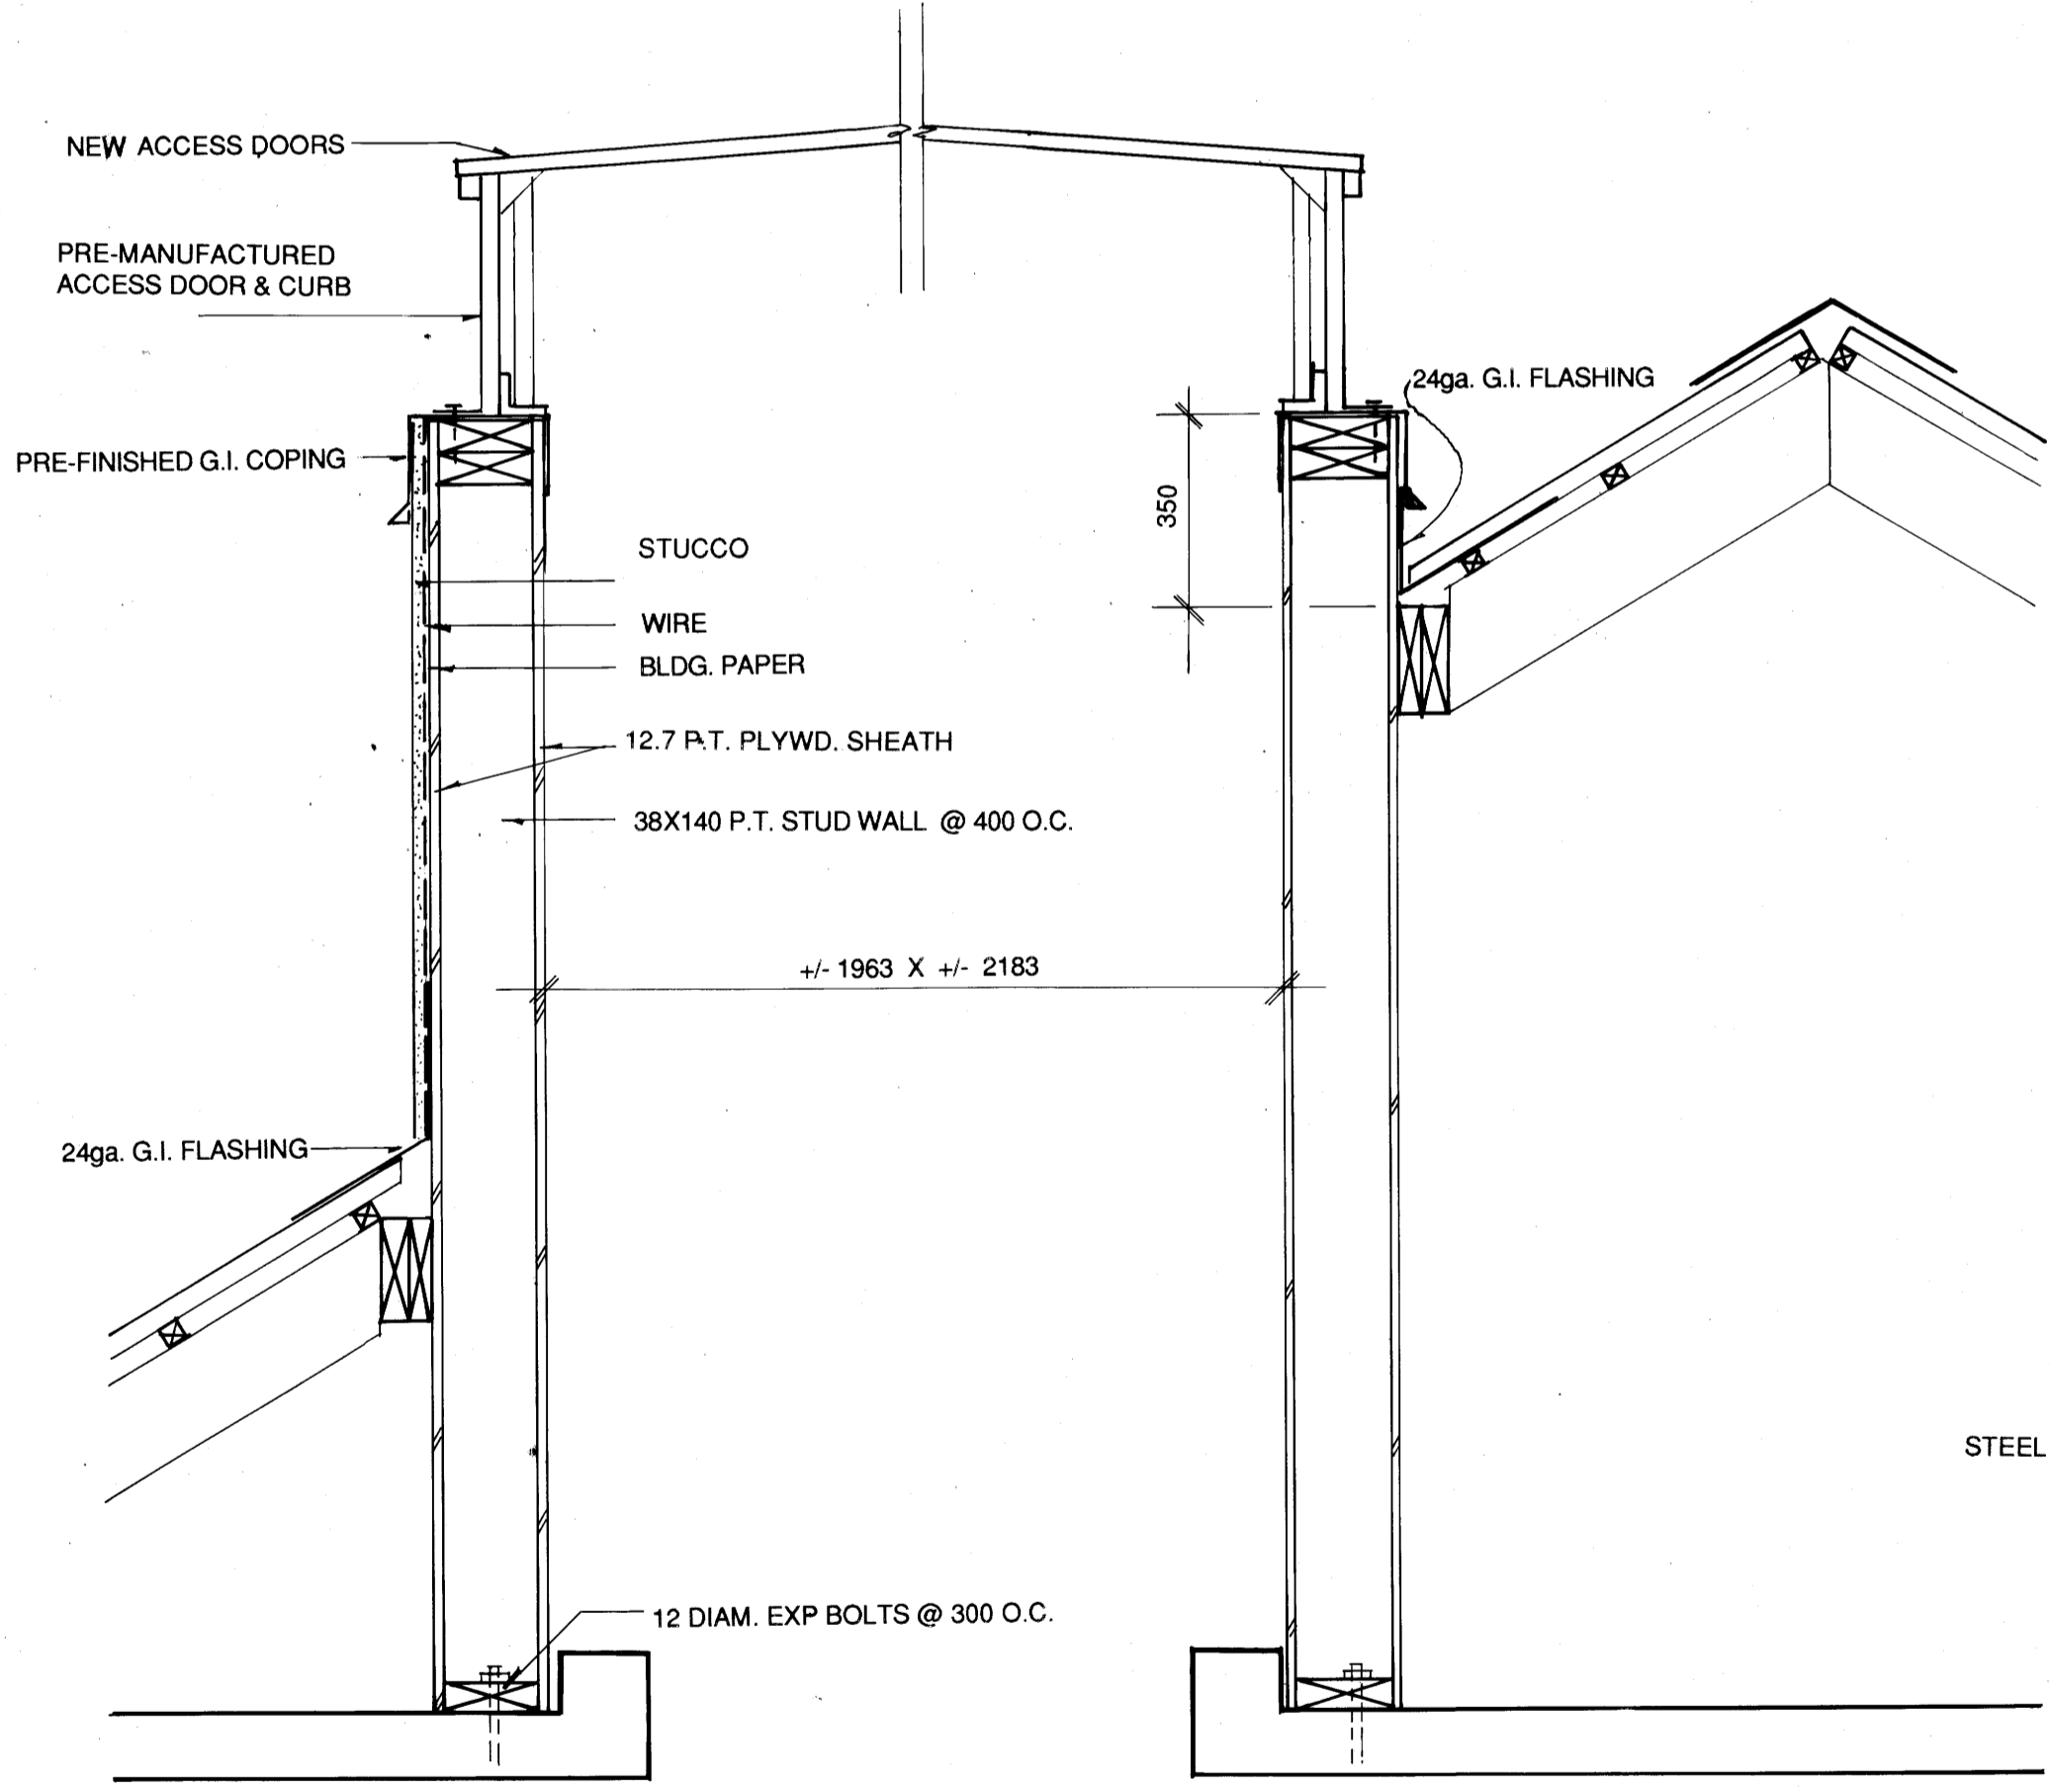

4 DETAIL THROUGH ACCESS HATCH
SCALE -- 1:10

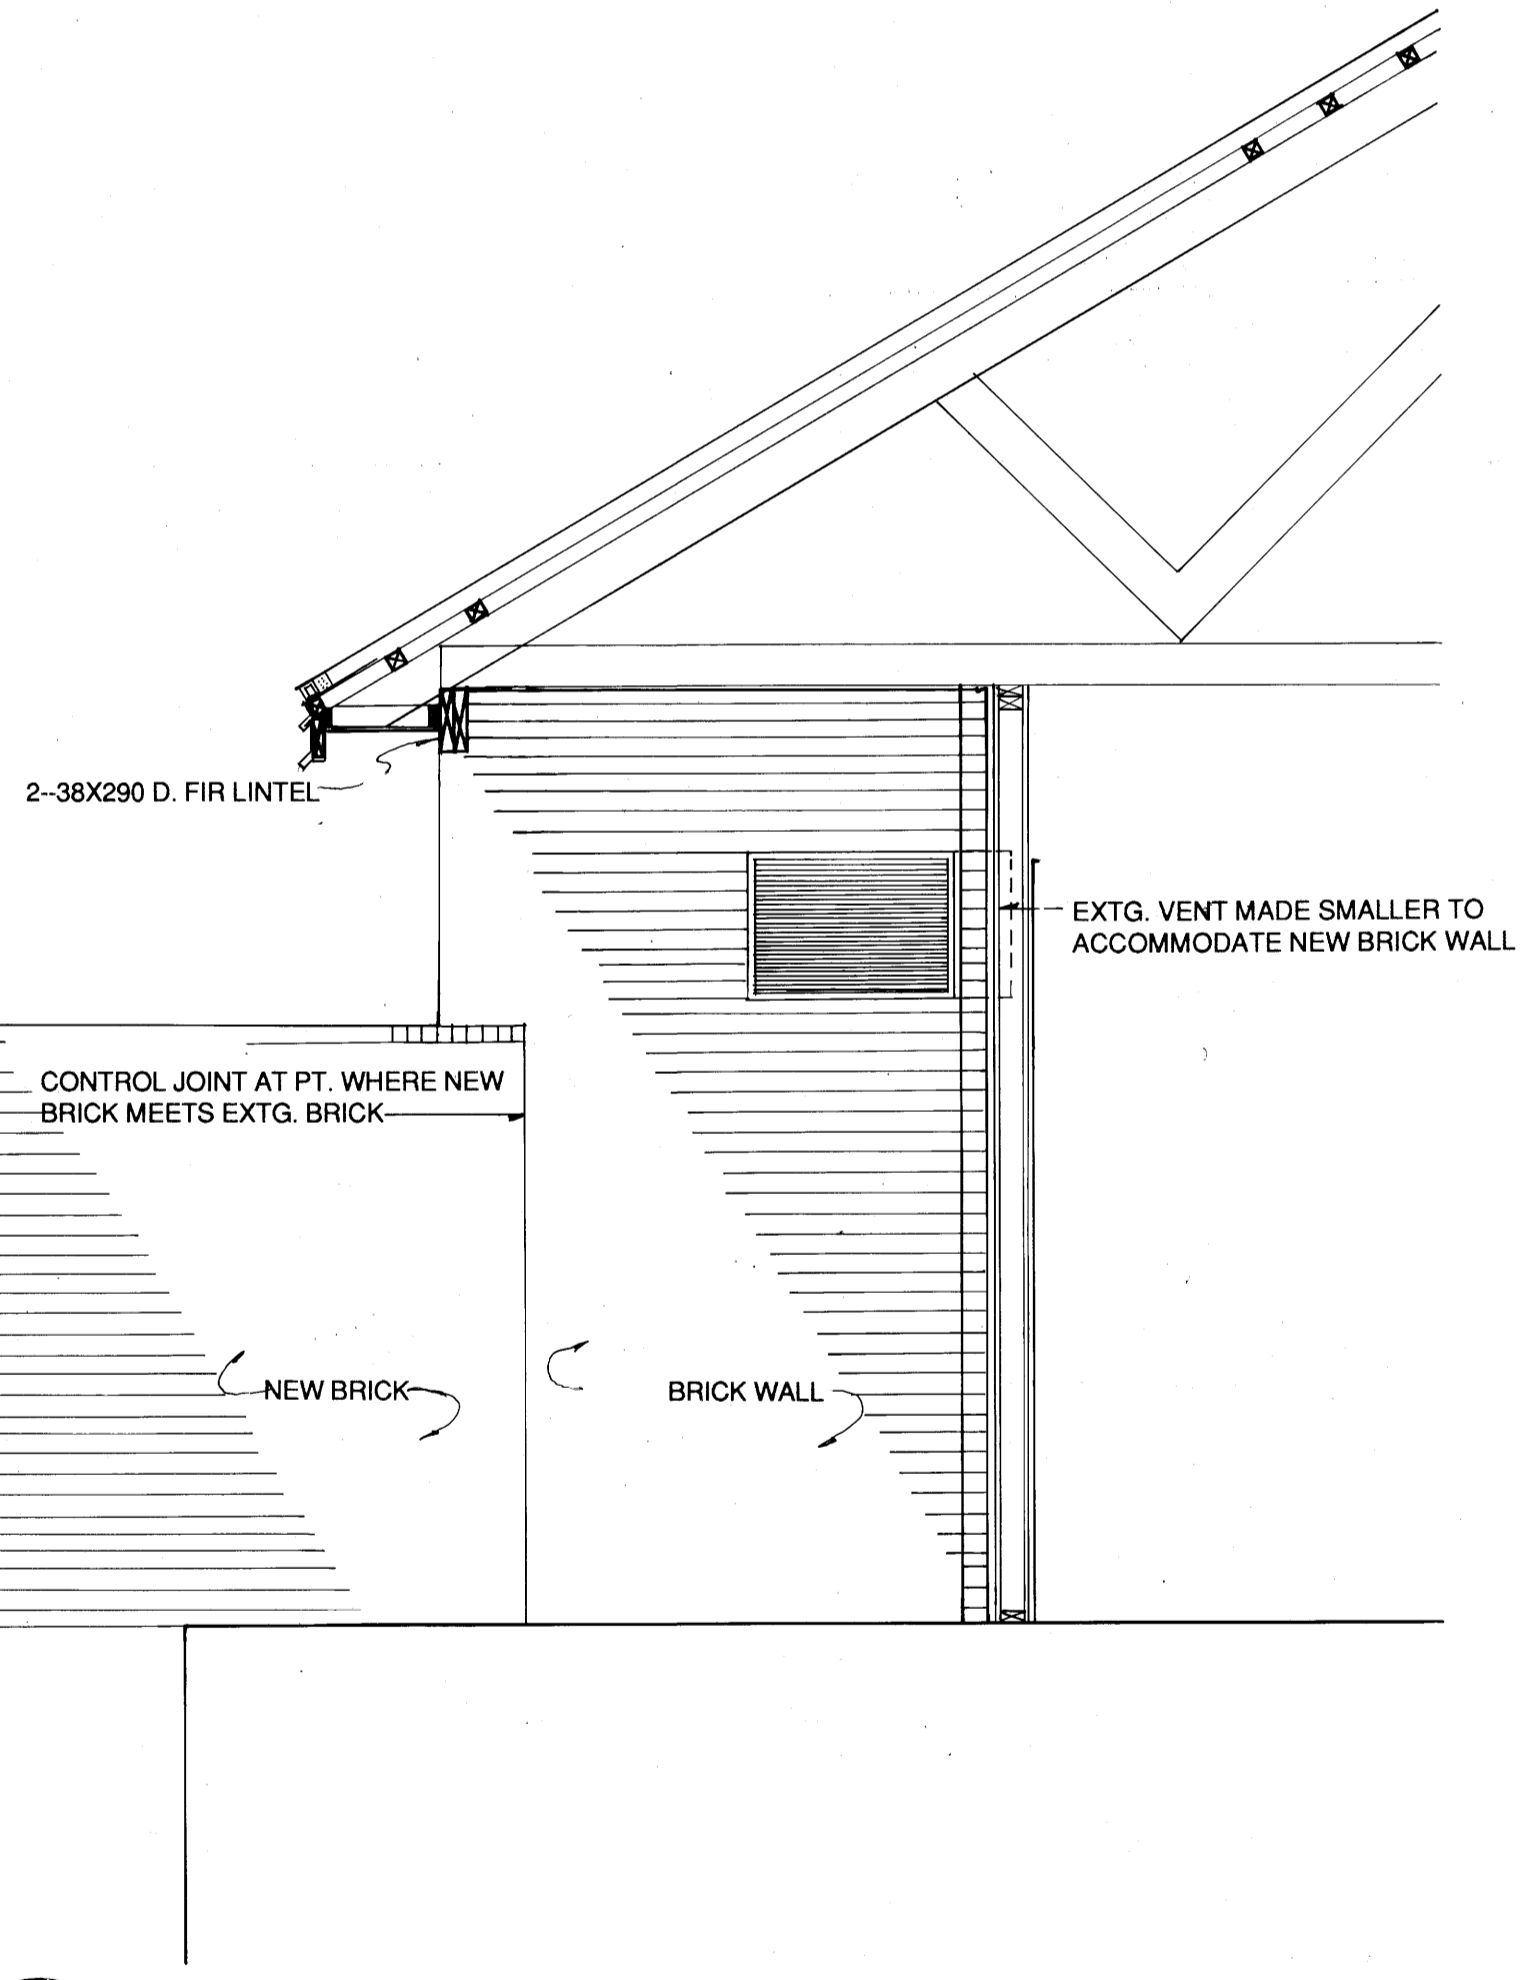

6 SECTION AT WEST WALL
SCALE -- 1:25

REF. or Drawing No. **LD 961**
DETAILS FILE # LD10313

LLEWELLIN SIMON ASSOCIATES 403-63 Albert St. Winnipeg, MB R3B 1G4 (204) 947-9301 LANDSCAPE ARCHITECTURE • URBAN DESIGN • ARCHITECTURE				ENGINEER'S SEAL T. J. Plouffe 2/89 RECA		 THE CITY OF WINNIPEG WORKS AND OPERATIONS DIVISION WATERWORKS, WASTE & DISPOSAL <i>FILE # LD10313</i>	
DESIGNED BY TPLL	CHECKED BY 	DRAWN BY KR	APPROVED BY 	COCKBURN ST. PUMPING STATION ARCHITECTURAL IMPROVEMENTS & SITE LANDSCAPING		CITY DRAWING NUMBER LD - 961 SHEET 4 OF 8	
HOR SCALE AS SHOWN	VERTICAL AS SHOWN	DATE FEB. 1989	DATE FEB 16/89	CONSULTANT DRAWING NO. 8709 - A 3		BUILDING: DETAILS	