




SECTION 13A
SCALE 1/2" = 1'-0"

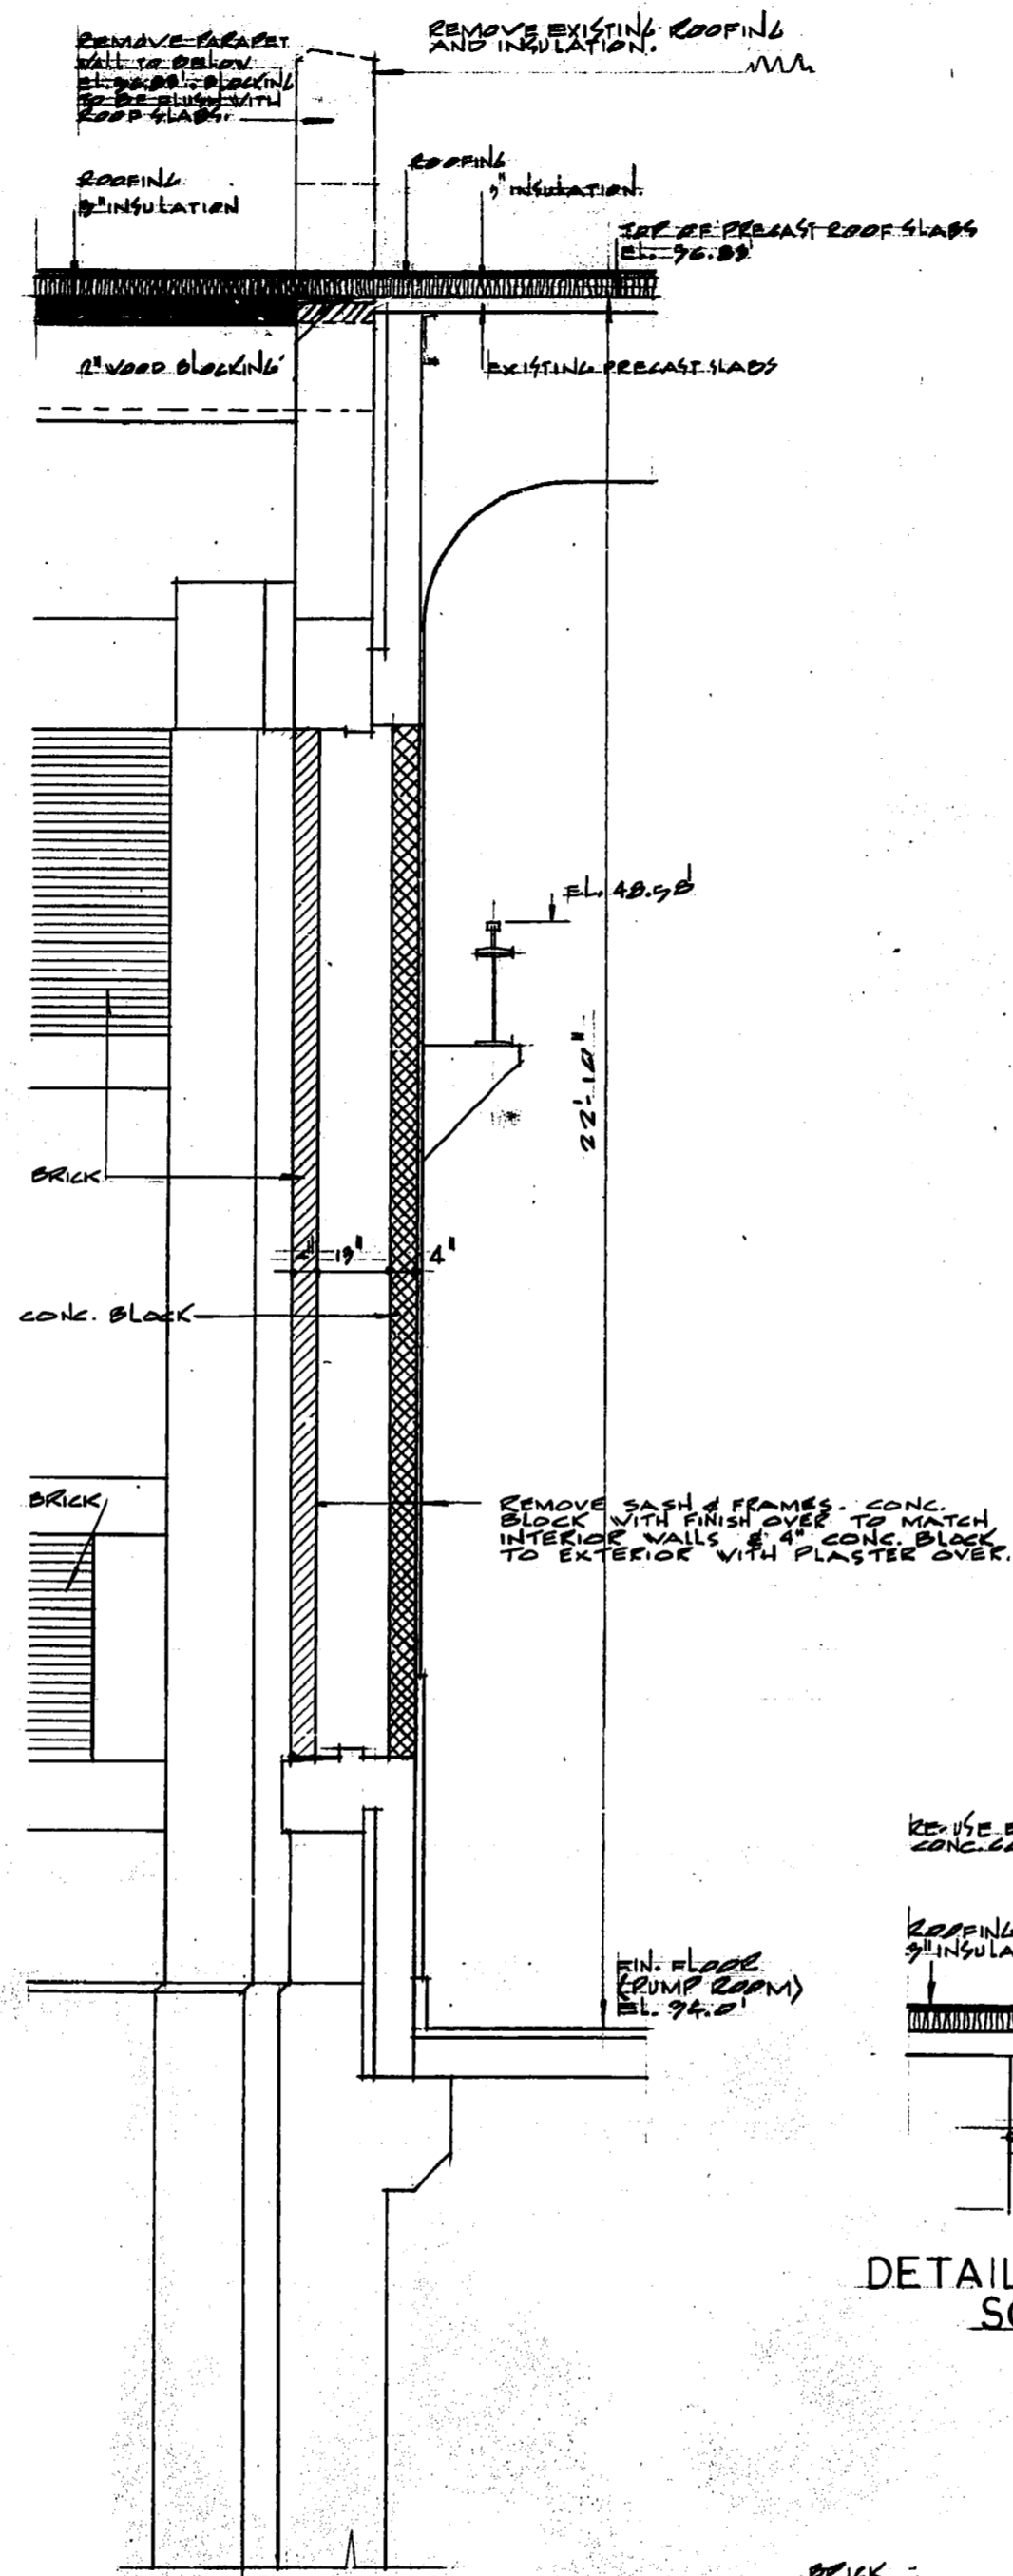


SECTION 13B
SCALE 1/2" = 1'-0"

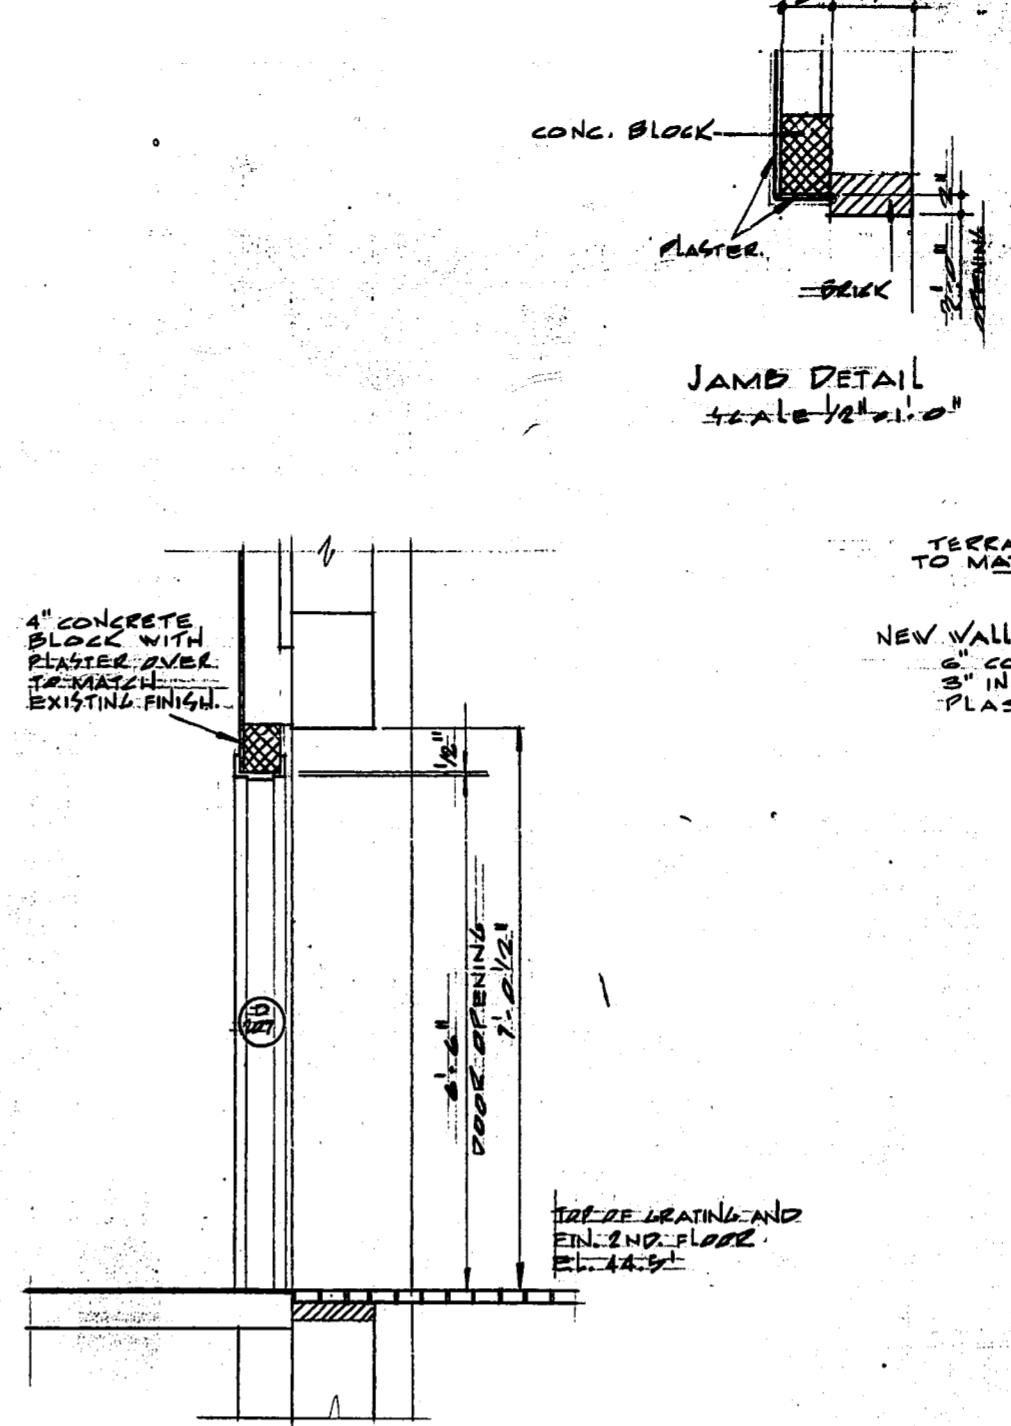


SECTION 13C
SCALE 1/2" = 1'-0"

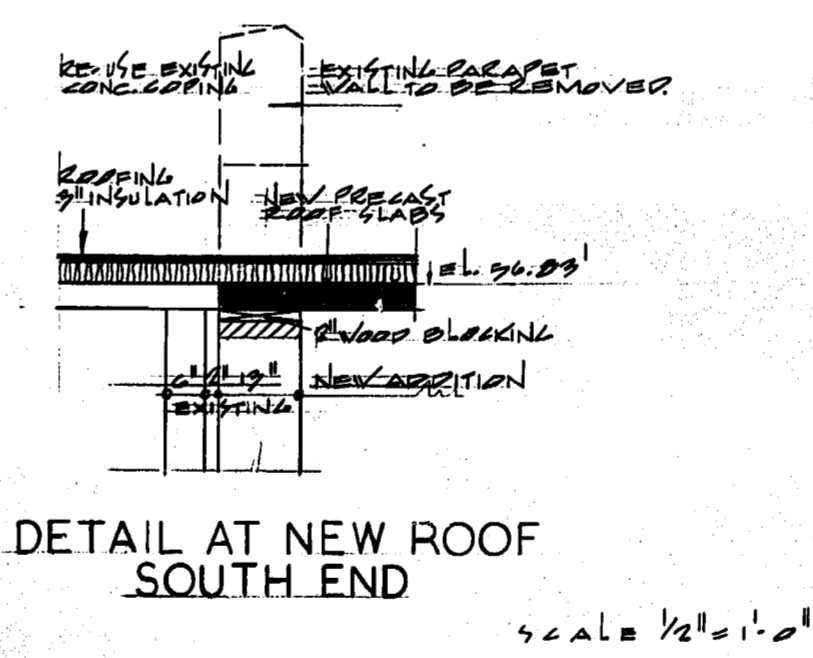


DETAIL AT NEW ROOF SOUTH END
SCALE 1/2" = 1'-0"

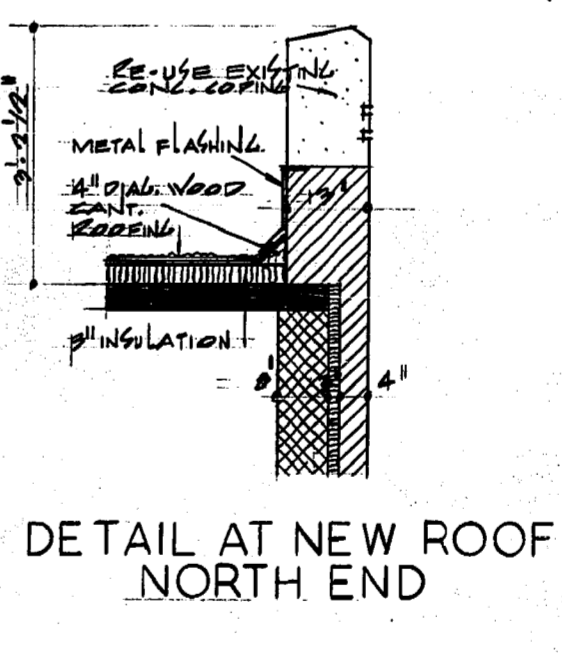

DETAIL AT NEW ROOF NORTH END
SCALE 1/2" = 1'-0"

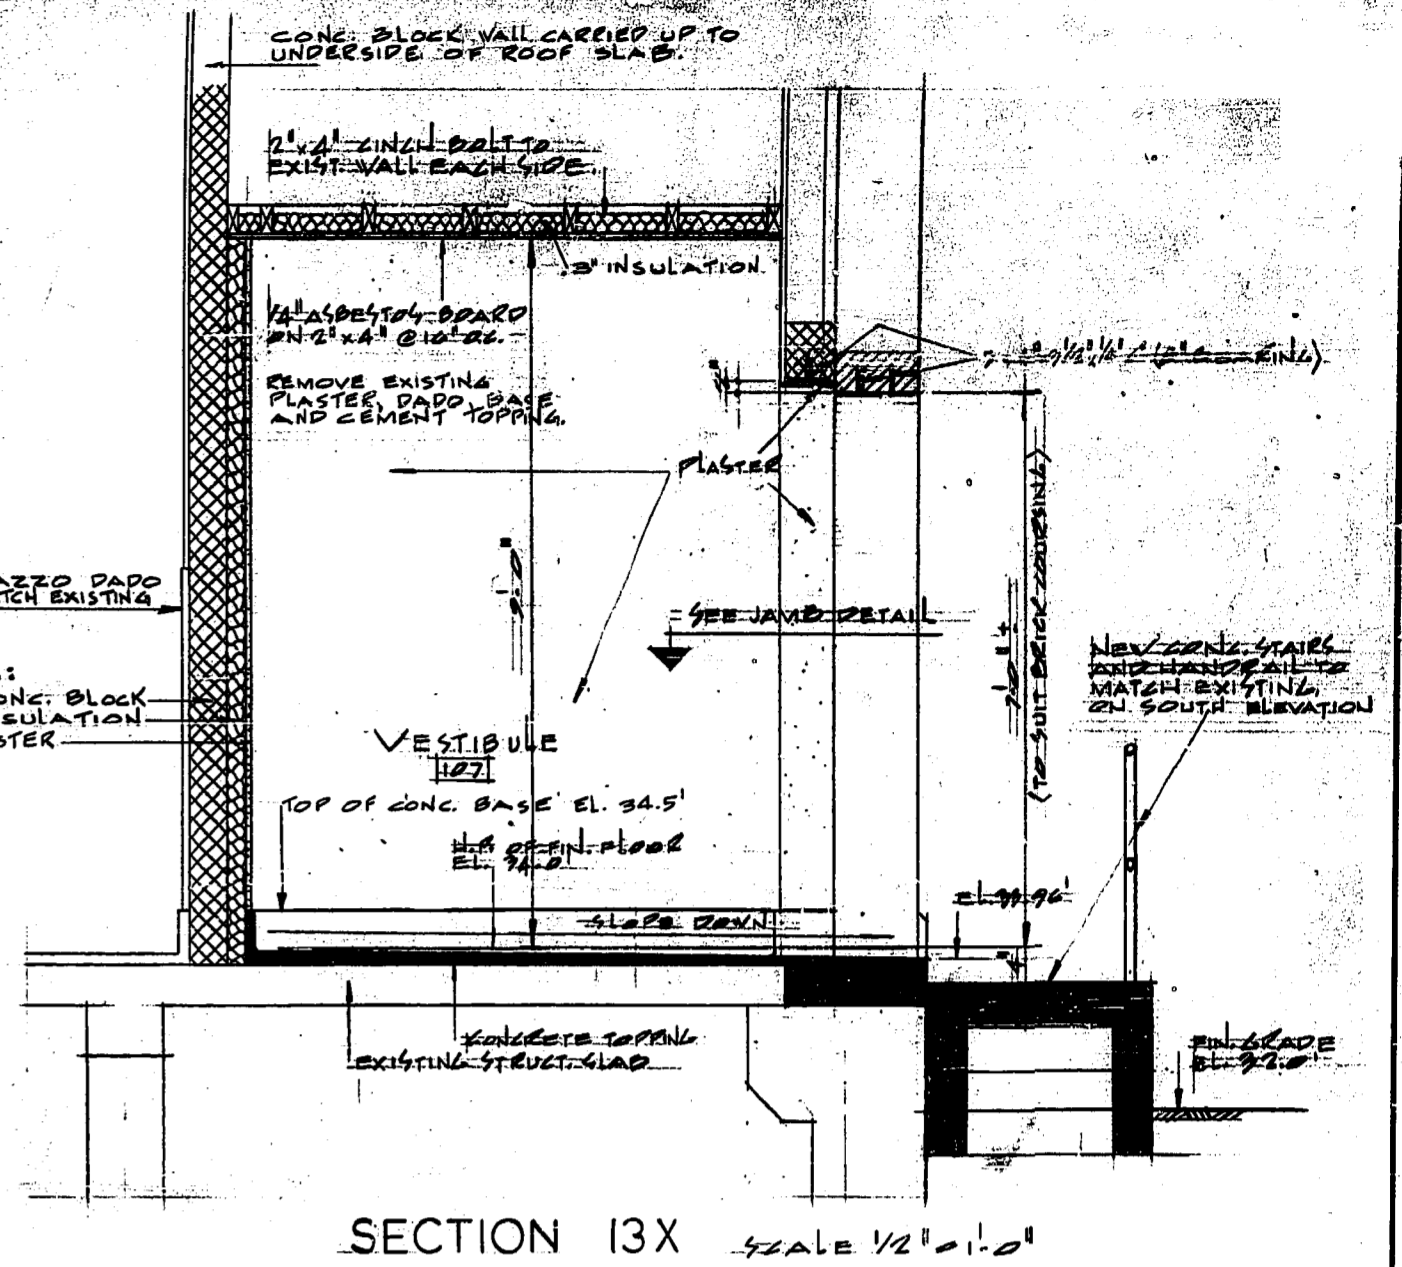


SECTION 13X
SCALE 1/2" = 1'-0"

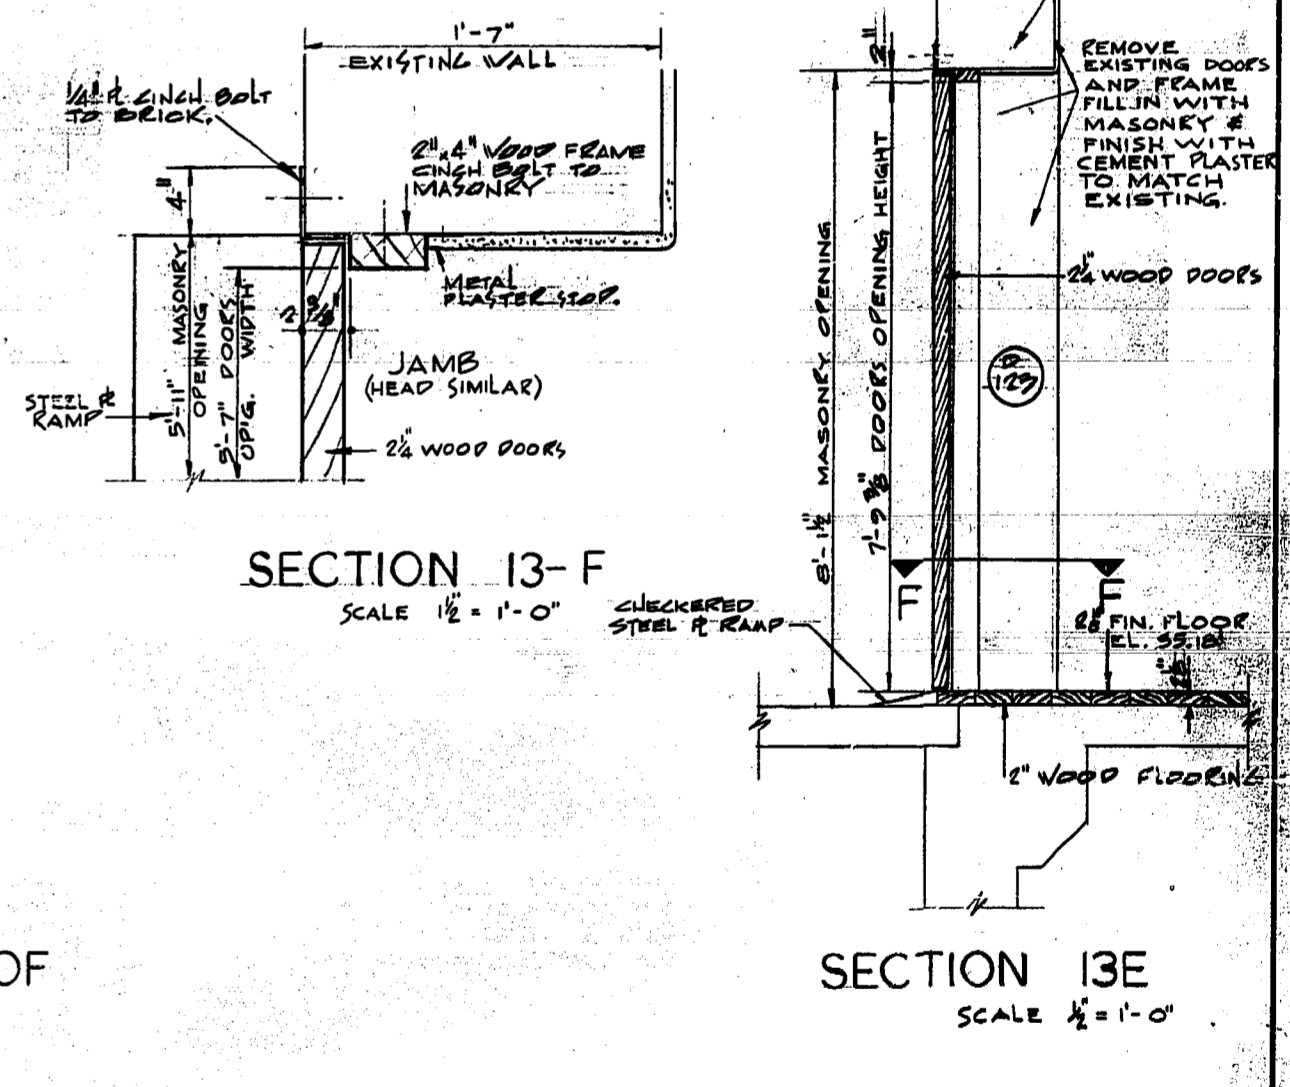


SECTION 13-F
SCALE 1/2" = 1'-0"

SECTION 13E
SCALE 1/2" = 1'-0"

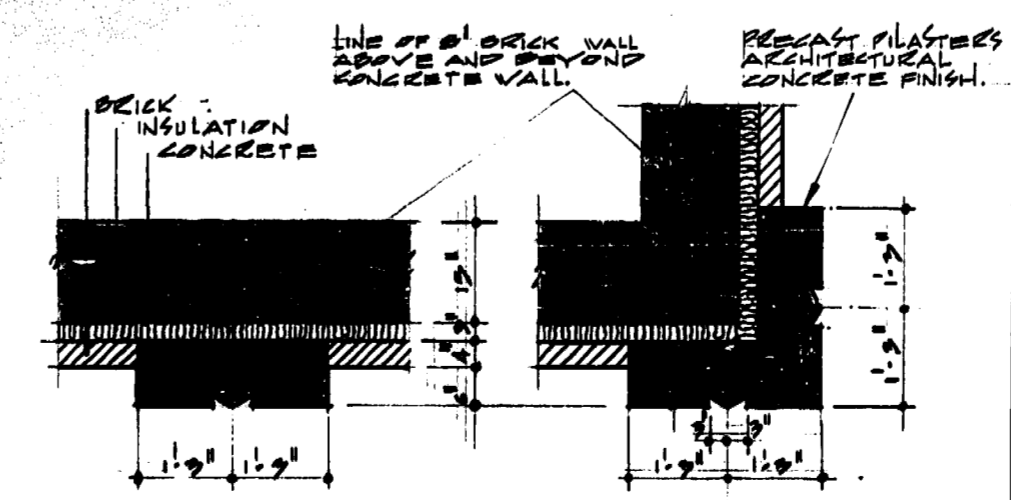

TYPICAL CONCRETE PILASTER DETAILS
SCALE 1/2" = 1'-0"
FOR ACTUAL ELEV. SUBTRACT 0.37 FT.

REVISIONS		
No.	DATE	DETAIL

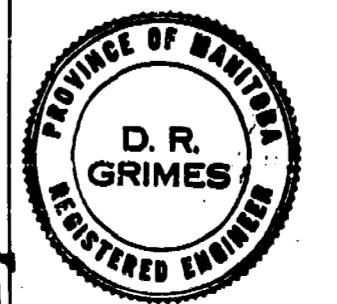

THE METROPOLITAN CORPORATION OF GREATER WINNIPEG
WATERWORKS AND WASTE DISPOSAL DIVISION

NORTH END SEWAGE TREATMENT PLANT

CONTRACT A - MAIN BUILDING SUPERSTRUCTURE - WALL SECTIONS

APPROVED: *J. W. MacLaren*
JAMES F. MACLAREN LIMITED ENGINEERS TORONTO

APPROVED: *A. R. Grimes*
W.L. WARDROP ASSOCIATES (MANAGEMENT) LIMITED ENGINEERING CONSULTANTS WINNIPEG

DATE: MARCH 11, 1963
SCALE: AS SHOWN
DWG. No. OF: 13 OF 217
NEP-13