



1 PART BASEMENT FLOOR PLAN

MF2.1 SCALE: 1/8" = 1' - 0"

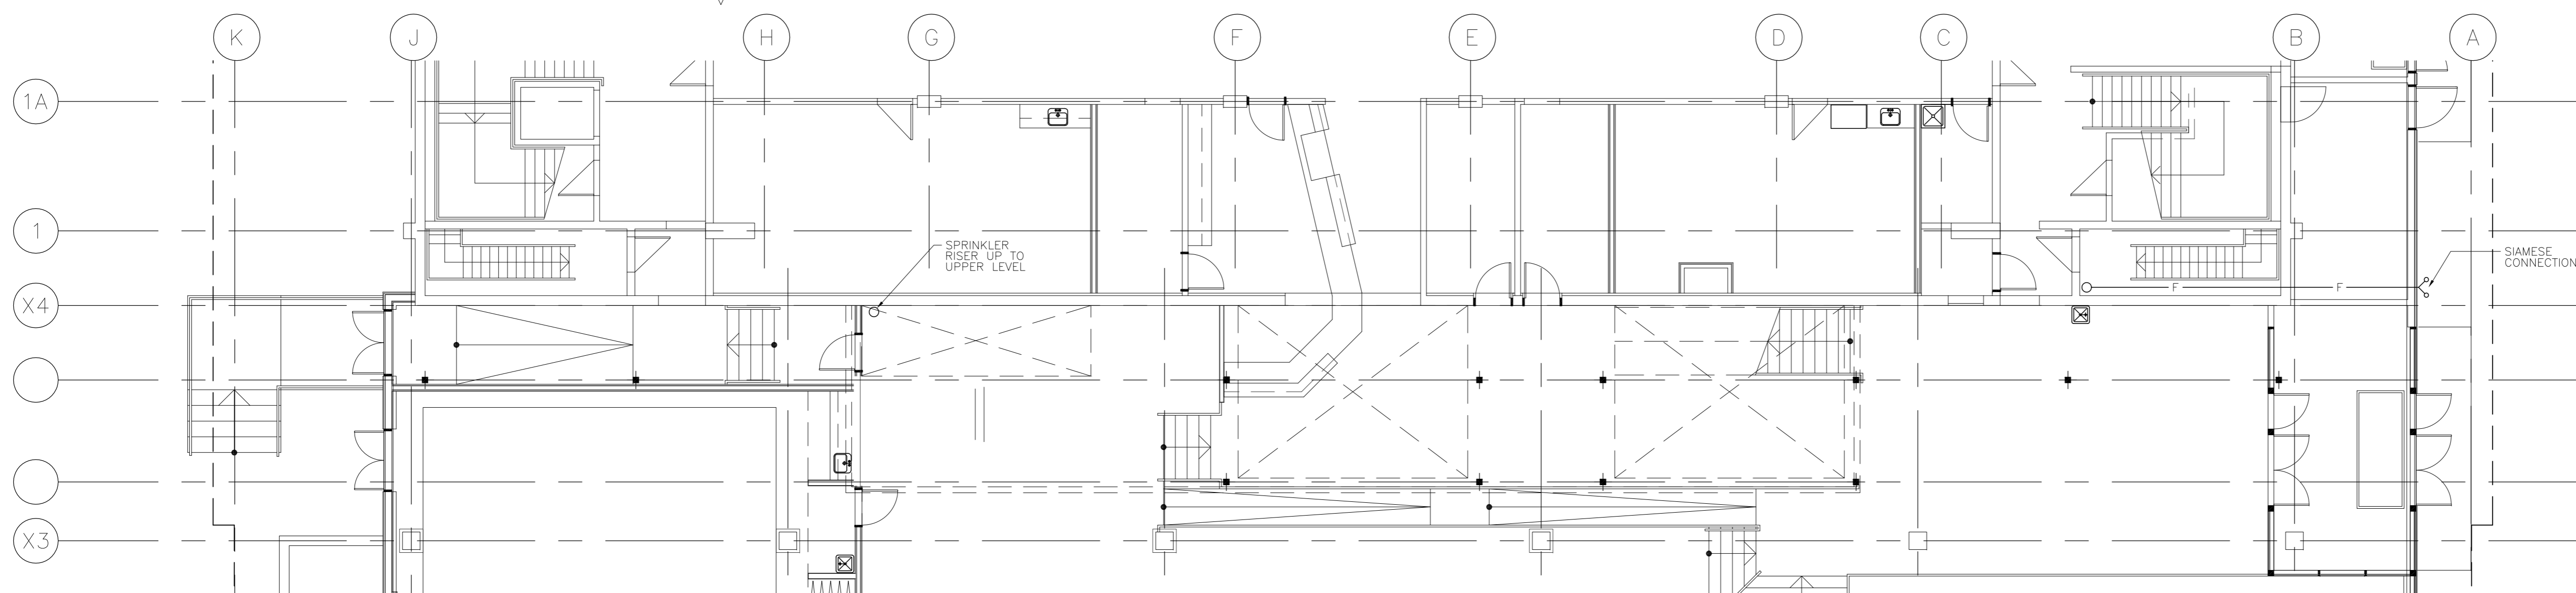


2 PART GROUND FLOOR PLAN

MF2.1 SCALE: 1/8" = 1' - 0"

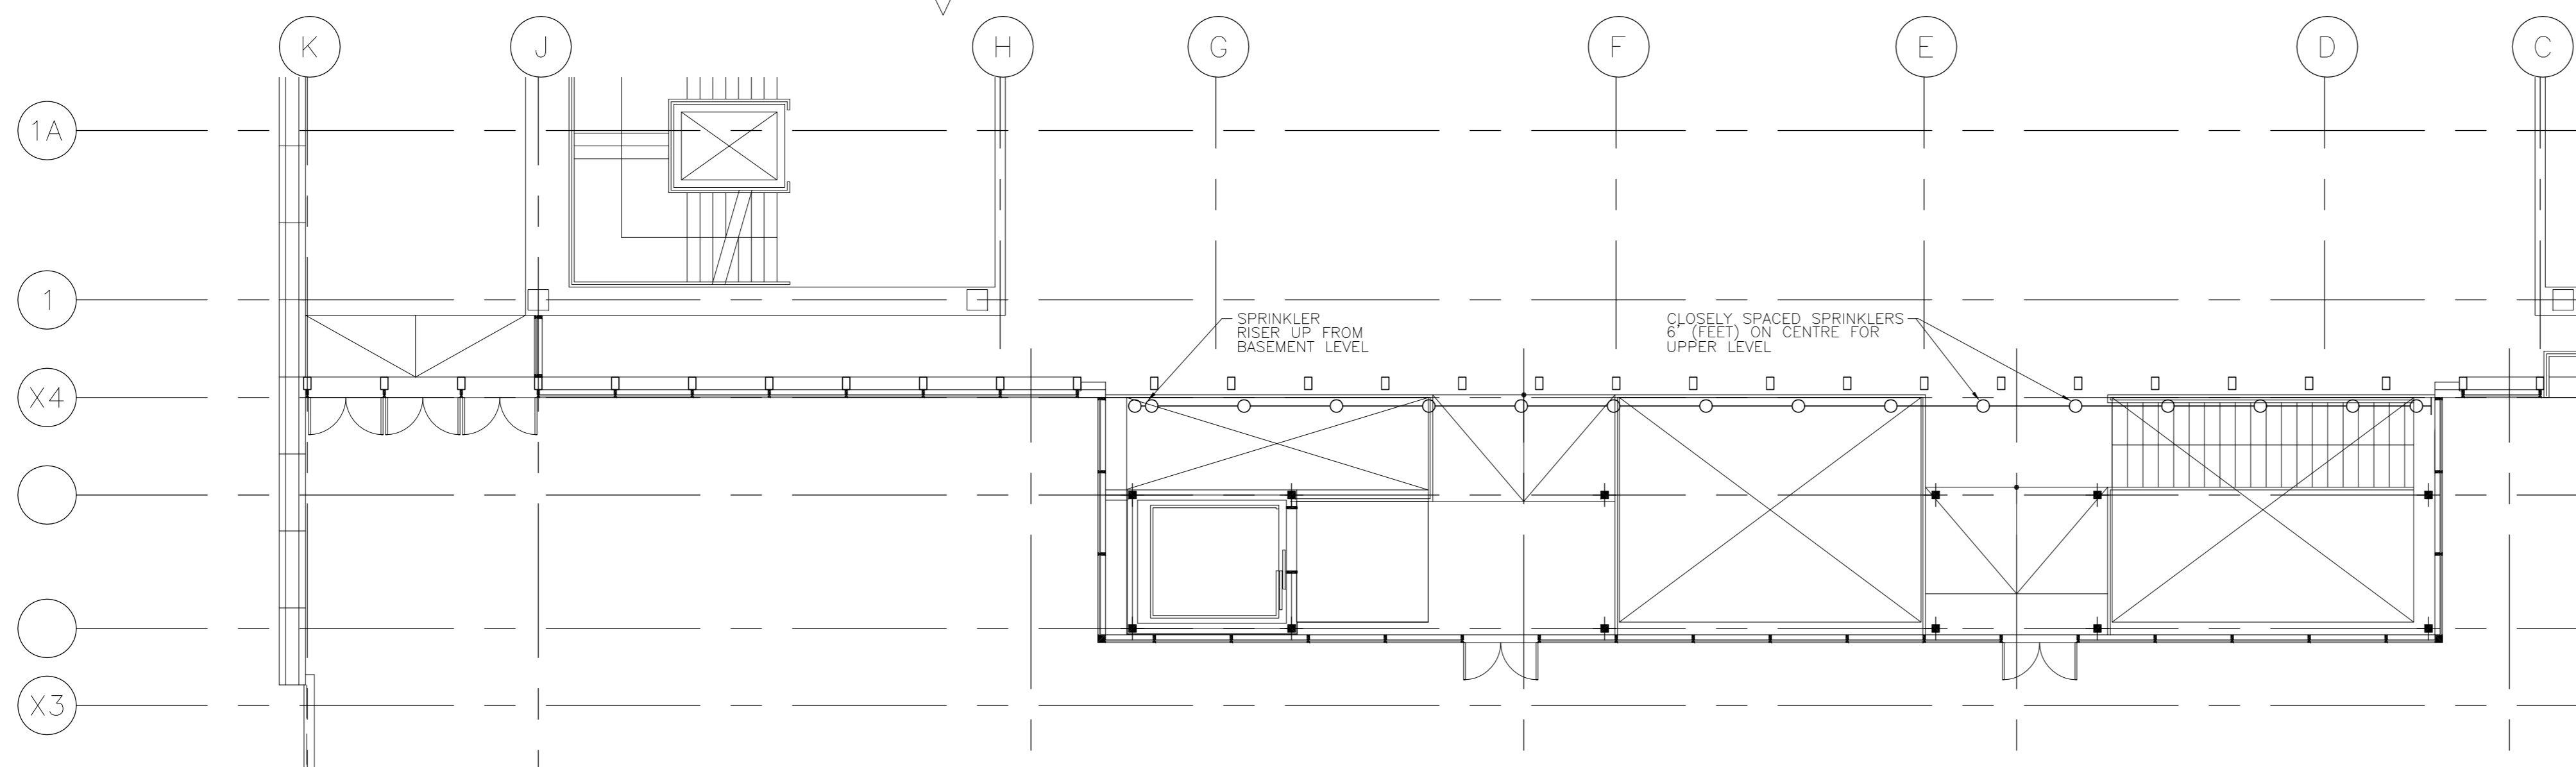

3 PART UPPER LEVEL FLOOR PLAN

MF2.1 SCALE: 1/8" = 1' - 0"

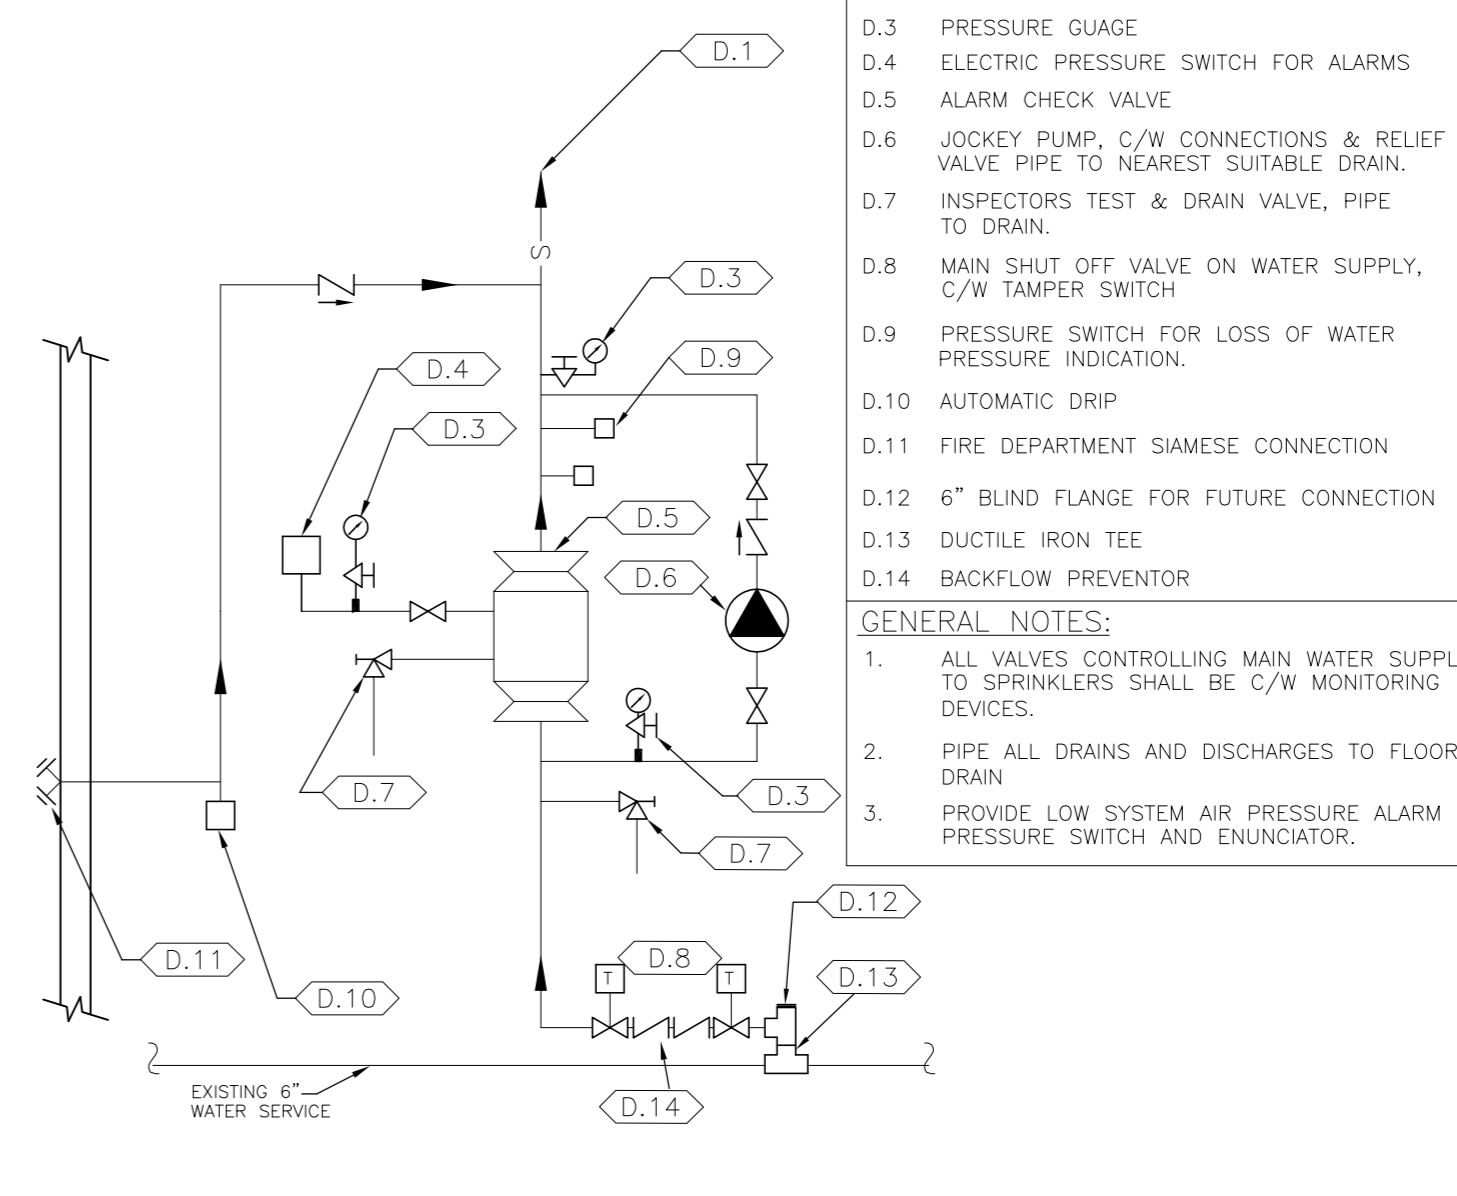

4 WET SYSTEM SPRINKLER TREE SCHEMATIC

MF2.1 SCALE: N.T.S.

FIRE PROTECTION LEGEND	
☒	SPRINKLER HEAD, WITH GUARD
●	PENDENT SPRINKLER, ON DROP NIPPLE
○	UPRIGHT SPRINKLER
⊖	PENDENT SPRINKLER
⊕	CONCEALED SPRINKLER HEAD
⊙	UPRIGHT SPRINKLER, NIPPLED UP
▽	SIDEWALL SPRINKLER
FHC	FIRE HOSE CABINET
△	ABC FIRE EXTINGUISHER
F	FIRE LINE
S	SPRINKLER LINE
⌋	DOWN ELBOW
⌋	UP ELBOW
—	CAPPED LINE
⊗	VALVE WITH TAMPER DETECTOR/SWITCH
⊗	UL APPROVED SOLENOID-CONTROL VALVE
⊗	FLOW DETECTOR/SWITCH
⊗	INSPECTOR'S TEST AND DRAIN VALVE
⊗	PUMP
⊗	CHECK VALVE
⊗	ALARM CHECK VALVE
⊗	PRESSURE DETECTOR/SWITCH
⊗	2-WAY FIRE DEPT. CONNECT. (SIAMESE)
⊗	WATER MOTOR ALARM (GONG)
⊗	DRAIN

No.	Description	Date (d/m/y)	Drawn	Checked
Revisions/Issuance (Read Up)				
Initialed By				
Designed By JMc				
Drawn By RwG				
Checked By RwG, JMc				
Approved By GC				



Man-Shield
CONSTRUCTION INC.
205-698 CORYDON AVE
WINNIPEG, MANITOBA
R2M 0Y5
(204) 475-4304

Smith Carter
Architects
Engineers
Planners
Interior Designers

ADDITIONS AND RENOVATIONS
TO THE PAN-AM POOL
WINNIPEG
MANITOBA

Sheet Title	BASEMENT, MAIN & UPPER LEVEL FIRE PROTECTION
Scales	AS SHOWN
Date	DEC. 19, 1997
File Number	97126
Sheet Number	MF2.1