



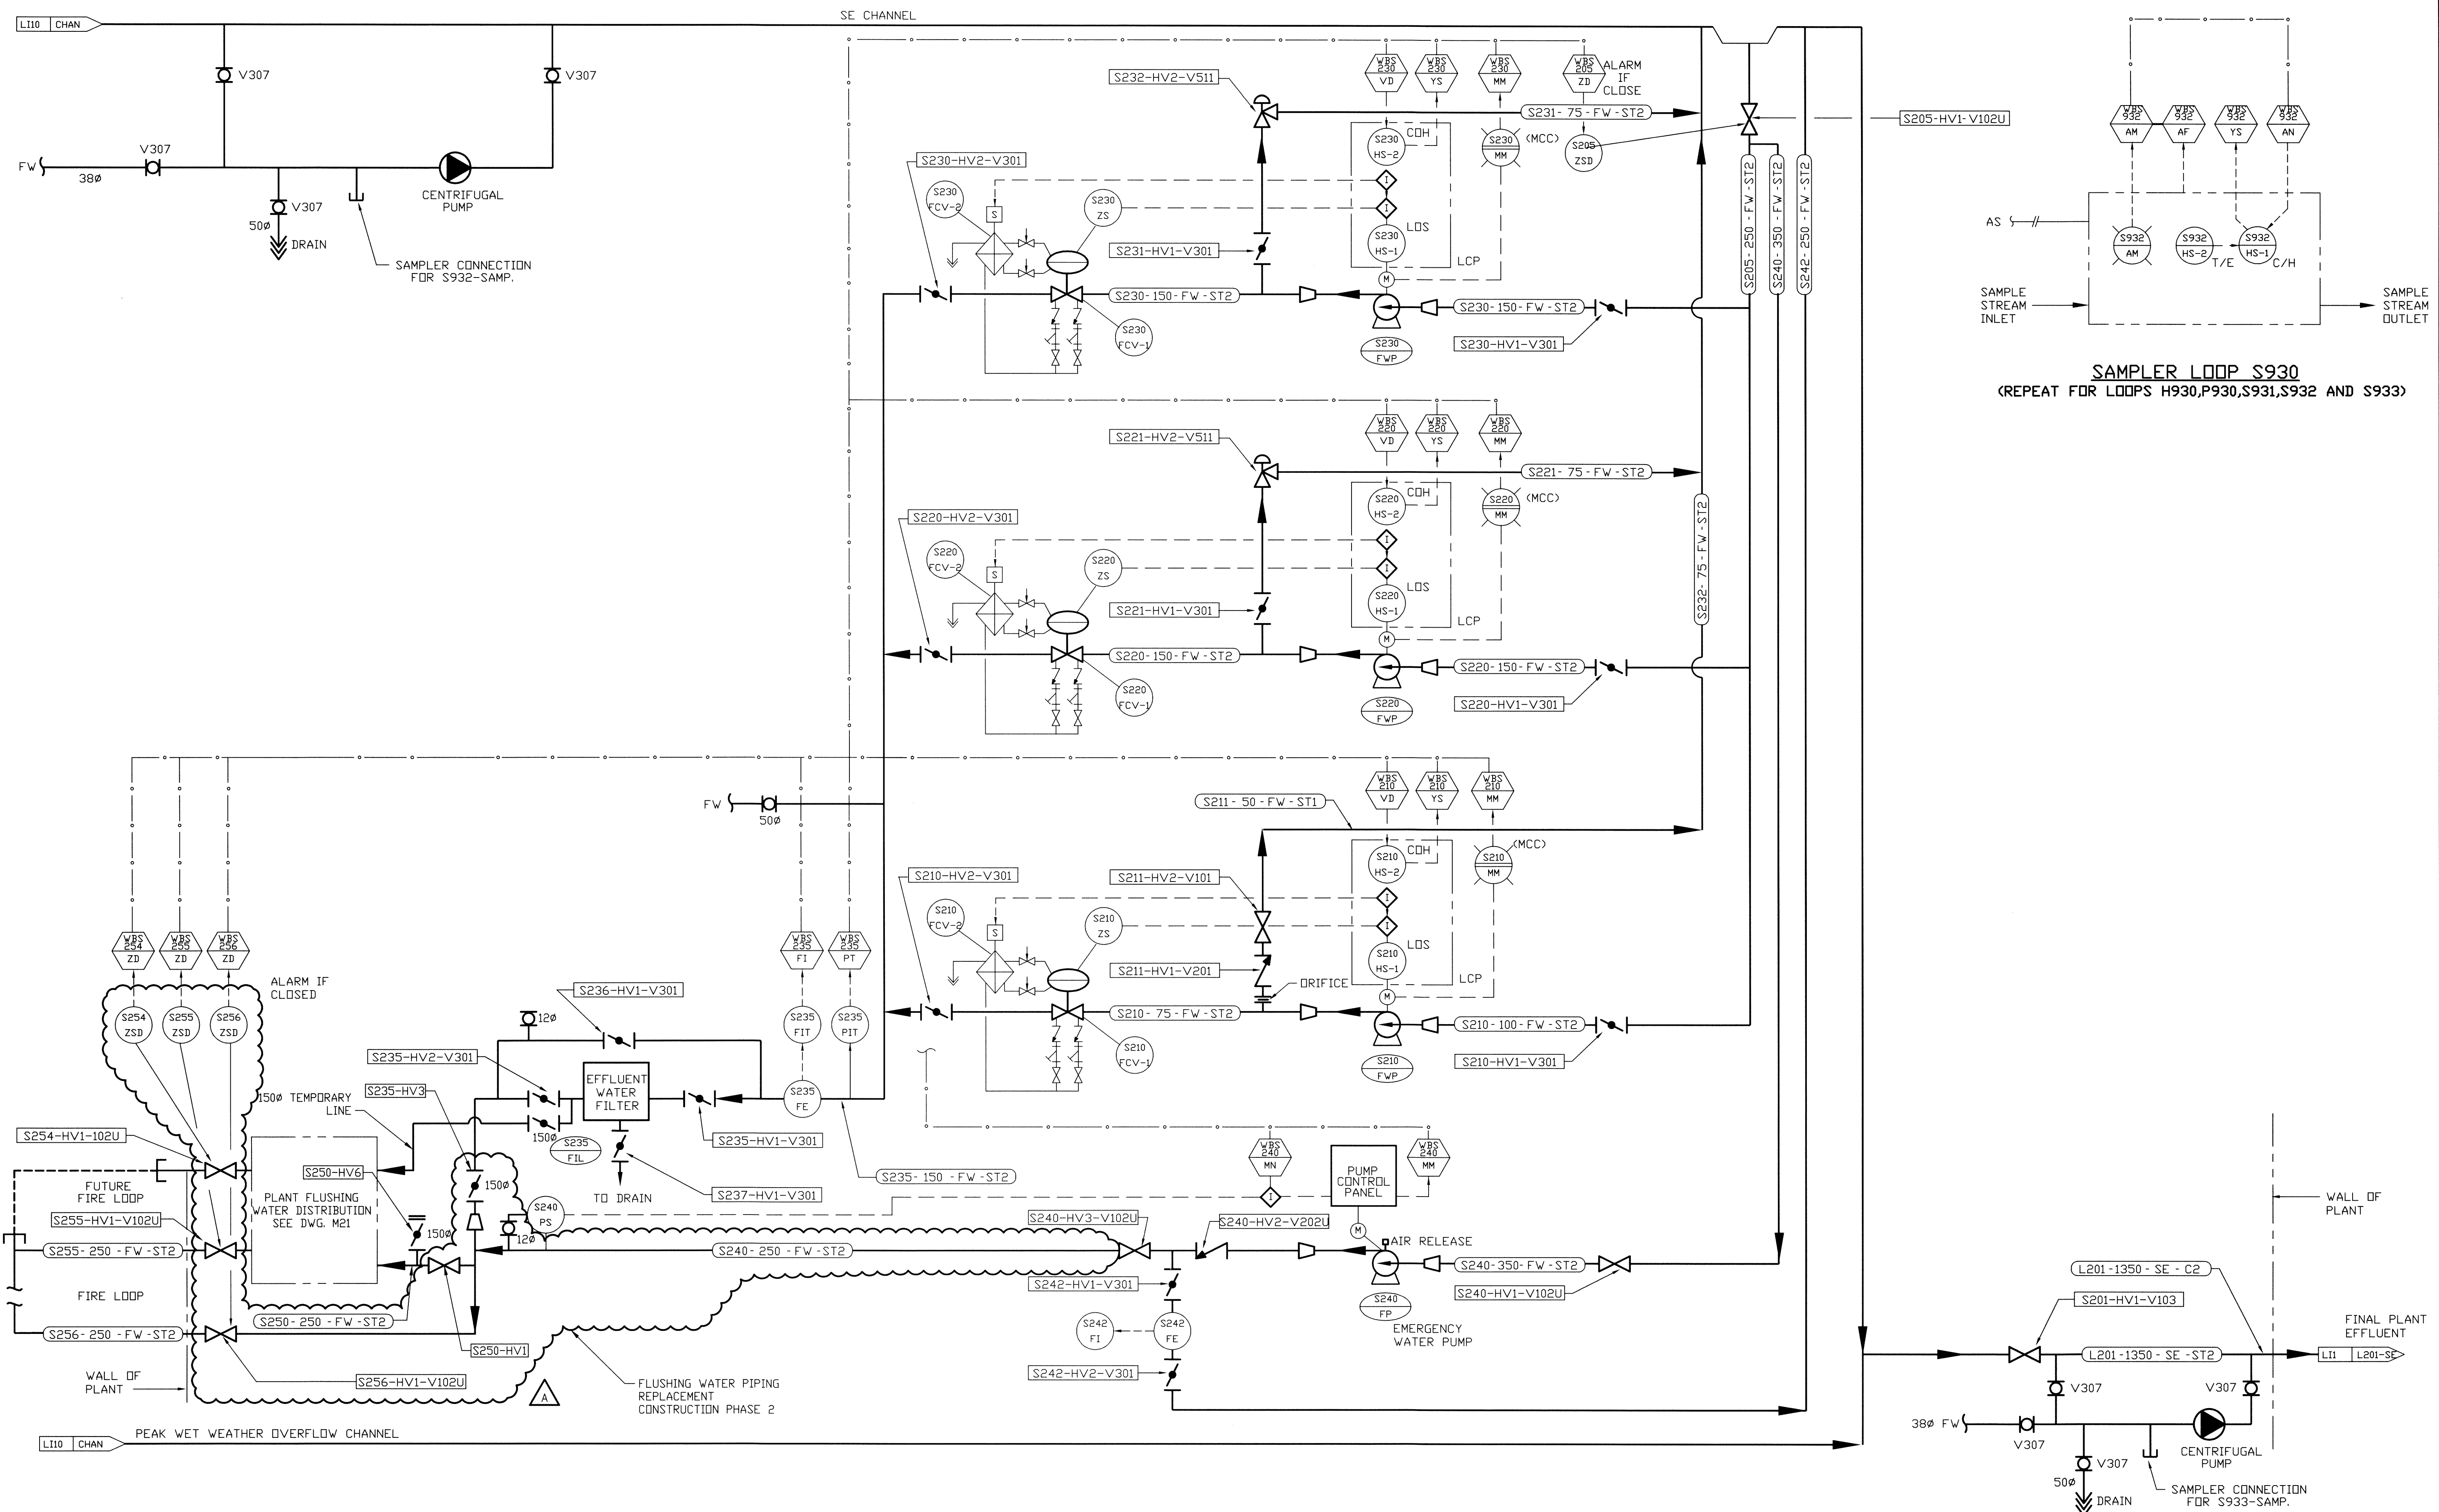


THIS DRAWING IS BASED ON EXISTING SYSTEM P&ID,
DRAWING NO. WEP-93 REV. 2



		FIELD BOOK #:	
POSTED TO LBIS			
0	ISSUED FOR CONSTRUCTION	16/05/09	
NL	REVISIONS	DATE	BY

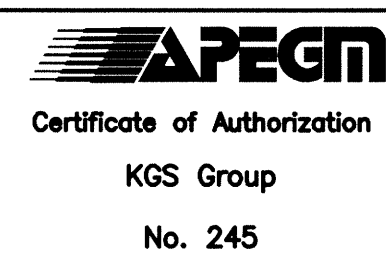

DESIGNED BY JS	CHECKED BY <i>MAK</i>
DRAWN BY JFS	APPROVED BY <i>JFS</i>
HOR. SCALE AS NOTED	RELEASED FOR CONSTRUCTION
VERTICAL AS NOTED	
DATE 2016 02 29	DATE 2016-05-09

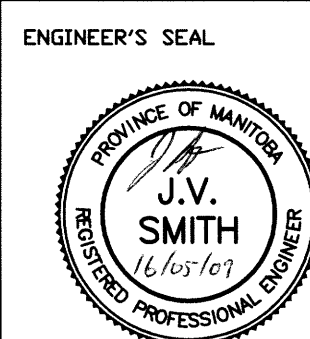

P1.2



THE CITY OF WINNIPEG
WATER AND WASTE DEPARTMENT

WEWPCC FW PIPE REPLACEMENT
MECHANICAL
FLUSHING WATER PIPE REPLACEMENT
CONSTRUCTION PHASE 2
PIPING AND INSTRUMENTATION DIAGRAM

SHEET 1	OF 1
CITY DRAWING NUMBER	
1-0103S-P0024-001	