


issue / rev.

issue / rev.	date	issue notes
1	2016/07/27	RE-ISSUED FOR CONSTRUCTION
0	2016/07/15	ISSUED FOR CONSTRUCTION
#	date	issue notes

professional seals

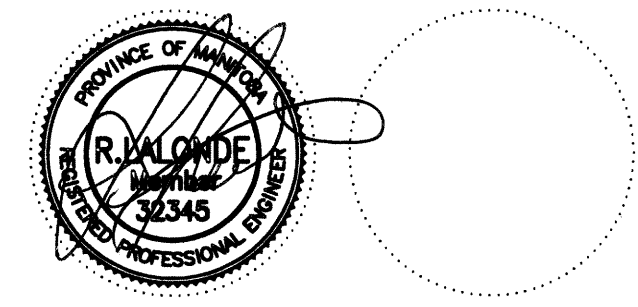

July 27, 2016

project information

**SEVEN OAKS POOL**

444 Adsum Drive  
Winnipeg, MB  
Canada

client

City of Winnipeg  
4th Floor - 86 King Street  
Winnipeg, MB

drawing information

**ELECTRICAL MEZZANINE LIGHTING - NEW**

drawn by: GCN


approved by:

scale: AS NOTED

date issued: 2016.07.15

proj. #: 14-1736-008

rev. #: R-1

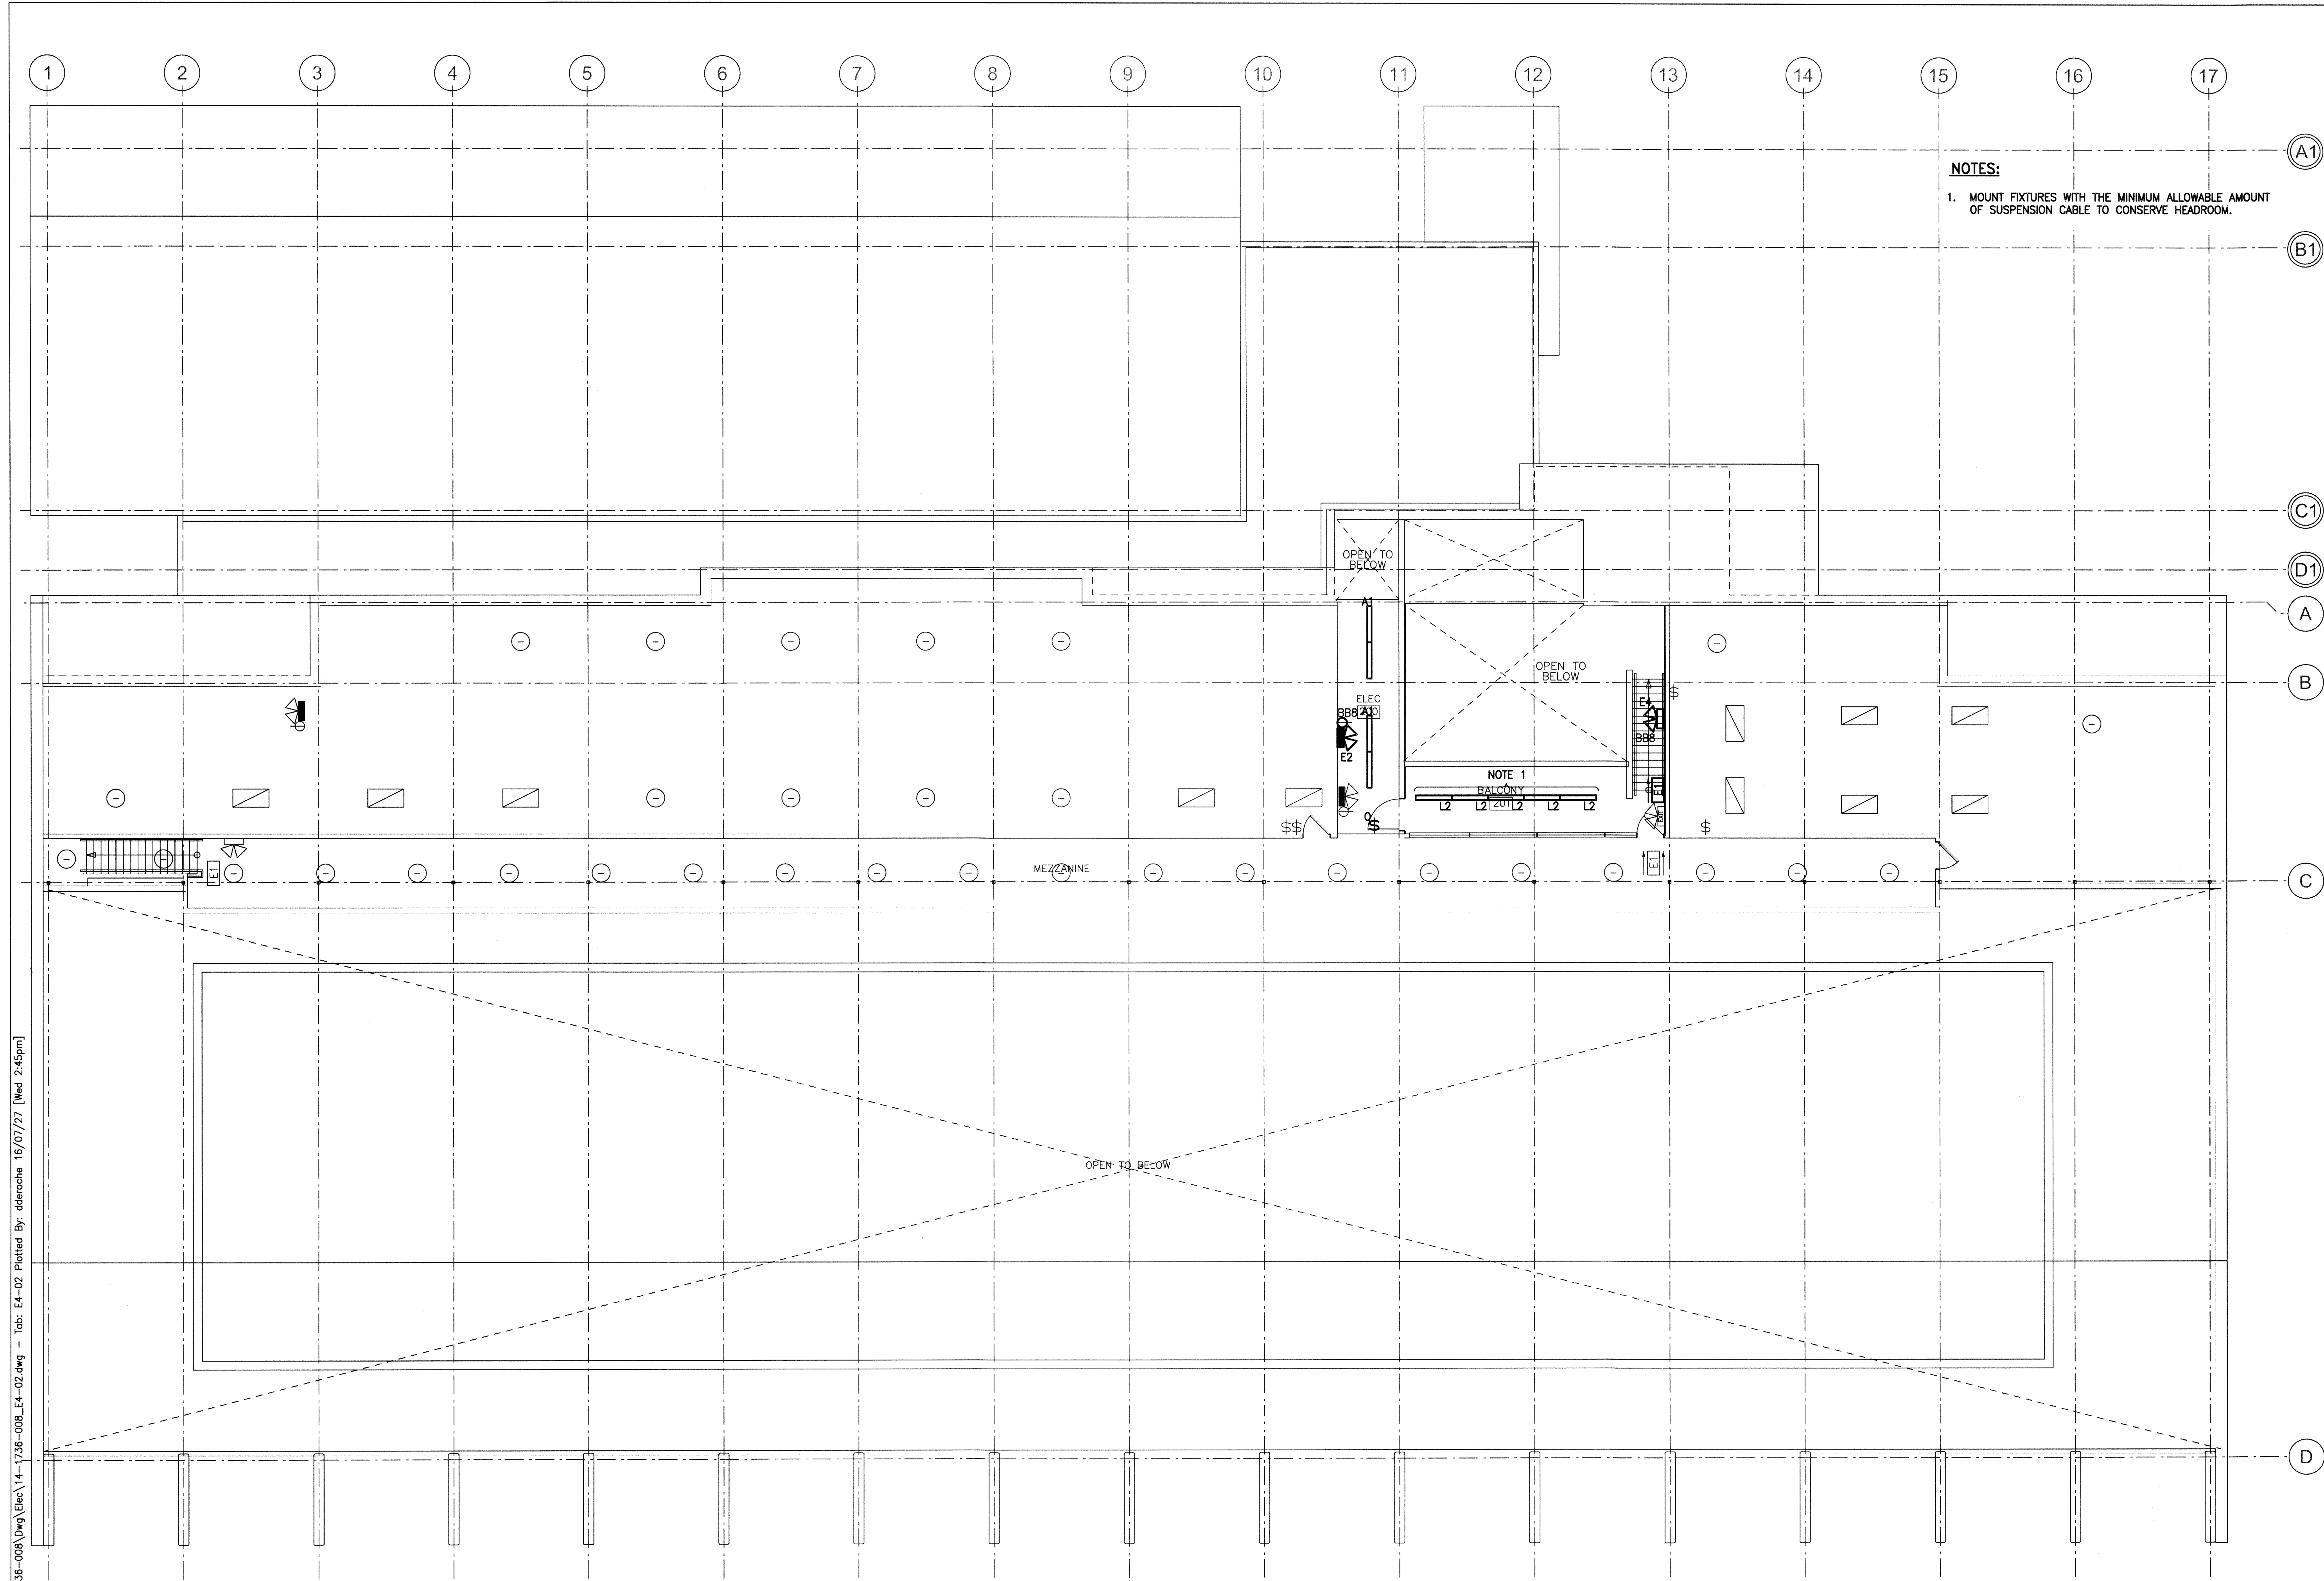

**NOTES:**  
1. MOUNT FIXTURES WITH THE MINIMUM ALLOWABLE AMOUNT OF SUSPENSION CABLE TO CONSERVE HEADROOM.

OPEN TO BELOW  
ELEC  
BBB  
NOTE 1  
BALCONY  
L2 L2 L2

MEZZANINE

OPEN TO BELOW

**1 MEZZANINE LIGHTING PLAN - NEW**  
2000 0 2000 4000 6000 8000  
SCALE: 1:100mm (24"x36")

File Name: P:\Projects\2014\14-1736-008\Elec\14-1736-008\_E4-02.dwg - Tab: E4-02 Plotted By: dderoché 16/07/27 [Wed 2:45pm]

This drawing must not be scaled. The contractor shall verify all dimensions and other data on site prior to commencement of work. All discrepancies, errors, and omissions are to be reported to the architect. Drawing and specifications, as instruments of service, are the property of the architect. The copyright in the same being reserved to him. No reproduction may be made without the permission of the architect, and when made, must bear the name. All prints to be returned to the architect on request.

**SEVEN OAKS POOL RENOVATION & ADDITION**  
BID OPPORTUNITY NO. 645-2016