


File Name: P:\Projects\2014\14-1736-008\DWG\Mech\14-1736-008_M2-02.dwg - Tab: M2-02 Plotted By: dderocher 16/07/13 [Wed 3:50pm]

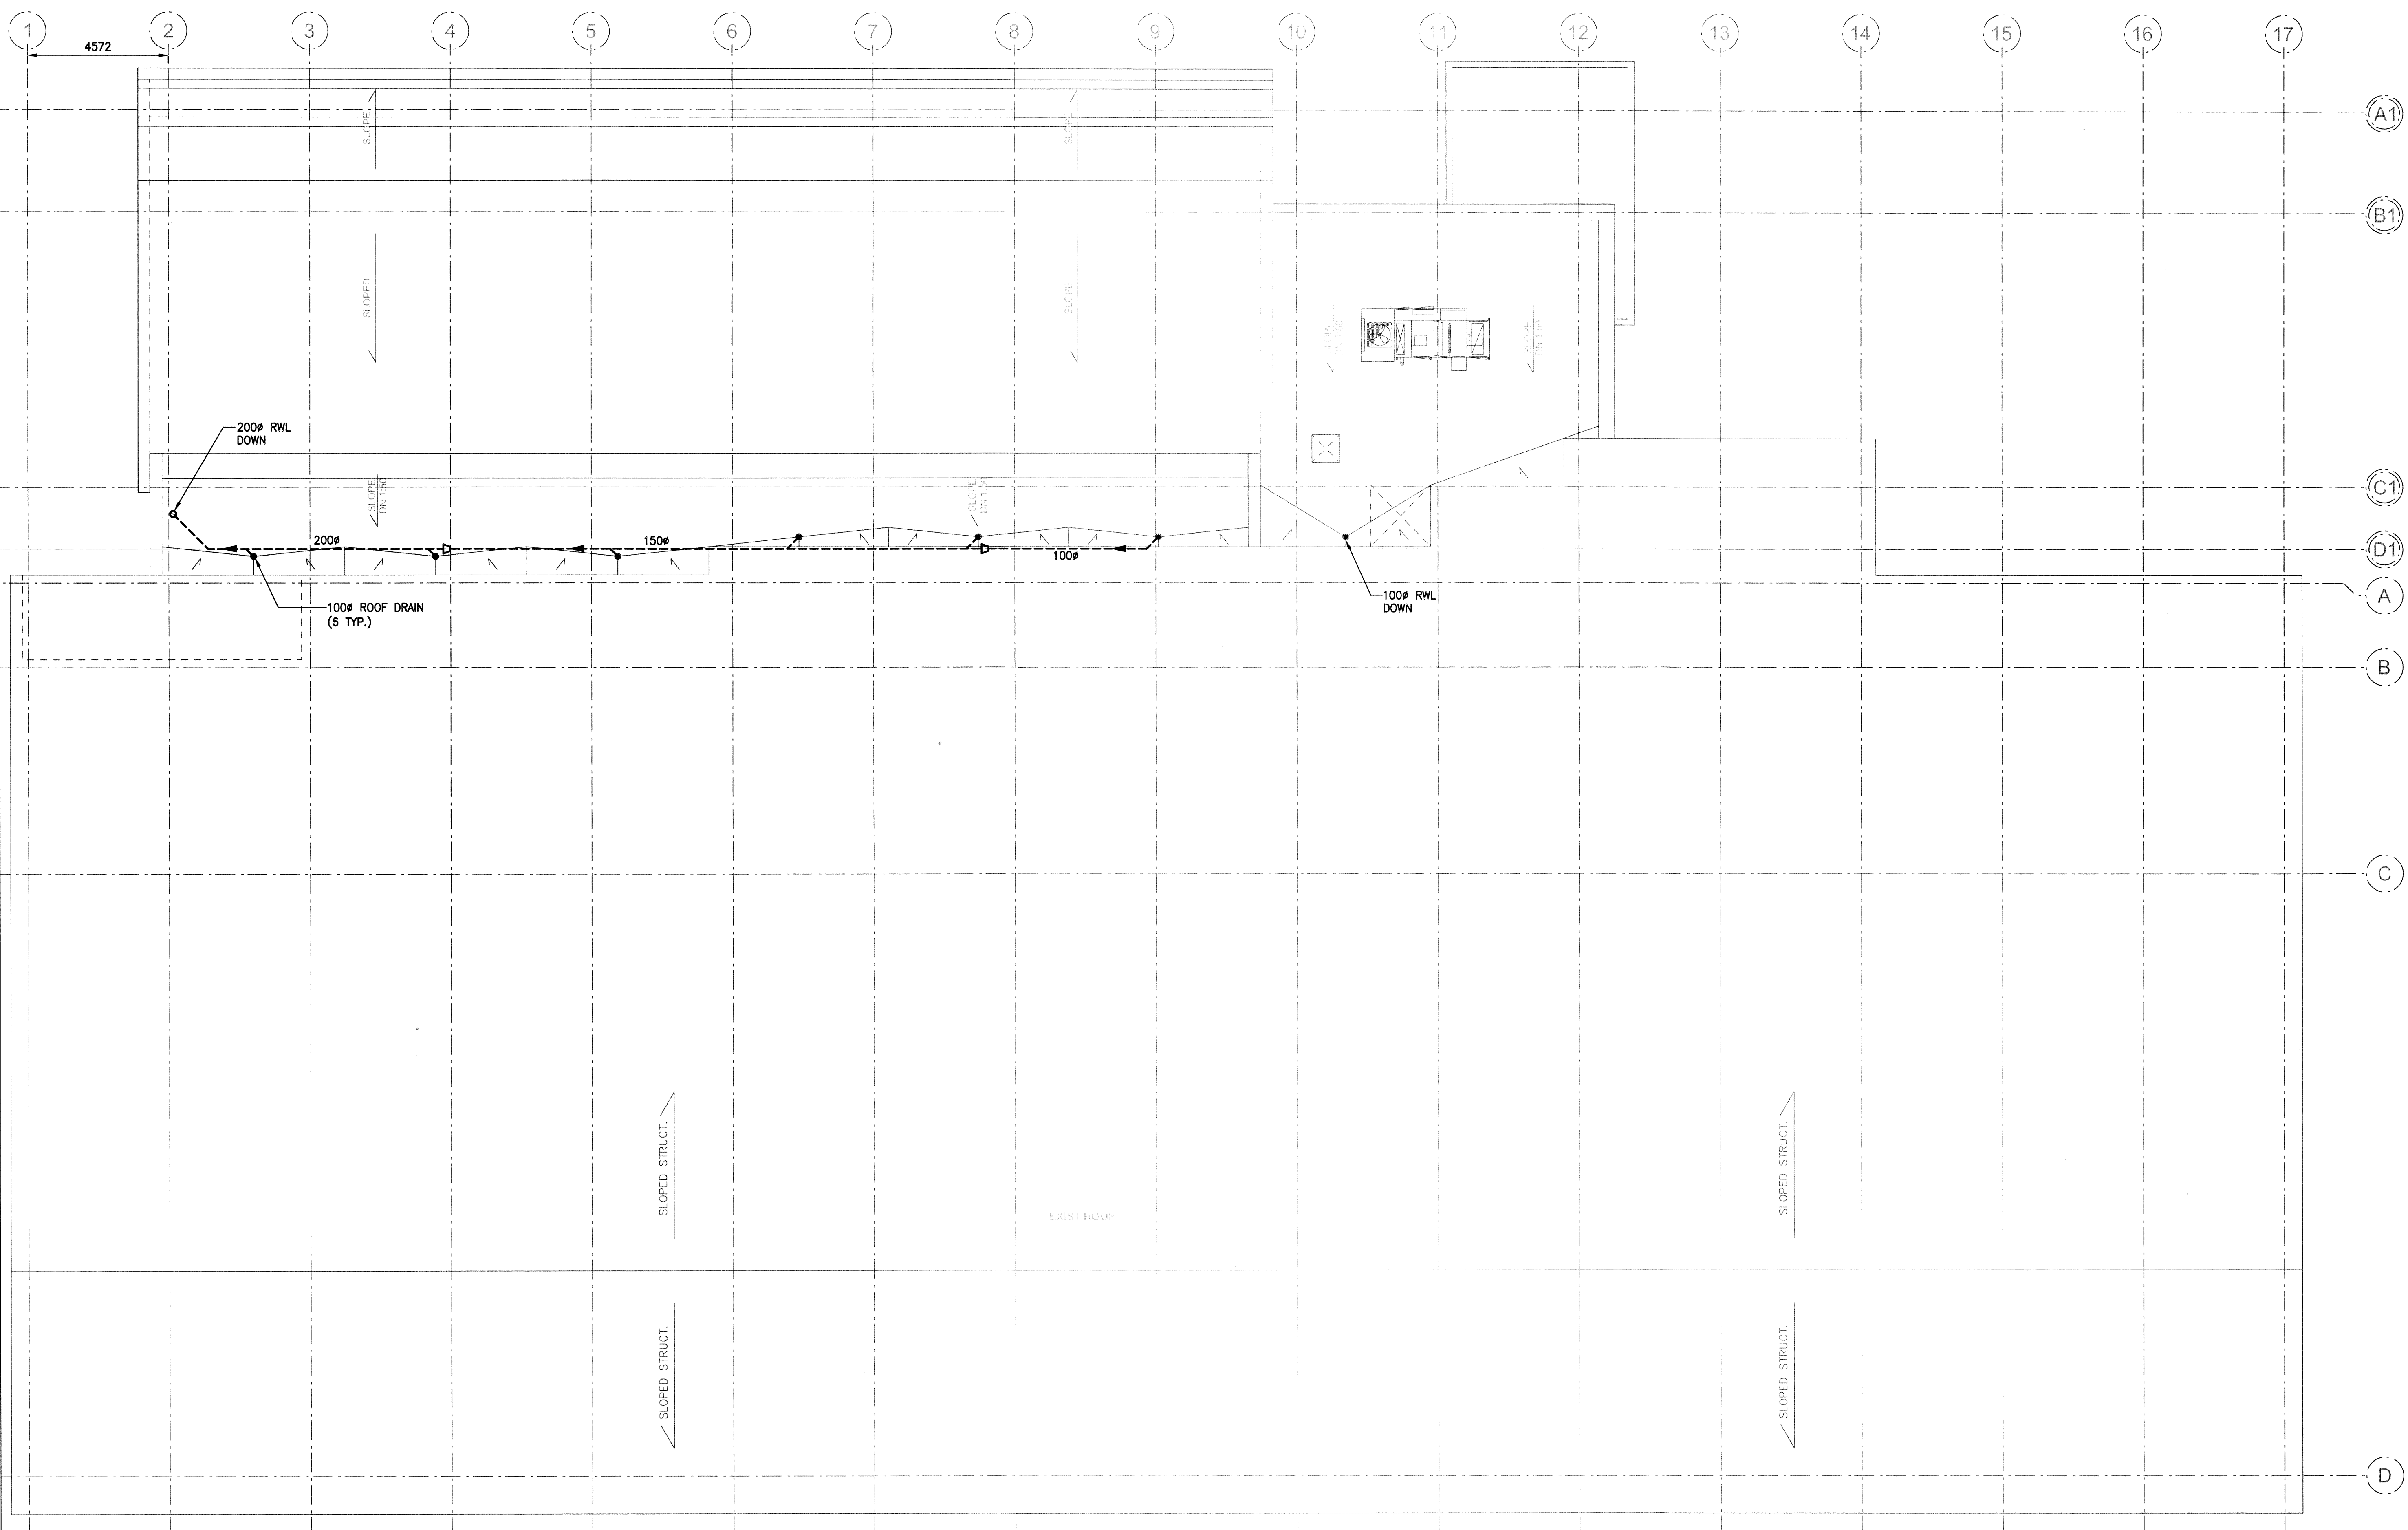

1 ROOF PLAN - NEW ROOF DRAINS


SCALE: 1:100mm (24"x36")

- KEYNOTES:**
- 1 PROVIDE NEW ROOF DRAINS. LOCATION TO BE CONFIRMED.
 - 2 PROVIDE NEW INSULATED RAIN WATER LEADER FROM ROOF DRAINS HUNG FROM UNDERSIDE OF ROOF. PROVIDE PAINTED PVC JACKET TO MATCH WALL COLOUR.

SCALE VERIFIED BY: *AKC*

APEGM
 Certificate of Authorization
 KGS Group
 No. 245

300 - 141 Bannatyne Ave., Winnipeg, MB, R3B 0R3
 telephone 204.956.0938 fax 204.943.5597
 web www.prairiearchitects.ca

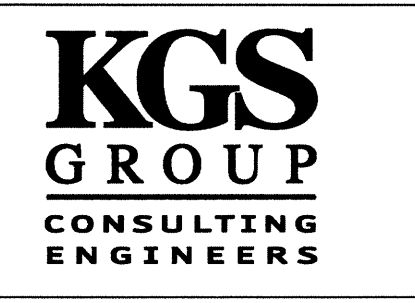

issue / rev.

#	date	issue notes
0	2016/07/15	ISSUED FOR CONSTRUCTION

professional seals

project information

SEVEN OAKS POOL

444 Adsum Drive
 Winnipeg, MB
 Canada

client

City of Winnipeg
 4th Floor - 86 King Street
 Winnipeg, MB

drawing information

MECHANICAL ROOF PLAN NEW PLUMBING

drawn by: RLR
 approved by: *[Signature]*
 scale: AS NOTED
 date issued: 2016.07.15
 proj. #: 14-1736-008
 rev. #: R-0

SEVEN OAKS POOL RENOVATION & ADDITION
 BID OPPORTUNITY NO. 645-2016

This drawing must not be scaled. The contractor shall verify all dimensions and other data on site prior to commencement of work. All discrepancies, errors, and omissions are to be reported to the architect. Drawing and specifications, as instruments of service, are the property of the architect. No reproduction may be made without the permission of the architect, and when made, must bear his name. All projects to be returned to the architect on request.