


KEYNOTES:

- 1 PROVIDE SPRINKLER PROTECTION BENEATH POOL DECK AND BASIN.
- 2 REFER TO DRAWING M5-00 DETAIL 1 FOR SPRINKLER TREE DETAIL.
- 3 PROVIDE WIRE GUARDS ON SPRINKLER HEADS NEAR POOL OR MECHANICAL EQUIPMENT.

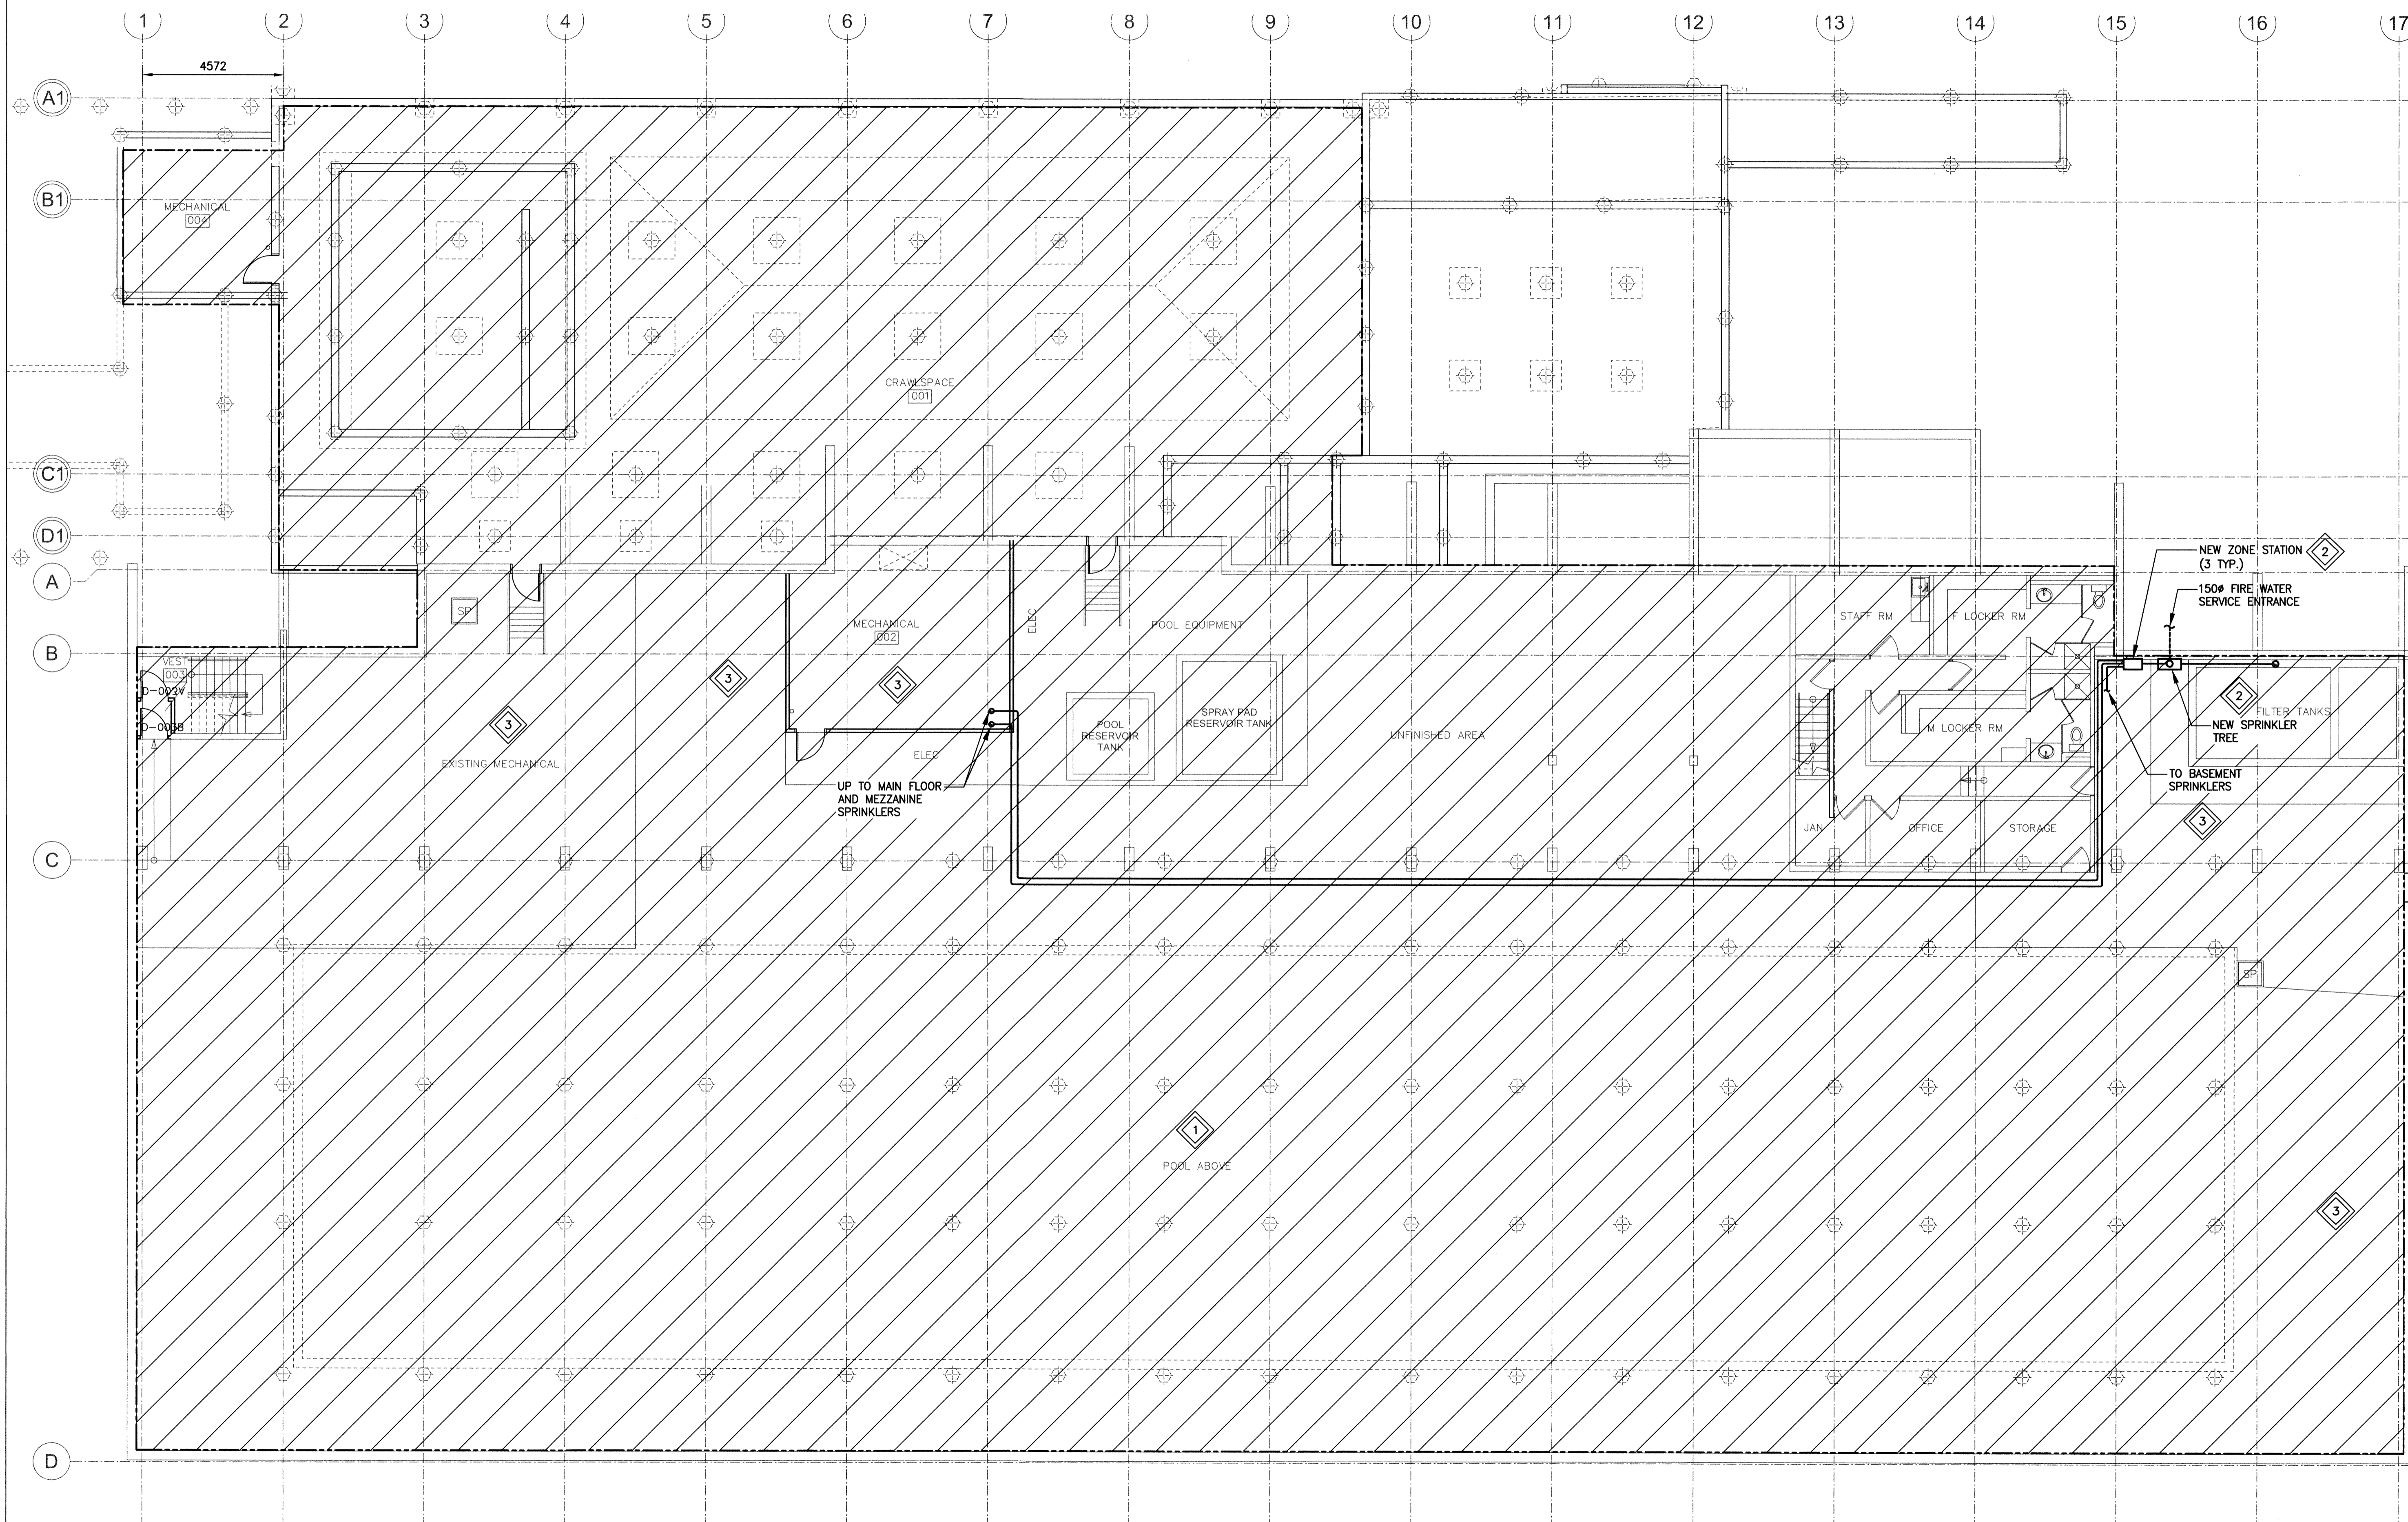

1 BASEMENT PLAN - NEW FIRE PROTECTION
SCALE: 1:100

SCALE VERIFIED BY: *MC*



issue / rev.

issue / rev.	date	issue notes
0	2016/07/15	ISSUED FOR CONSTRUCTION

professional seals



project information

SEVEN OAKS POOL
444 Adsum Drive
Winnipeg, MB
Canada

client

City of Winnipeg
4th Floor - 86 King Street
Winnipeg, MB

drawing information

MECHANICAL BASEMENT FLOOR PLAN NEW FIRE PROTECTION
drawn by: RLR
approved by: *AA*
scale: AS NOTED
date issued: 2016.07.15
proj. #: 14-1736-008
rev. #: R-0

SEVEN OAKS POOL RENOVATION & ADDITION
BID OPPORTUNITY NO. 645-2016

M4 00

File Name: P:\Projects\2014\14-1736-008\DWG\Mech\14-1736-008_M4-00.dwg - Tab: M4-00 Plotted By: dderoché 16/07/13 [Wed 4:47pm]

This drawing must not be scaled. The contractor shall verify all dimensions and other data on site prior to commencement of work. All discrepancies, errors, and omissions are to be reported to the architect. Drawing and specifications, as instruments of service, are the property of the architect. No reproduction may be made without the permission of the architect, and when made, must bear the name. All prints to be returned to the architect on request.